


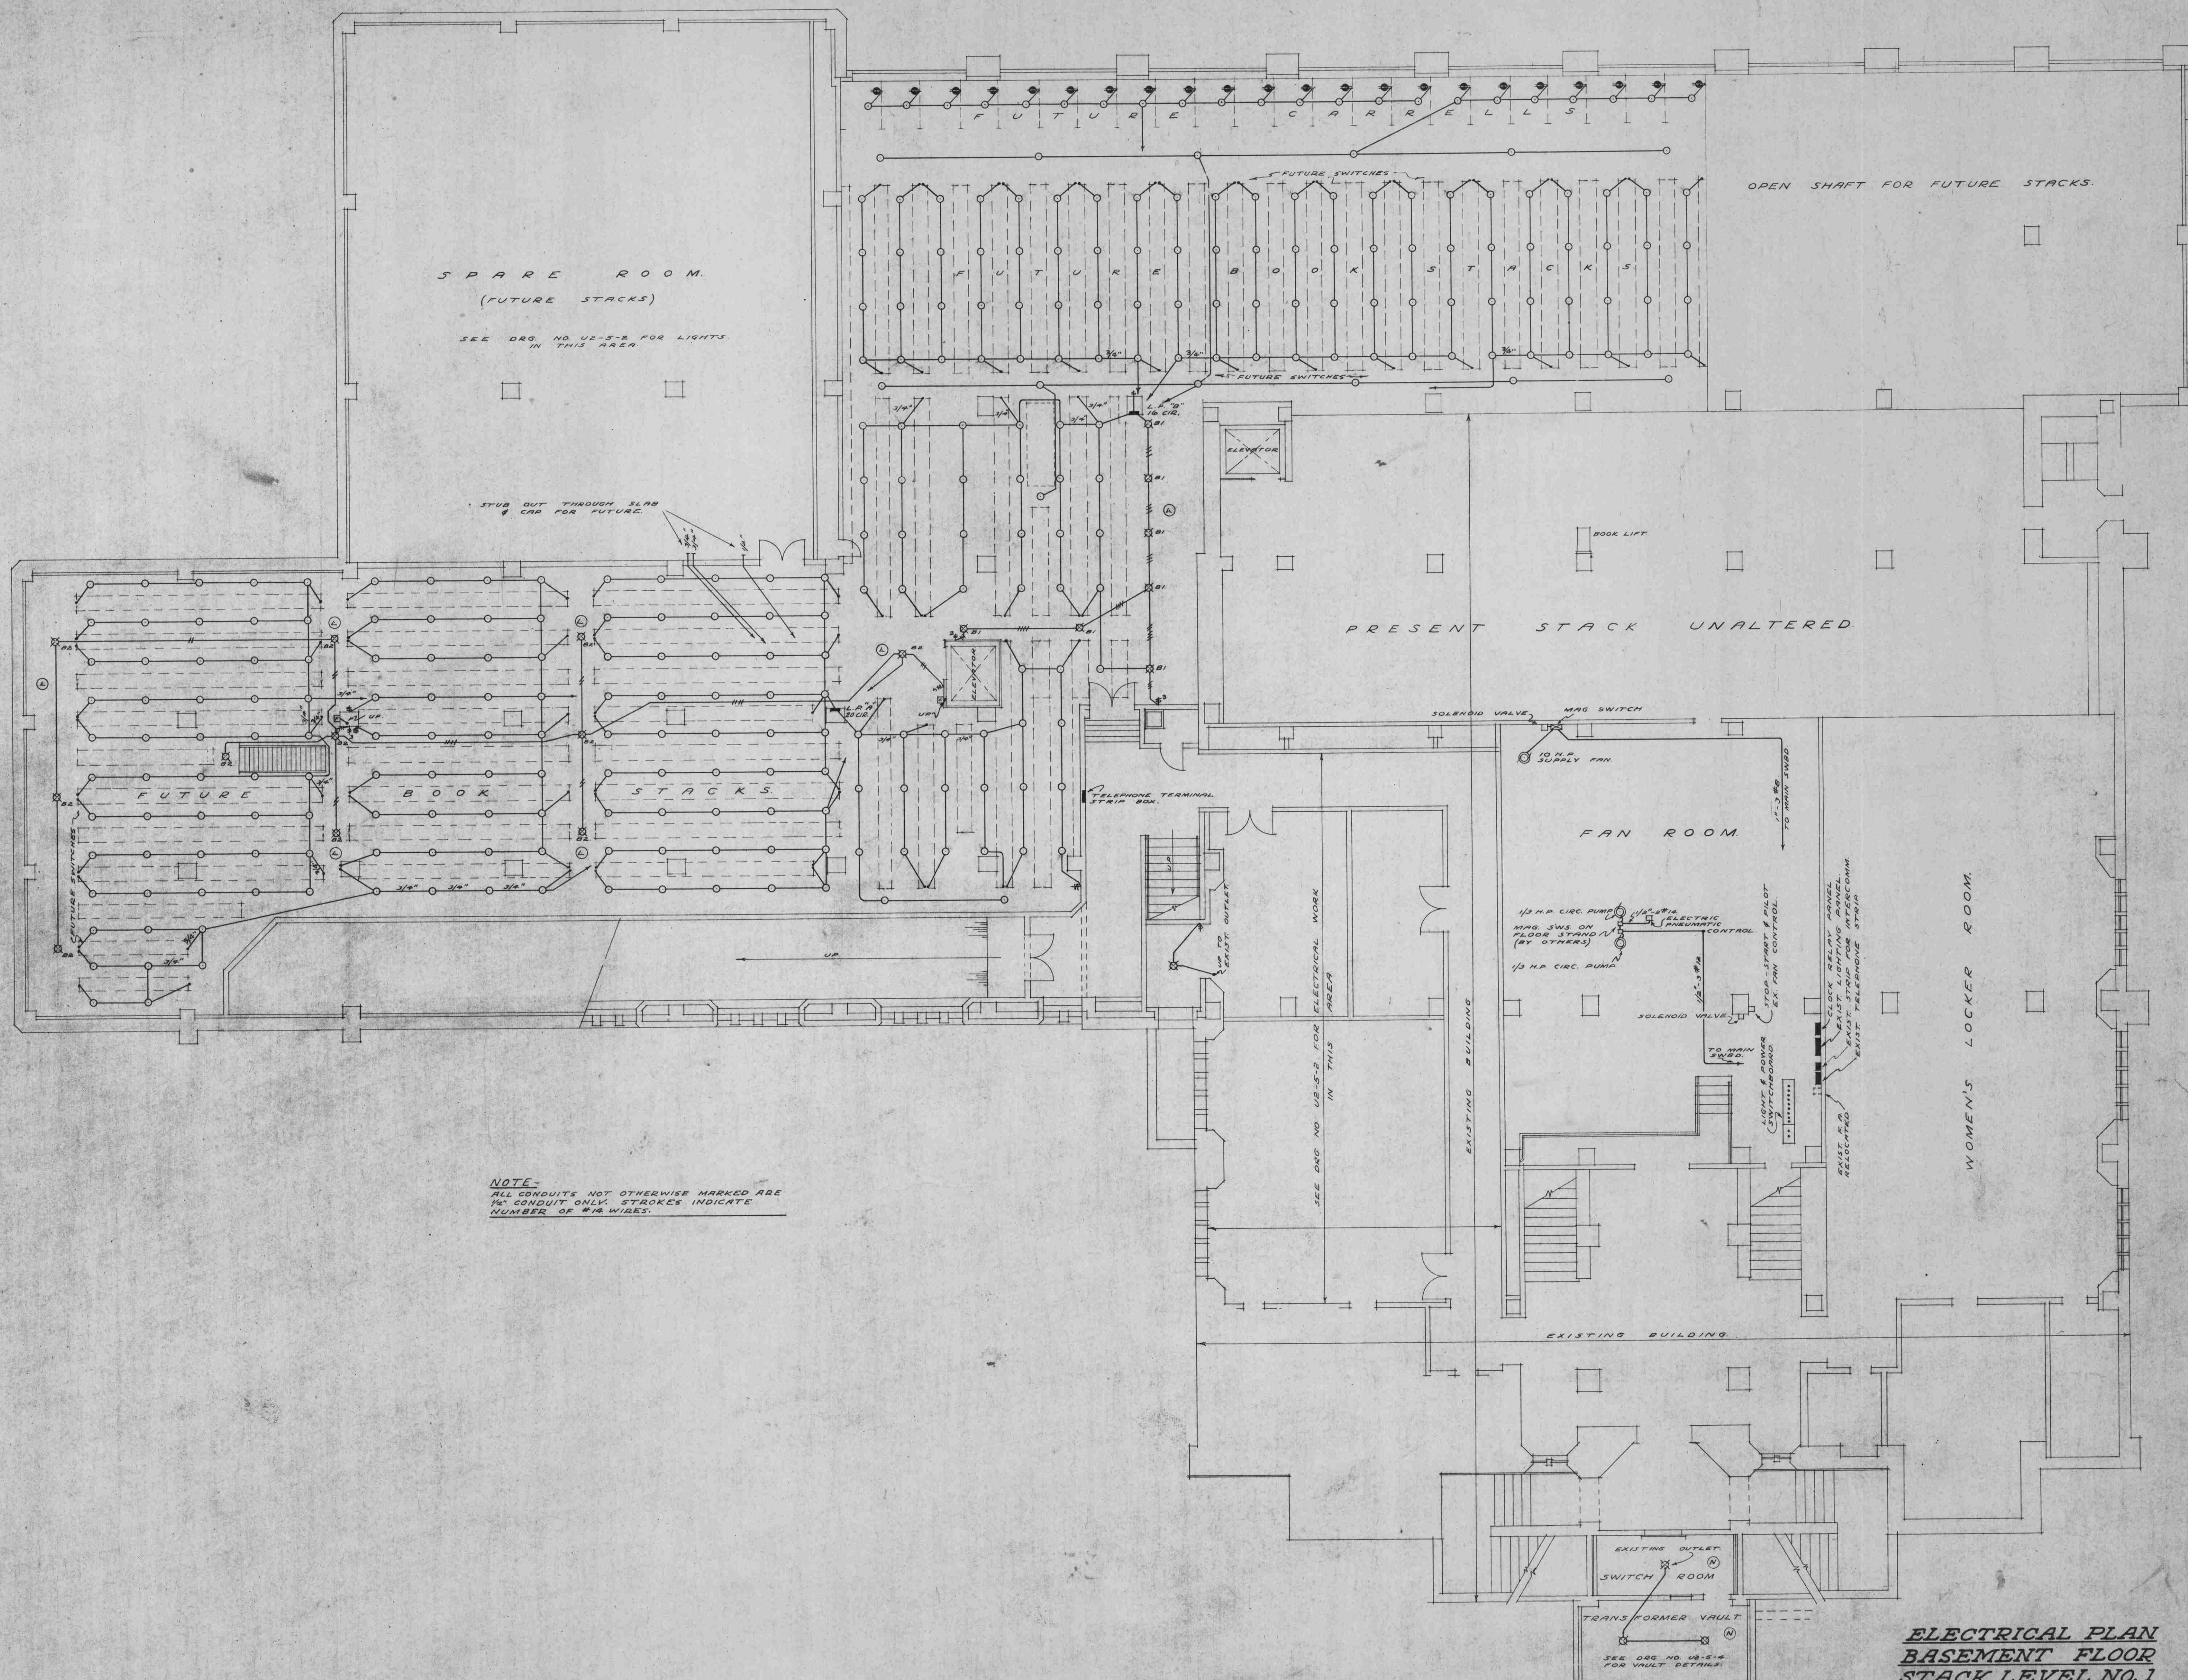

NOTE:
ALL CONDUITS NOT OTHERWISE MARKED ARE
1/2" CONDUIT ONLY. STROKES INDICATE
NUMBER OF #12 WIRES.

**ELECTRICAL PLAN
BASEMENT FLOOR
STACK LEVEL NO. 1**

REVISION DATE 28 APRIL 1947	ADDITION TO LIBRARY		SCALE 1/8" = 1'-0"
	UNIVERSITY OF B.C.		DATE 25 JULY, 1946
	A. EDWARD SIMPSON ELECTRICAL ENGINEER VANCOUVER, B. C.	SHARP & THOMPSON ARCHITECTS VANCOUVER, B. C.	DRAWING NO. U2-5-1