



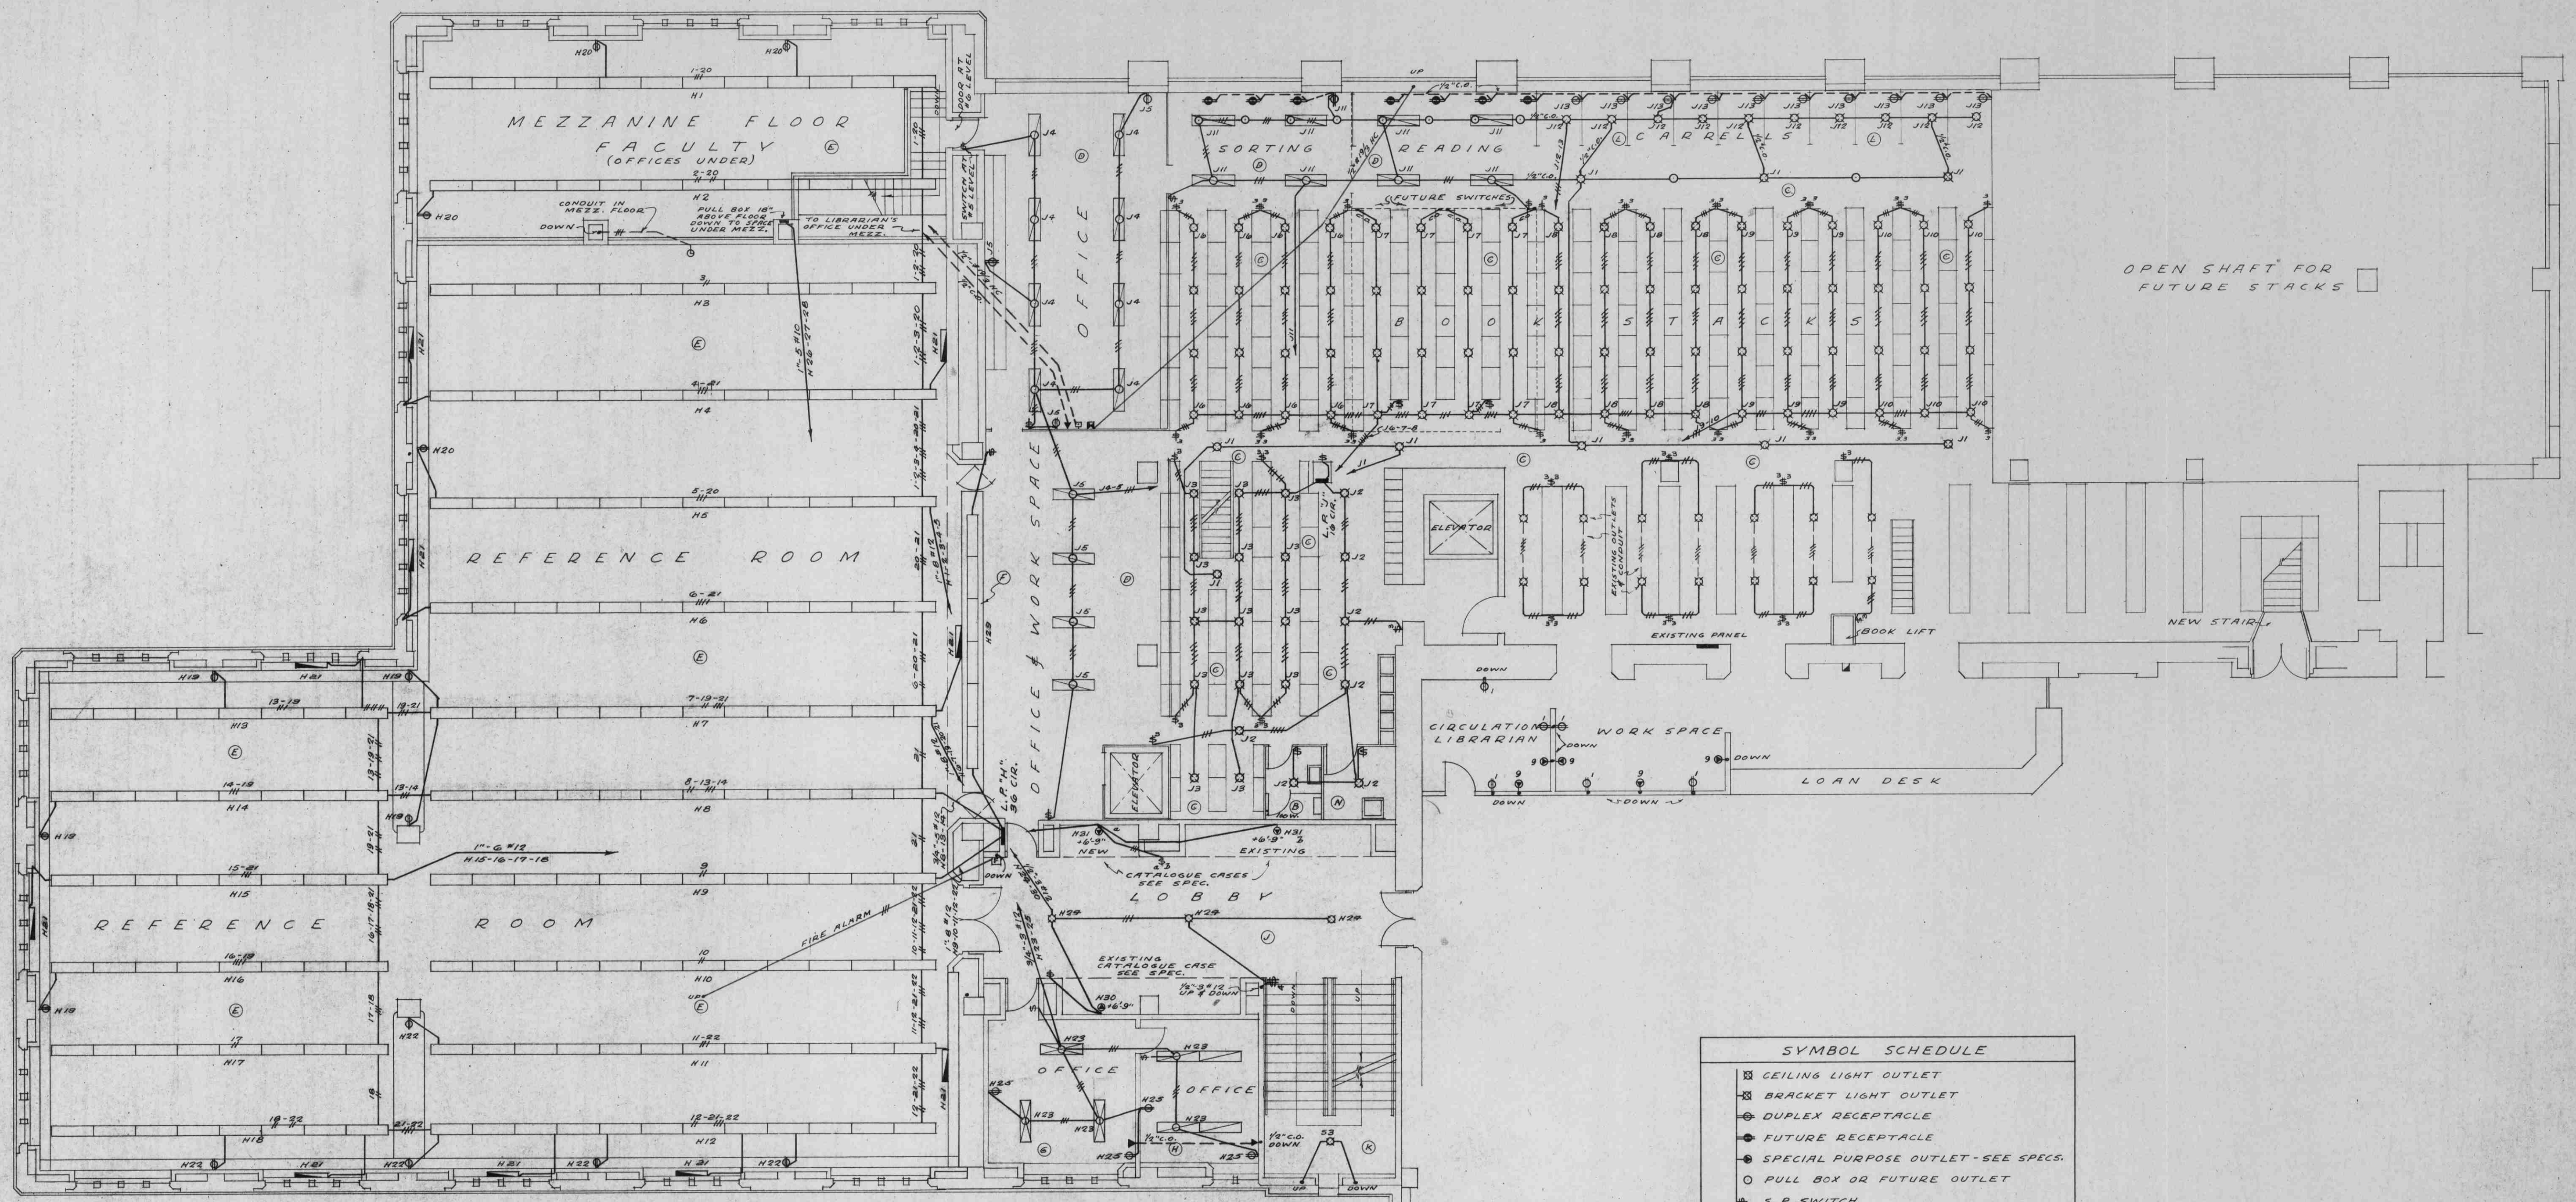


OPEN SHAFT FOR
FUTURE STACKS

SYMBOL SCHEDULE	
	CEILING LIGHT OUTLET
	BRACKET LIGHT OUTLET
	DUPLEX RECEPTACLE
	FUTURE RECEPTACLE
	SPECIAL PURPOSE OUTLET - SEE SPECS.
	PULL BOX OR FUTURE OUTLET
	S.A. SWITCH
	3 WAY SWITCH
	4 WAY SWITCH
	BELL TRANSFORMER
	BUZZER
	PUSH BUTTON
	MAGNAPHONE-MASTER STATION
	MAGNAPHONE-SUB STATION
	TELEPHONE OUTLET
	SECONDARY CLOCK
	FIRE ALARM STATION
	MOTOR
	FLUSH FLUOR. FIXTURE - 1/40w.
	SURFACE FLUOR. FIXTURE - 1/40w.
	SURFACE FLUOR. FIXTURE - 1/40w.
	GERMICIDAL FIXTURE
	CONDUIT IN CEILING
	CONDUIT IN FLOOR

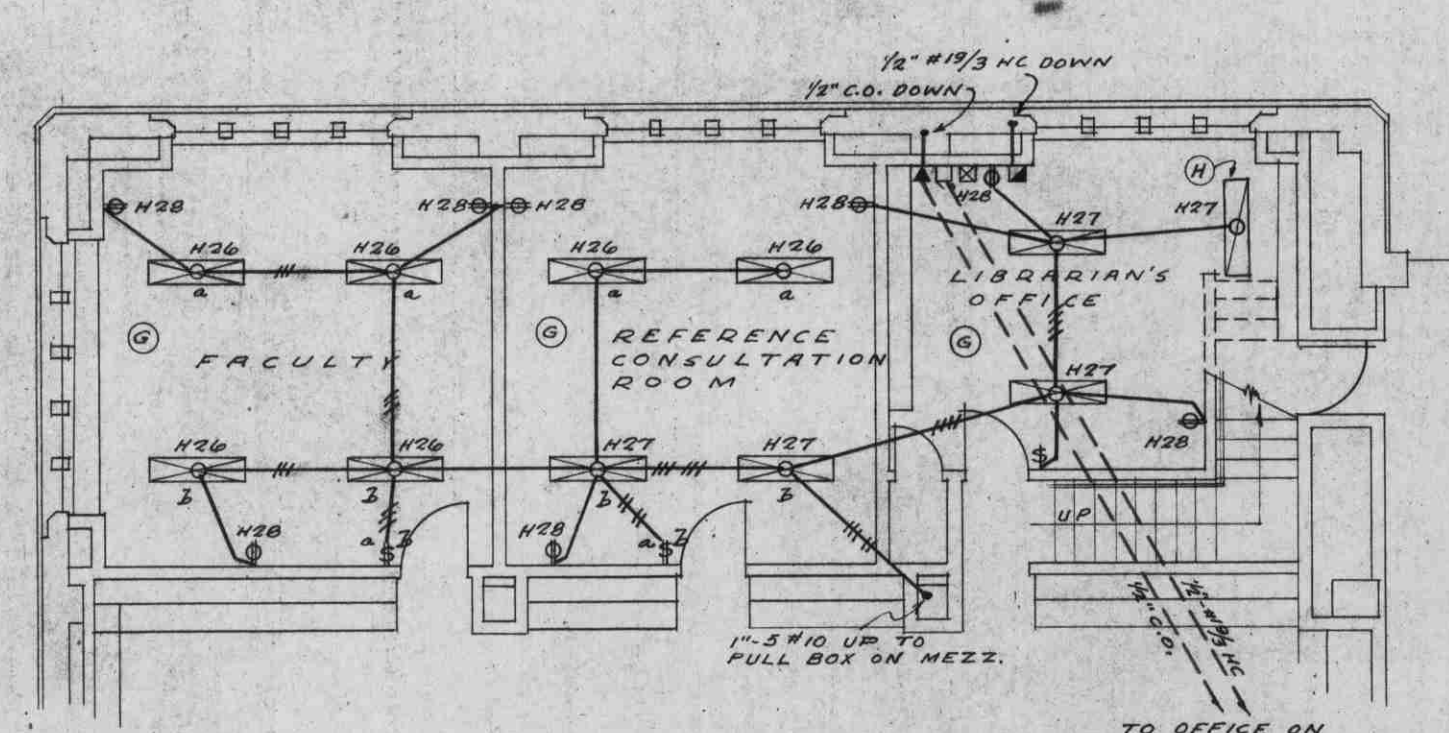

AREA UNDER MEZZANINE
STACK LEVEL NO. 5

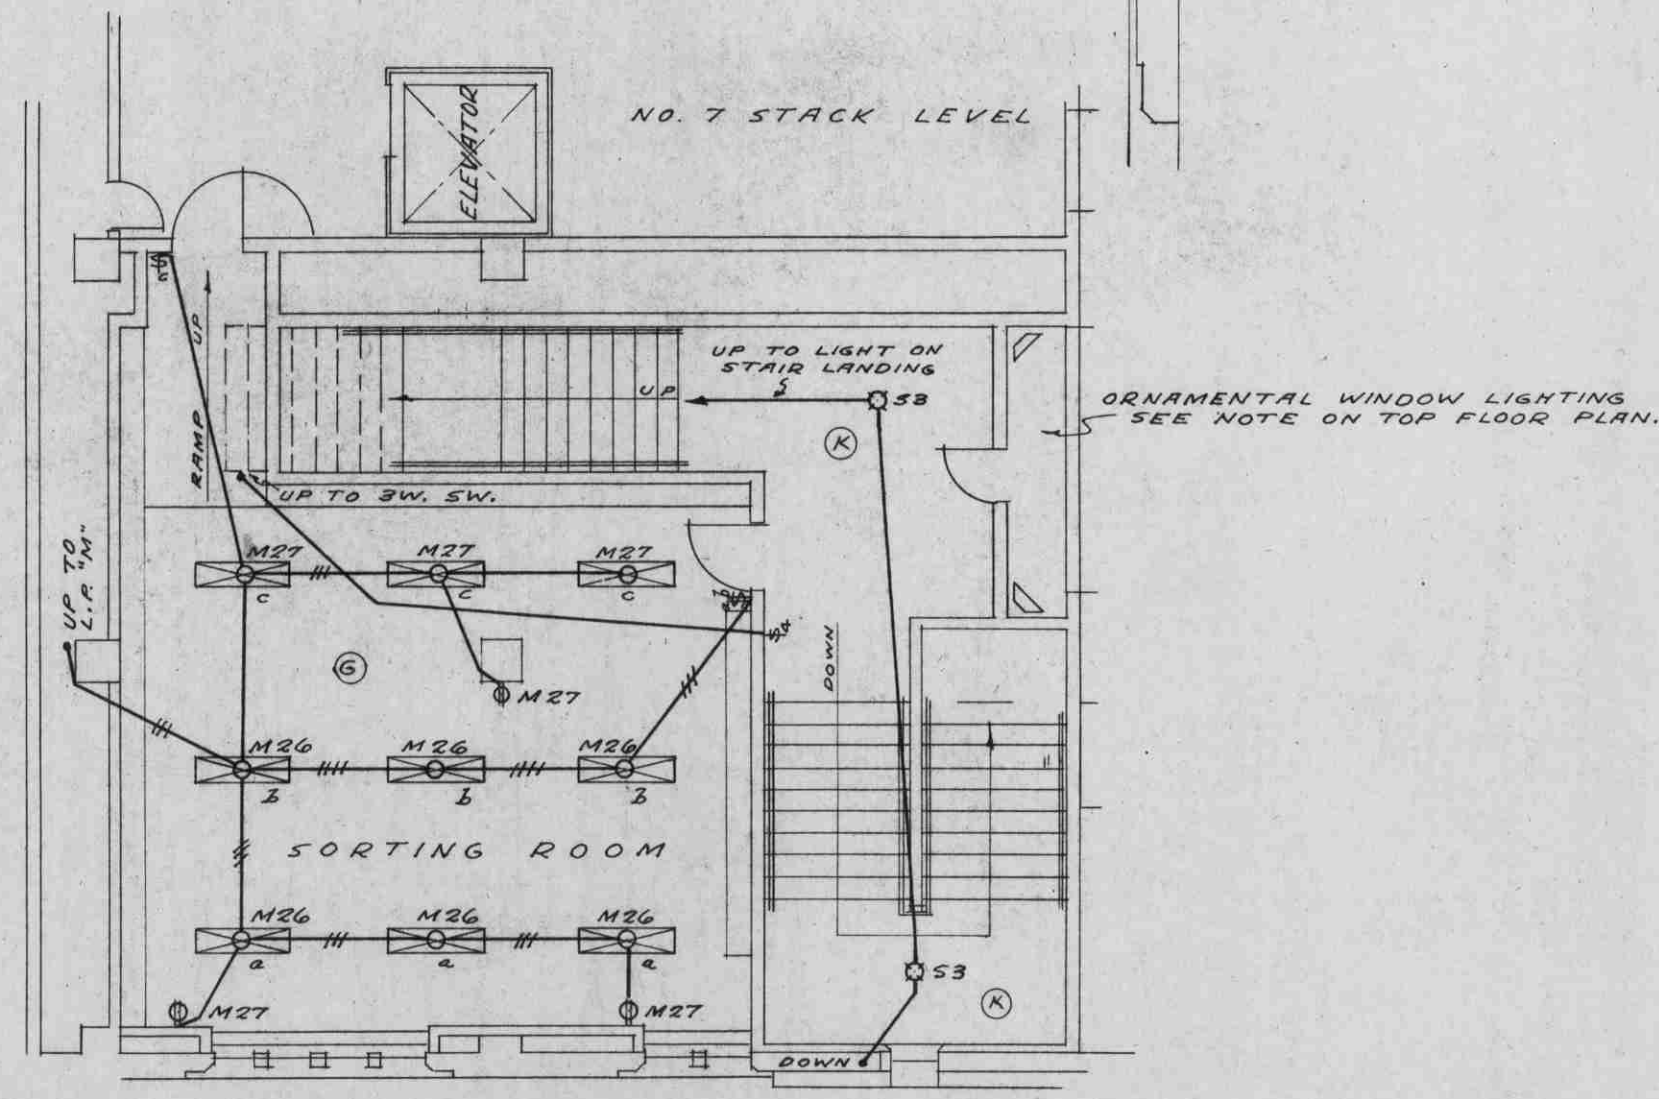

MEZZANINE FLOOR
STACK LEVEL NO. 7

NOTE -
ALL CONDUITS NOT OTHERWISE MARKED ARE
1/2" AND CONTAIN 2 WIRE EXCEPT IN
STACK AREAS WHERE 1/4" IS USED.

ELECTRICAL PLAN
MAIN CONCOURSE FLOOR
STACK LEVEL NO. 5

REVISION DATE		ADDITION TO LIBRARY		SCALE
25 JULY 47		UNIVERSITY OF B.C.		1/8" = 1'-0"
A. EDWARD SIMPSON ELECTRICAL ENGINEER VANCOUVER, B.C.		SHARP & THOMPSON ARCHITECTS VANCOUVER, B.C.		DATE 25 JULY, 1946
				DRAWING NO. U2-5-5