



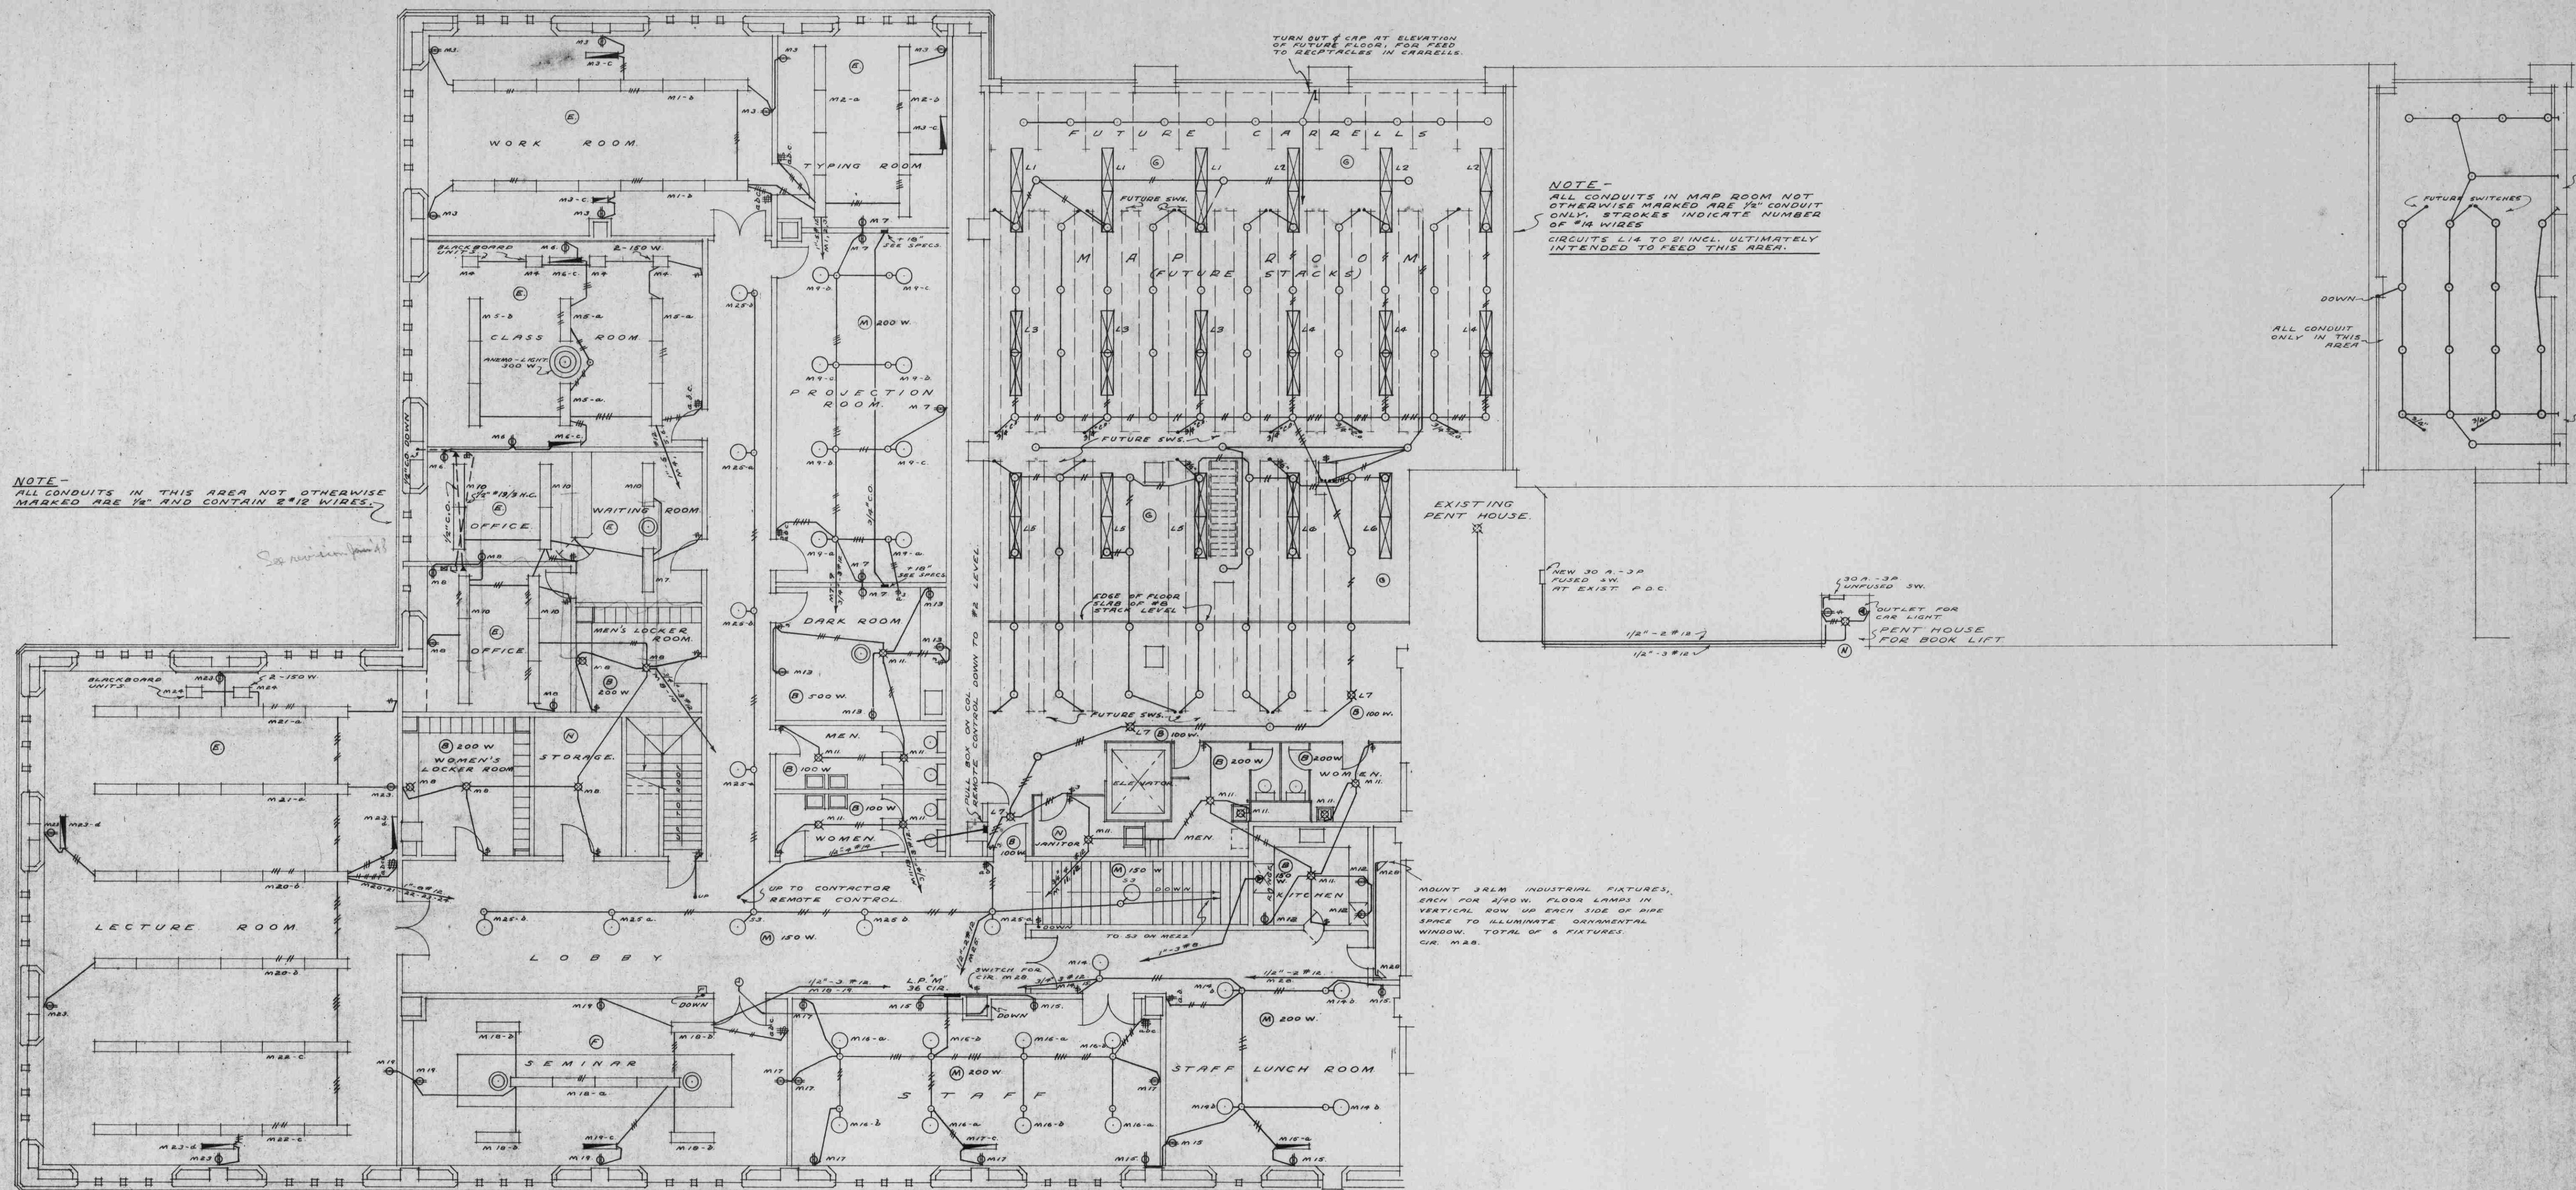

TOP FLOOR - STACK LEVEL NO. 8

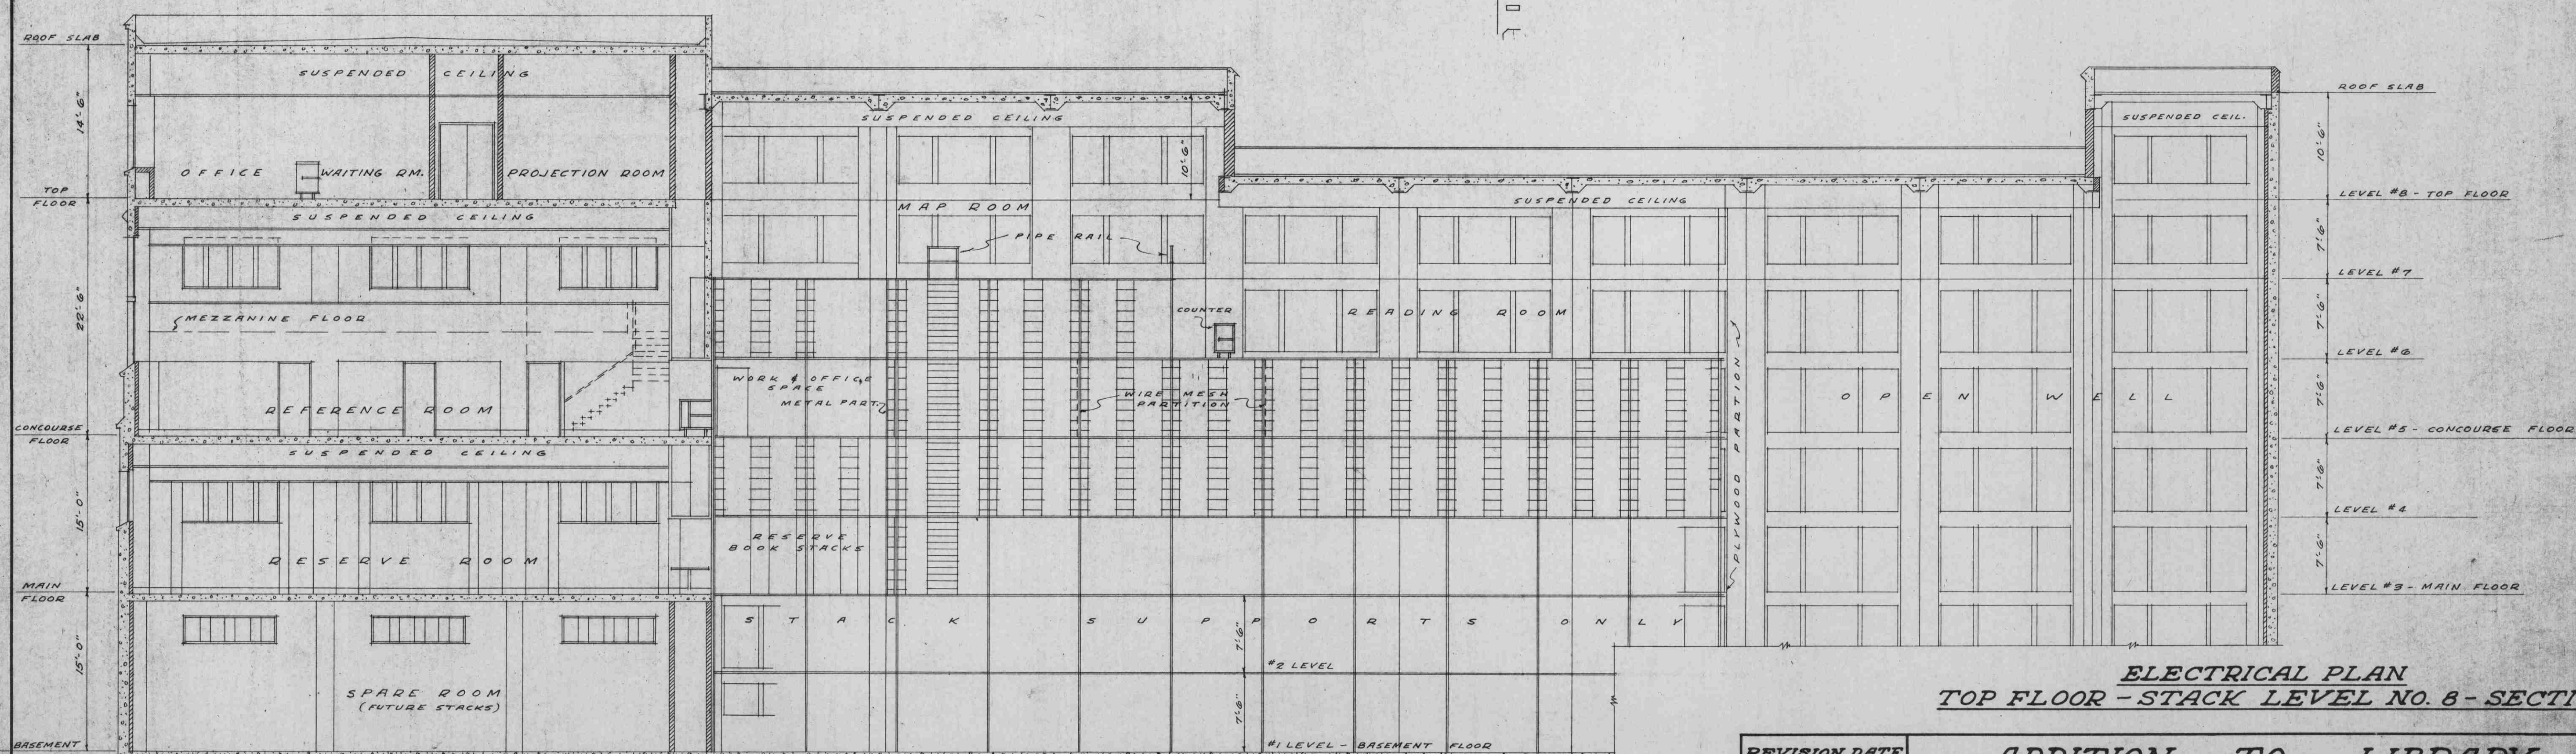

SECTION THROUGH STACKS

ELECTRICAL PLAN
TOP FLOOR - STACK LEVEL NO. 8 - SECTION

REVISION DATE 28 JULY 1947	ADDITION TO LIBRARY		SCALE 1/8" = 1'-0"
	UNIVERSITY OF B.C.		DATE 25 JULY 1946
	A. EDWARD SIMPSON ELECTRICAL ENGINEER VANCOUVER, B.C.	SHARP & THOMPSON ARCHITECTS VANCOUVER, B.C.	DRAWING NO. U2-5-7