


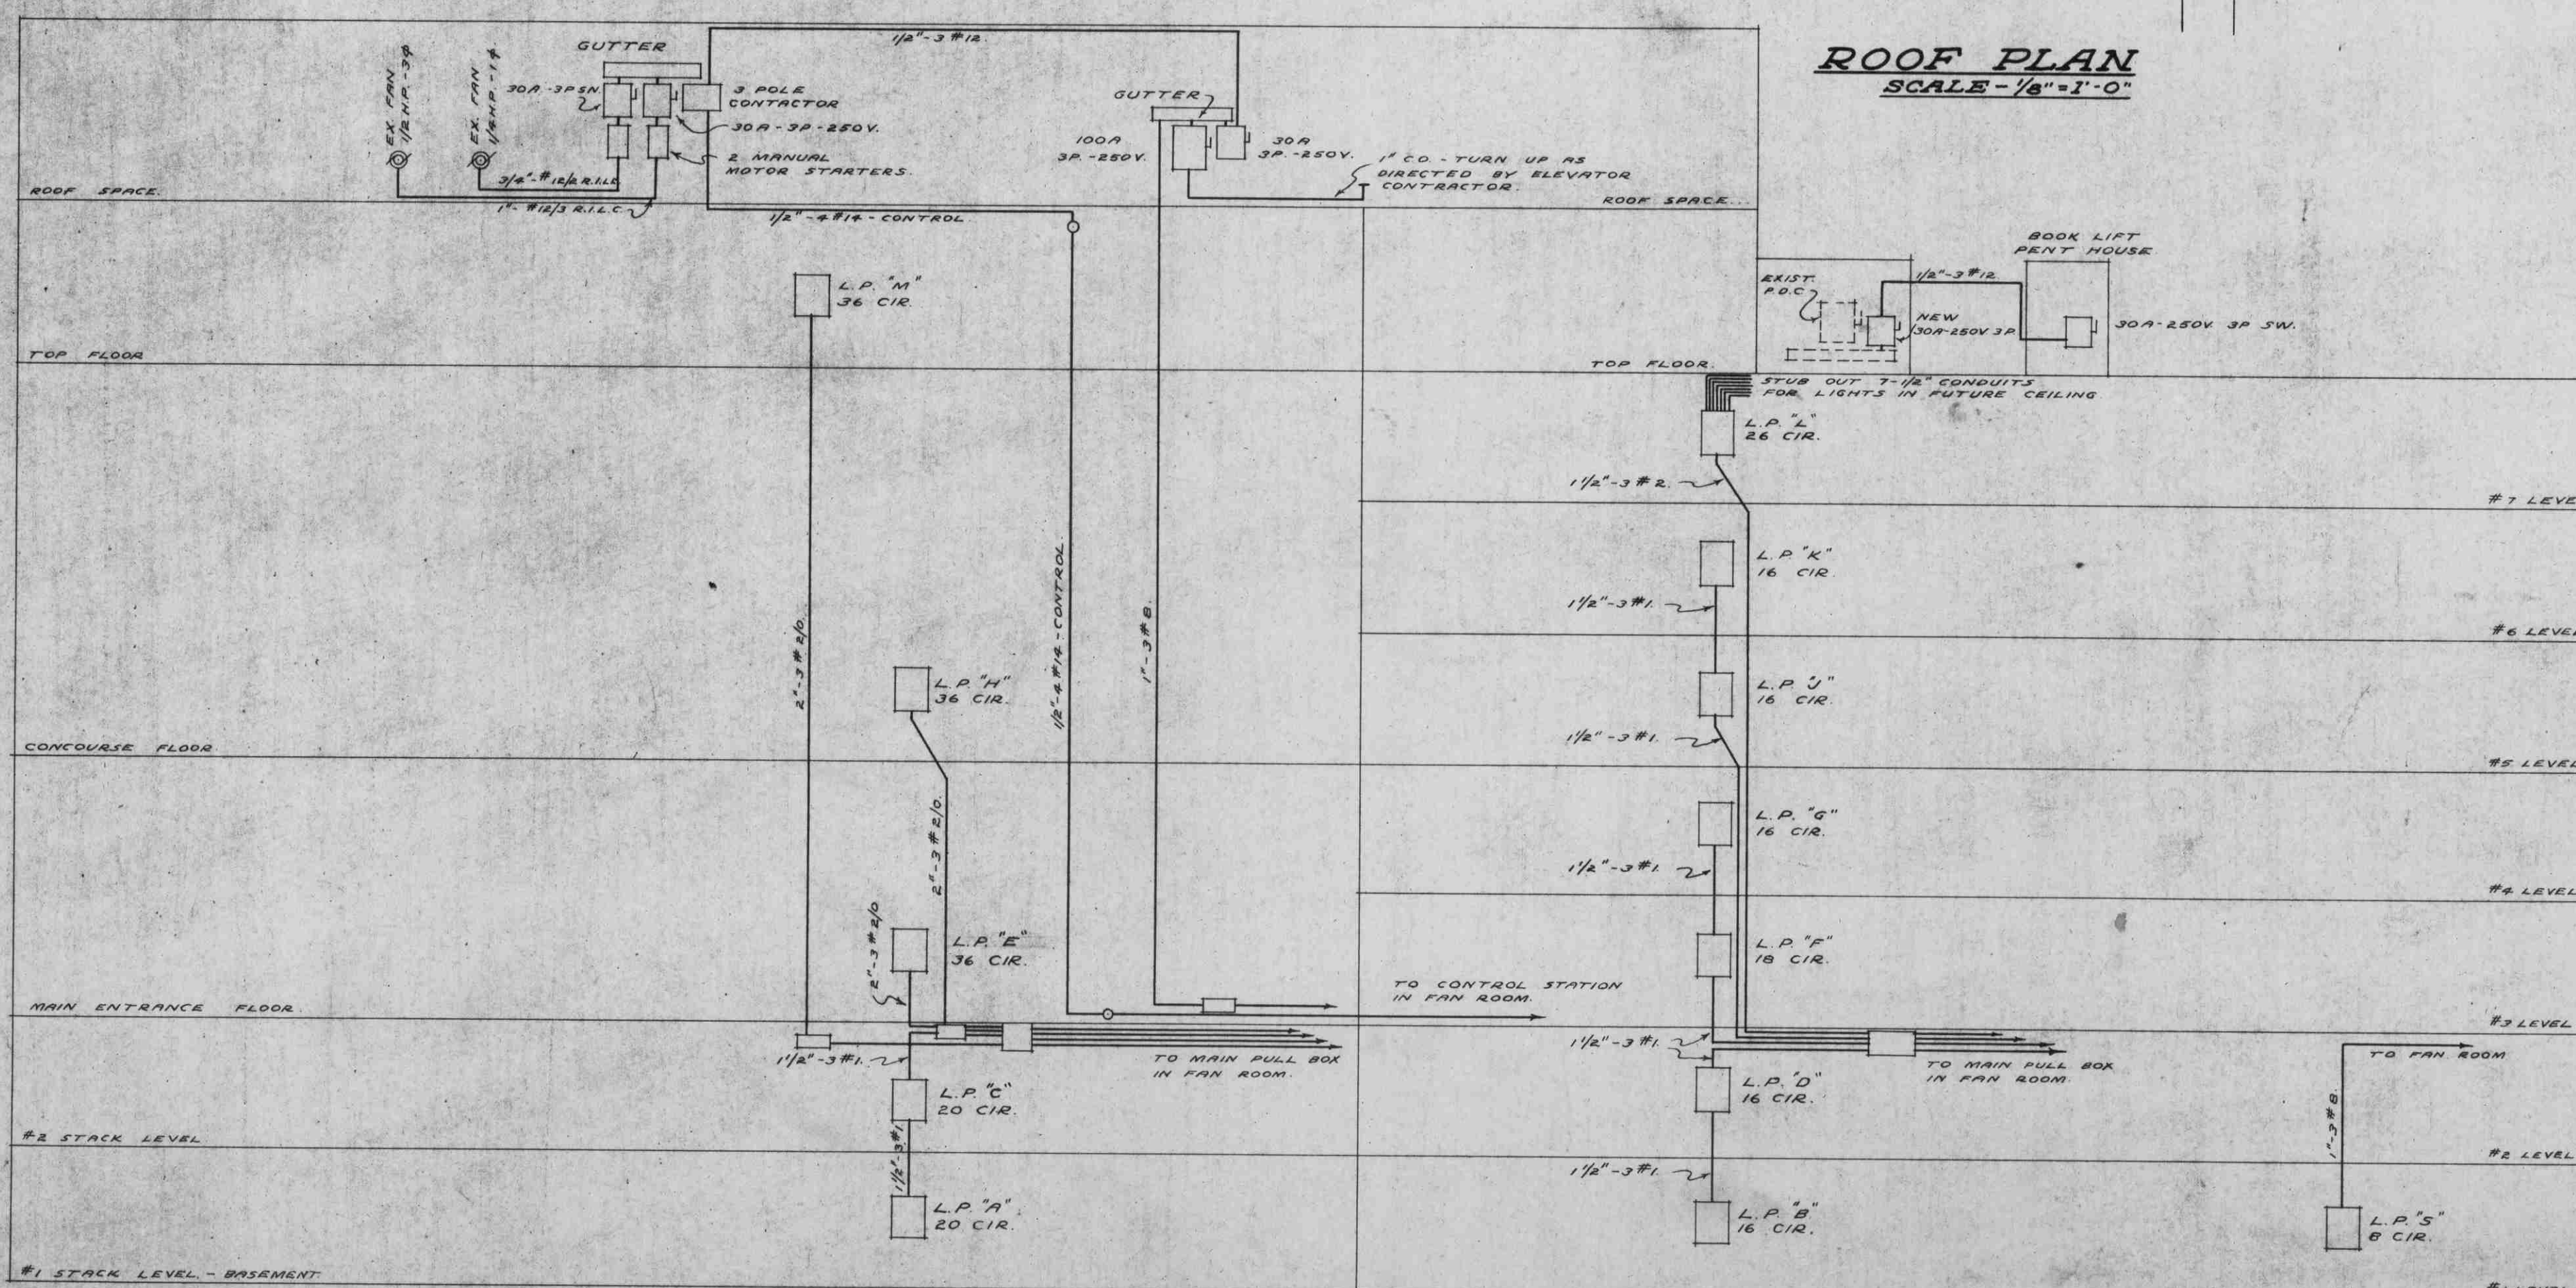


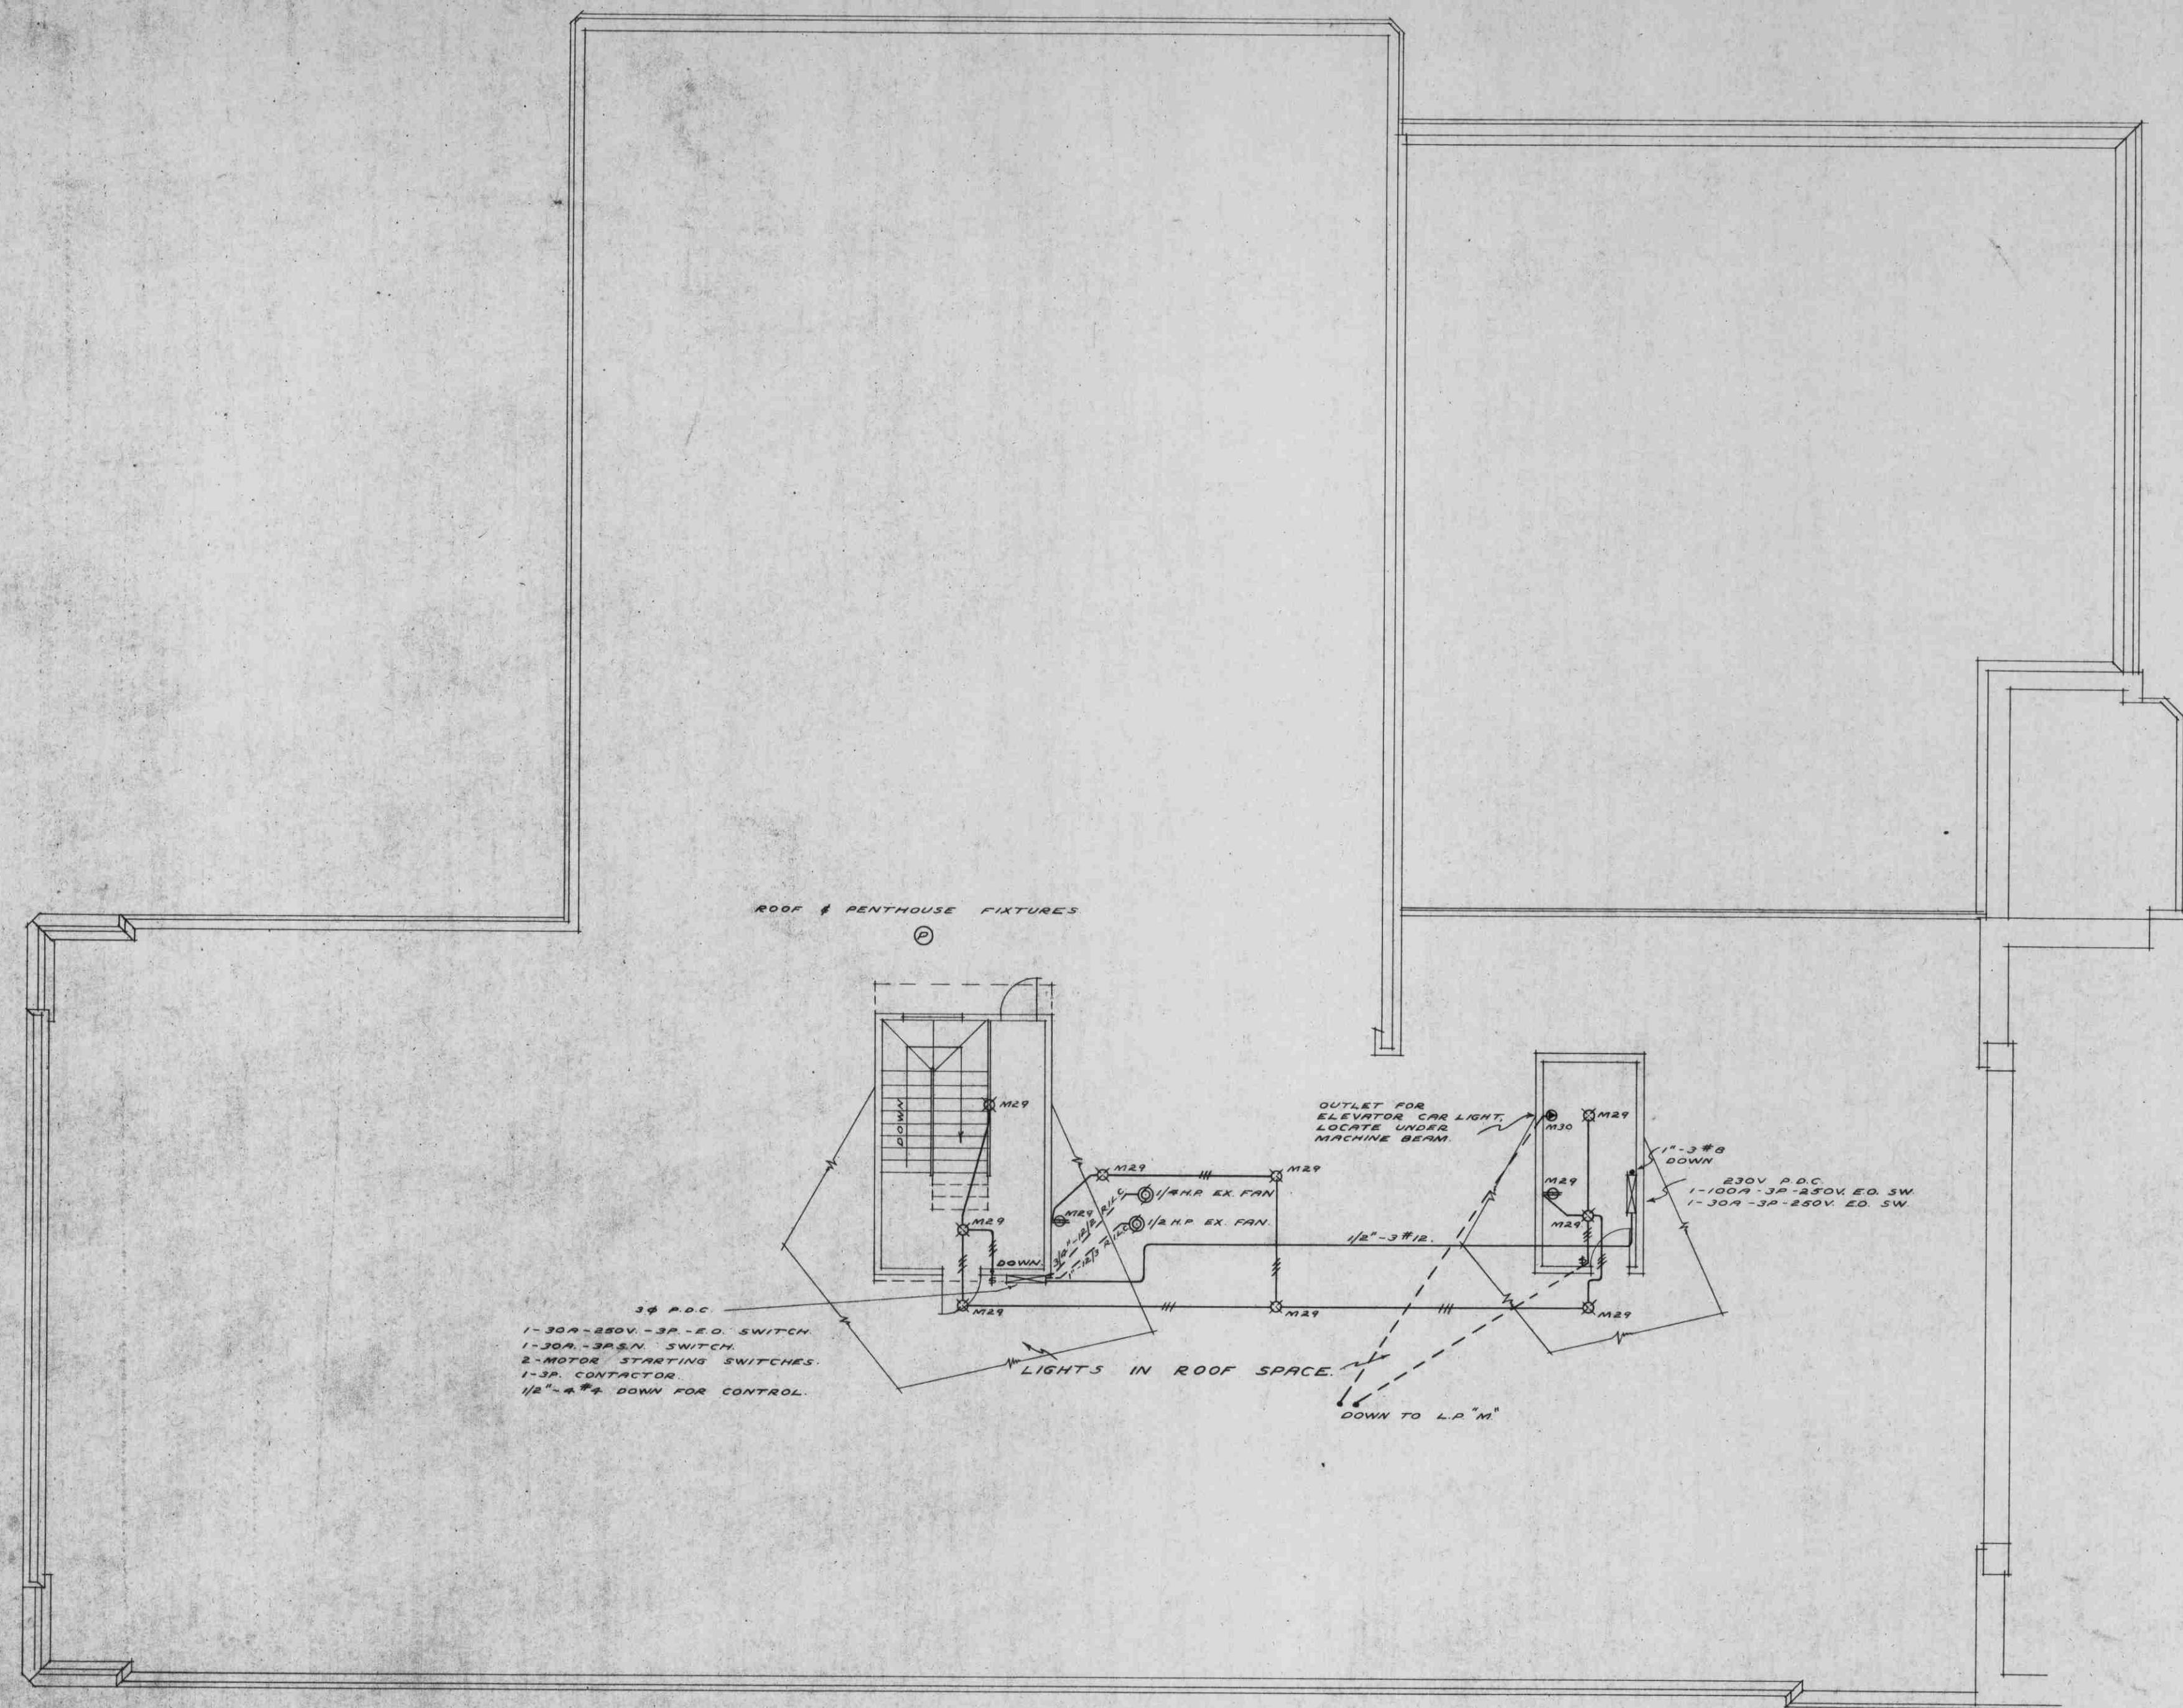

LIGHT & POWER RISER DIAGRAM
NOT TO SCALE

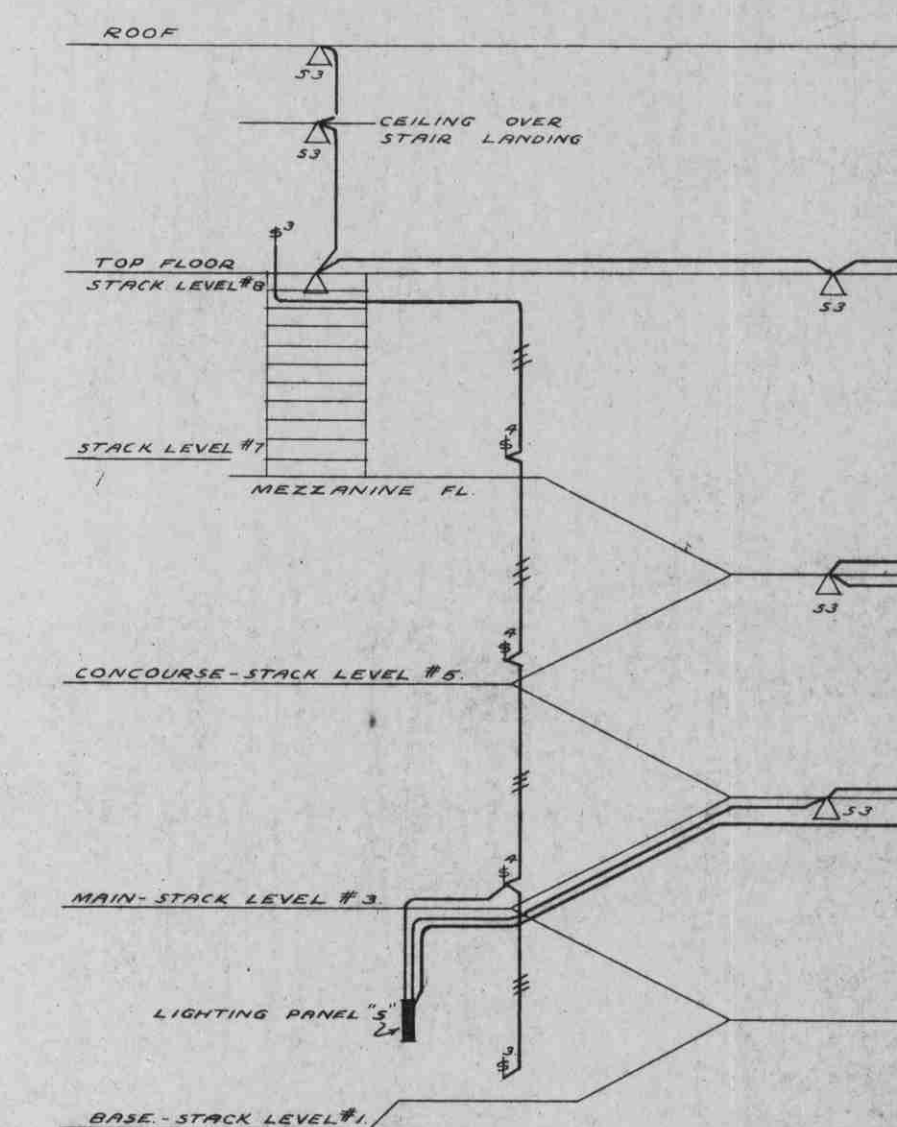

STAIR RISER DIAGRAM
NOT TO SCALE

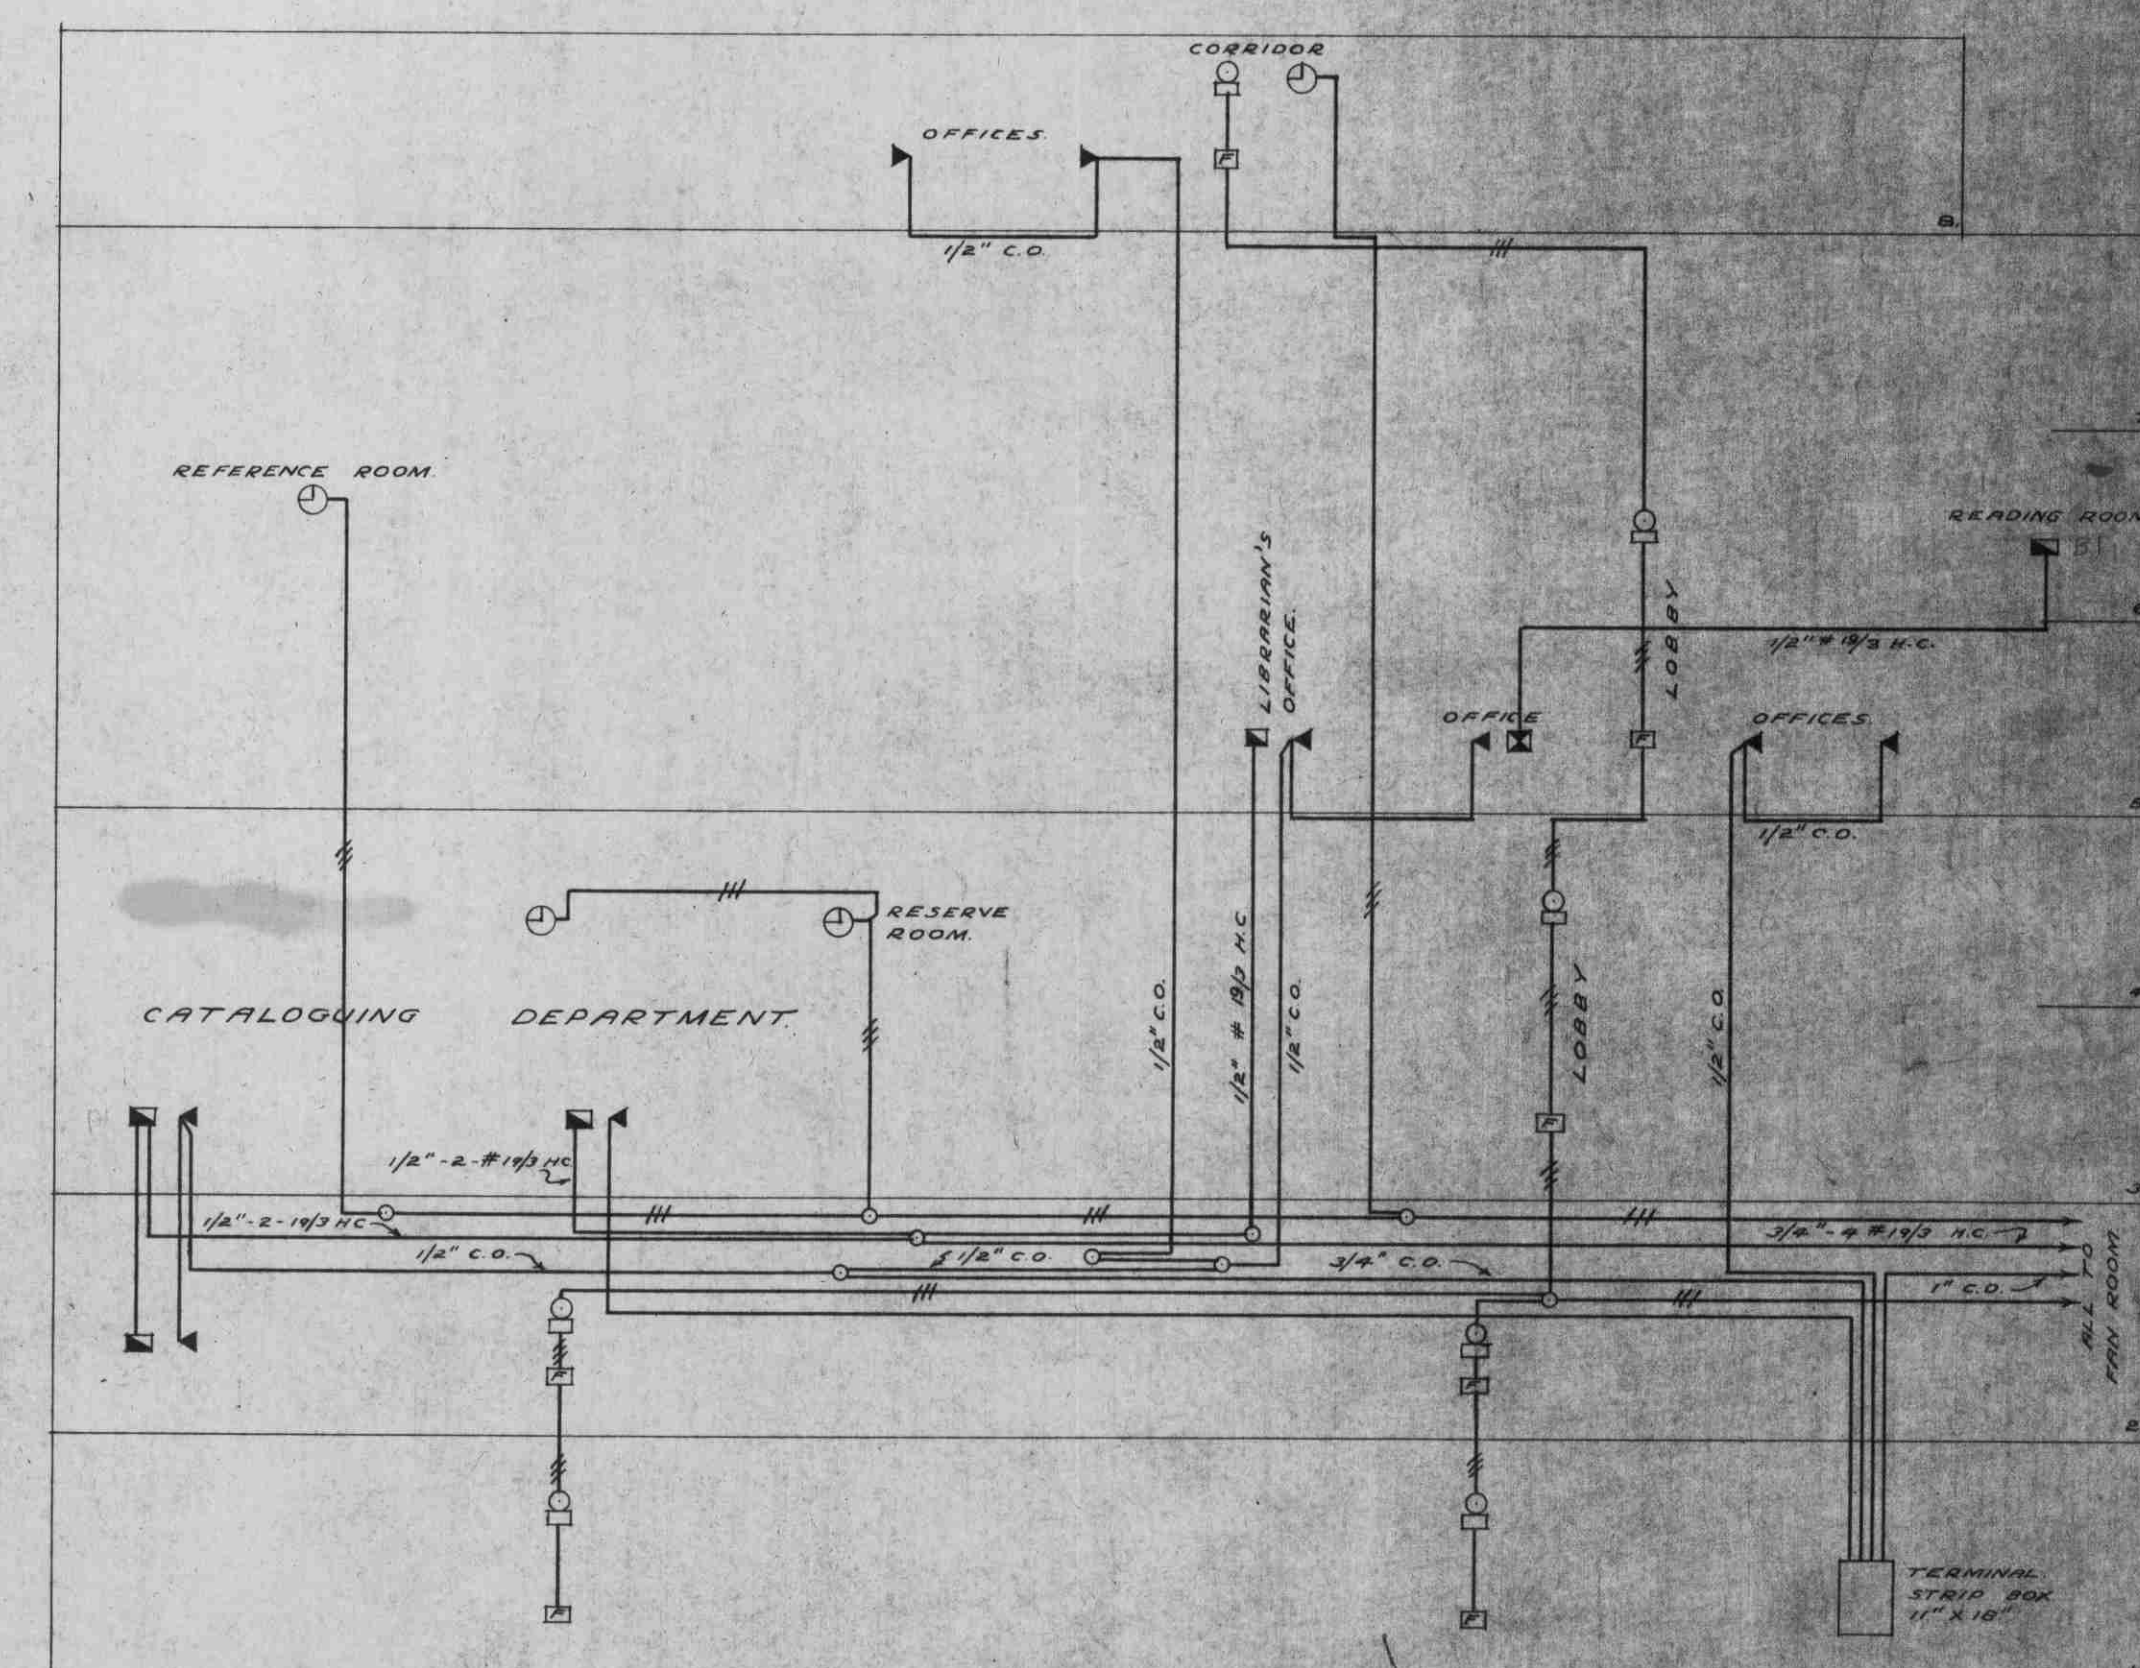

LOW TENSION RISER DIAGRAM
NOT TO SCALE

REVISION DATE		ADDITION TO LIBRARY		SCALE
		UNIVERSITY OF B. C.		AS NOTED
		A. EDWARD SIMPSON ELECTRICAL ENGINEER VANCOUVER, B. C.		DATE 25 JULY, 1946
		SHARP & THOMPSON ARCHITECTS VANCOUVER, B. C.		DRAWING NO. U2-5-8