


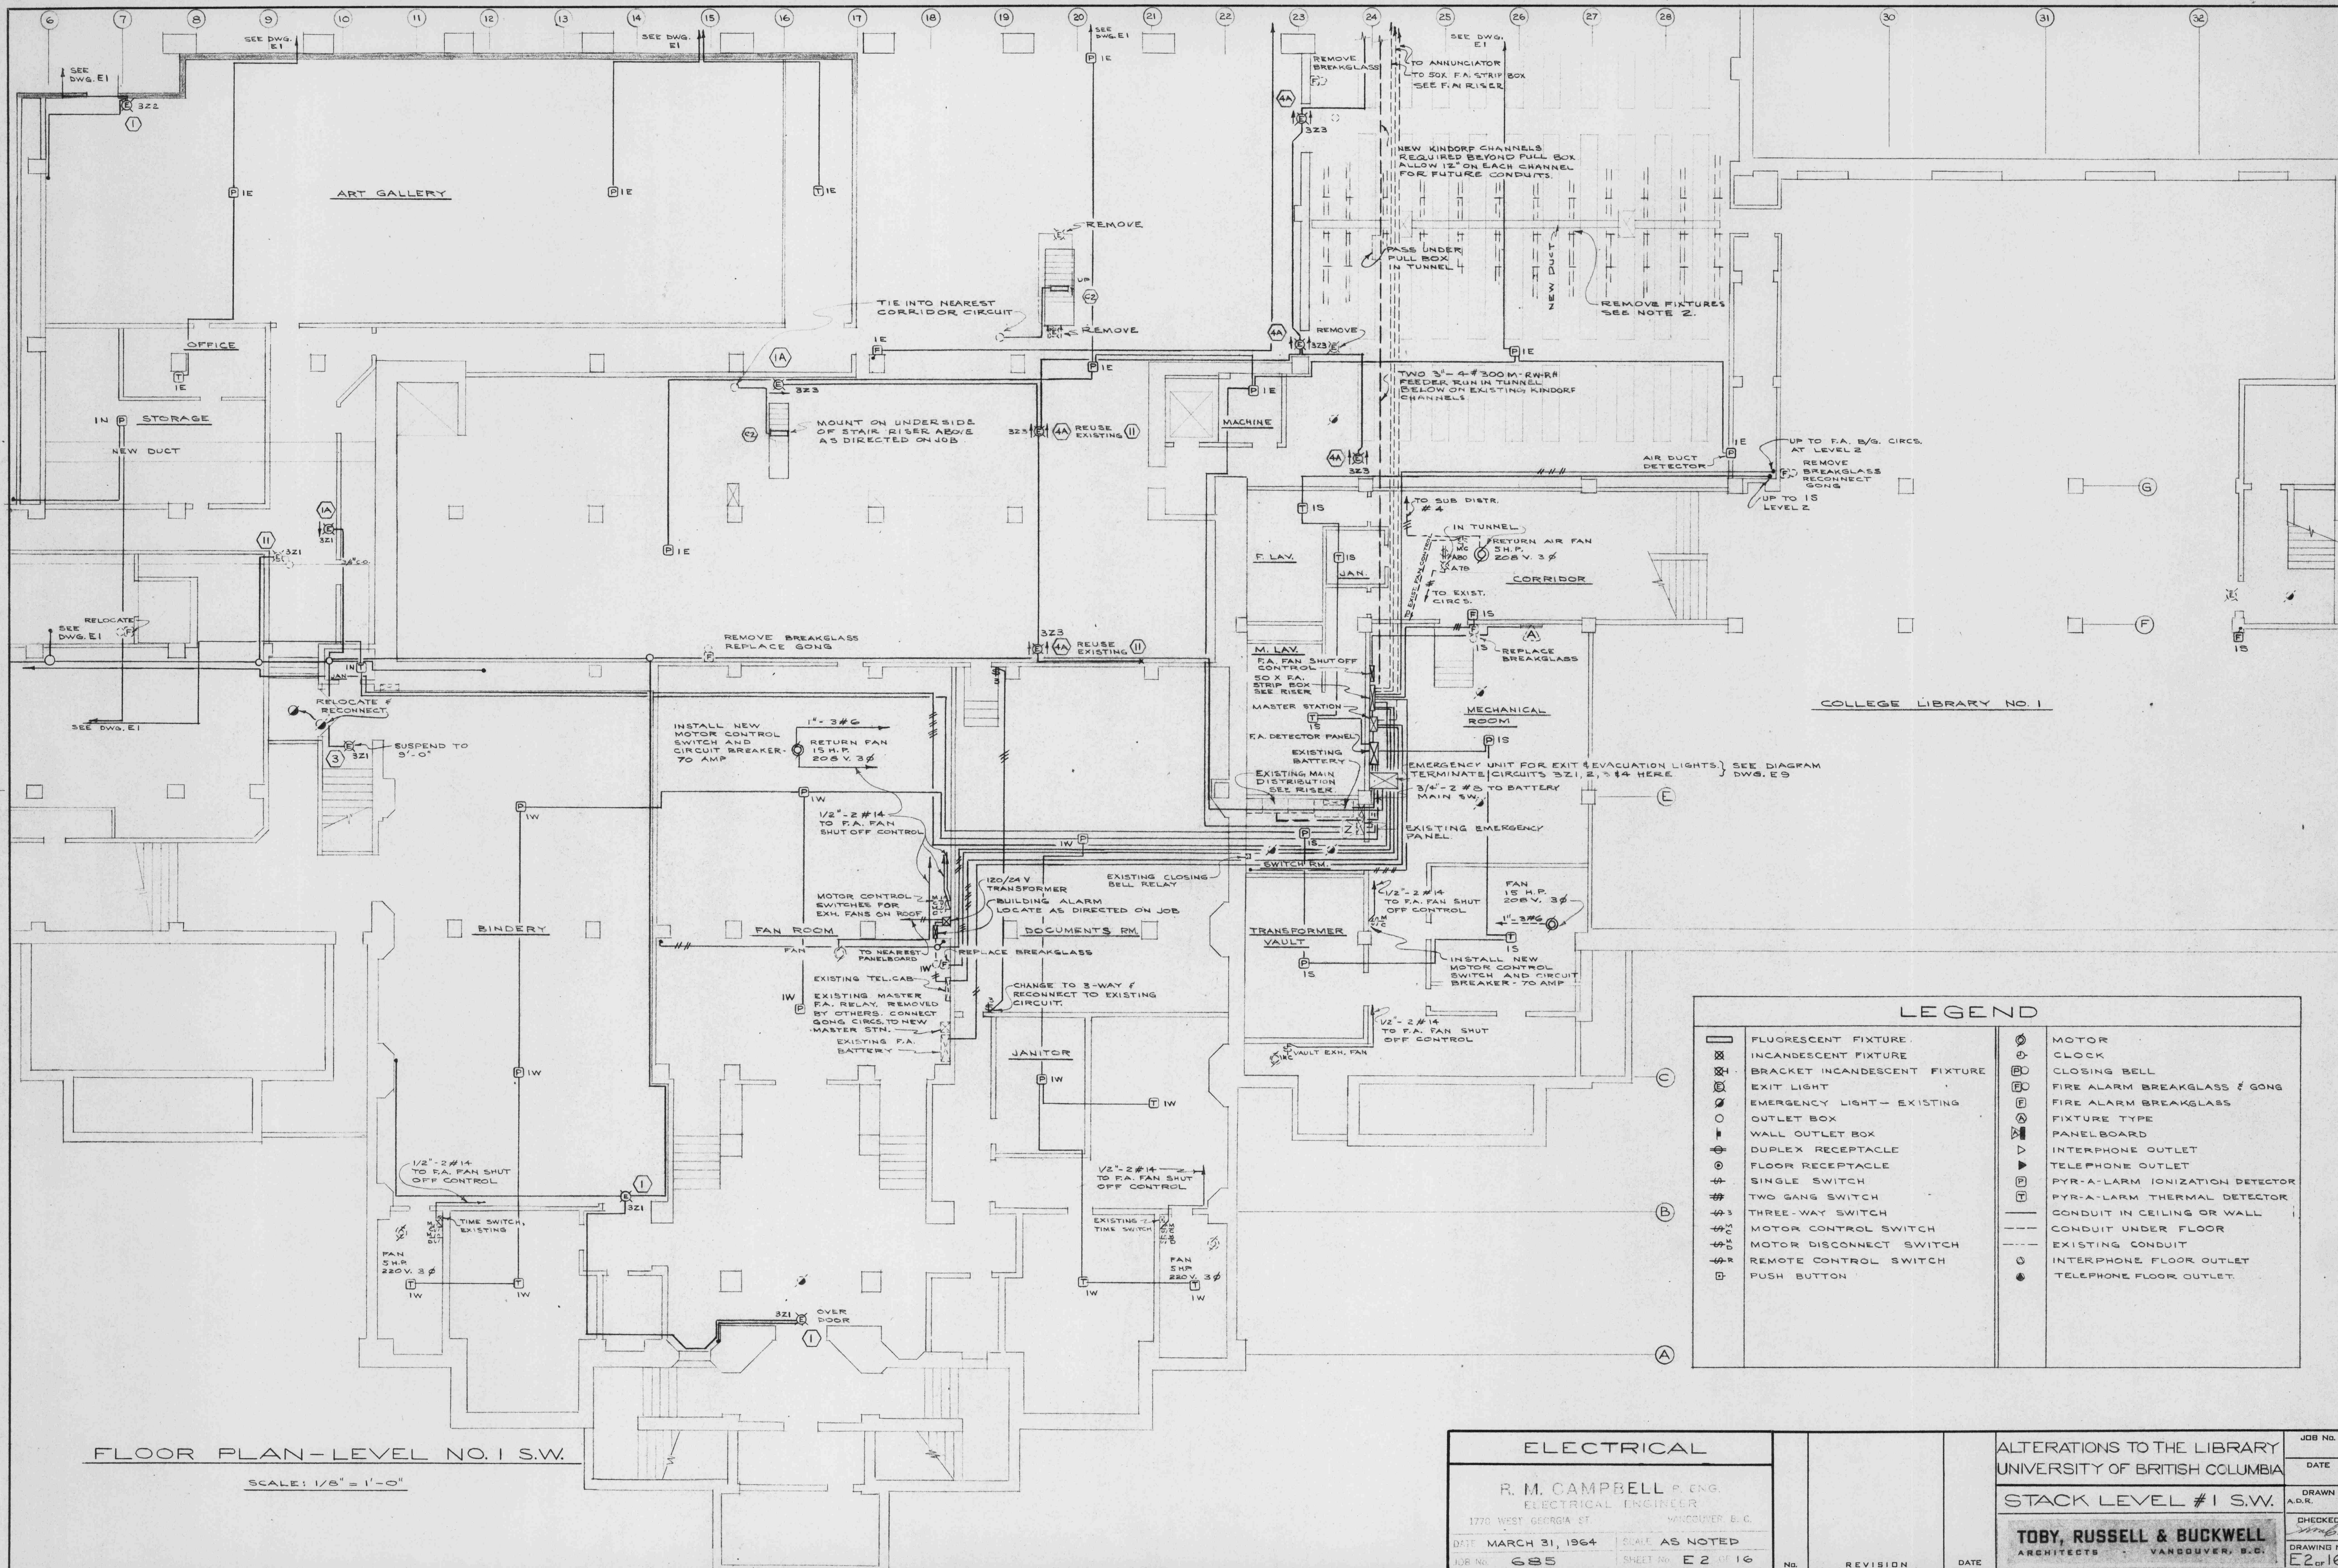

FLOOR PLAN-LEVEL NO. 1 S.W.
SCALE: 1/8" = 1'-0"

LEGEND	
	FLUORESCENT FIXTURE
	INCANDESCENT FIXTURE
	BRACKET INCANDESCENT FIXTURE
	EXIT LIGHT
	EMERGENCY LIGHT - EXISTING
	OUTLET BOX
	WALL OUTLET BOX
	DUPLEX RECEPTACLE
	FLOOR RECEPTACLE
	SINGLE SWITCH
	TWO GANG SWITCH
	THREE-WAY SWITCH
	MOTOR CONTROL SWITCH
	MOTOR DISCONNECT SWITCH
	REMOTE CONTROL SWITCH
	PUSH BUTTON
	MOTOR
	CLOCK
	CLOSING BELL
	FIRE ALARM BREAKGLASS & GONG
	FIRE ALARM BREAKGLASS
	FIXTURE TYPE
	PANELBOARD
	INTERPHONE OUTLET
	TELEPHONE OUTLET
	PYR-A-LARM IONIZATION DETECTOR
	PYR-A-LARM THERMAL DETECTOR
	CONDUIT IN CEILING OR WALL
	CONDUIT UNDER FLOOR
	EXISTING CONDUIT
	INTERPHONE FLOOR OUTLET
	TELEPHONE FLOOR OUTLET

ELECTRICAL		ALTERATIONS TO THE LIBRARY		JOB NO.
R. M. CAMPBELL P. ENG.		UNIVERSITY OF BRITISH COLUMBIA		DATE
ELECTRICAL ENGINEER		STACK LEVEL #1 S.W.		DRAWN A.D.R.
1770 WEST GEORGIA ST. VANCOUVER B.C.		TOBY, RUSSELL & BUCKWELL		CHECKED
DATE MARCH 31, 1964	SCALE AS NOTED	ARCHITECTS VANCOUVER, B.C.		DRAWING NO. E2 OF 16
JOB NO. 685	SHEET NO. E 2 OF 16	NO.	REVISION	DATE