

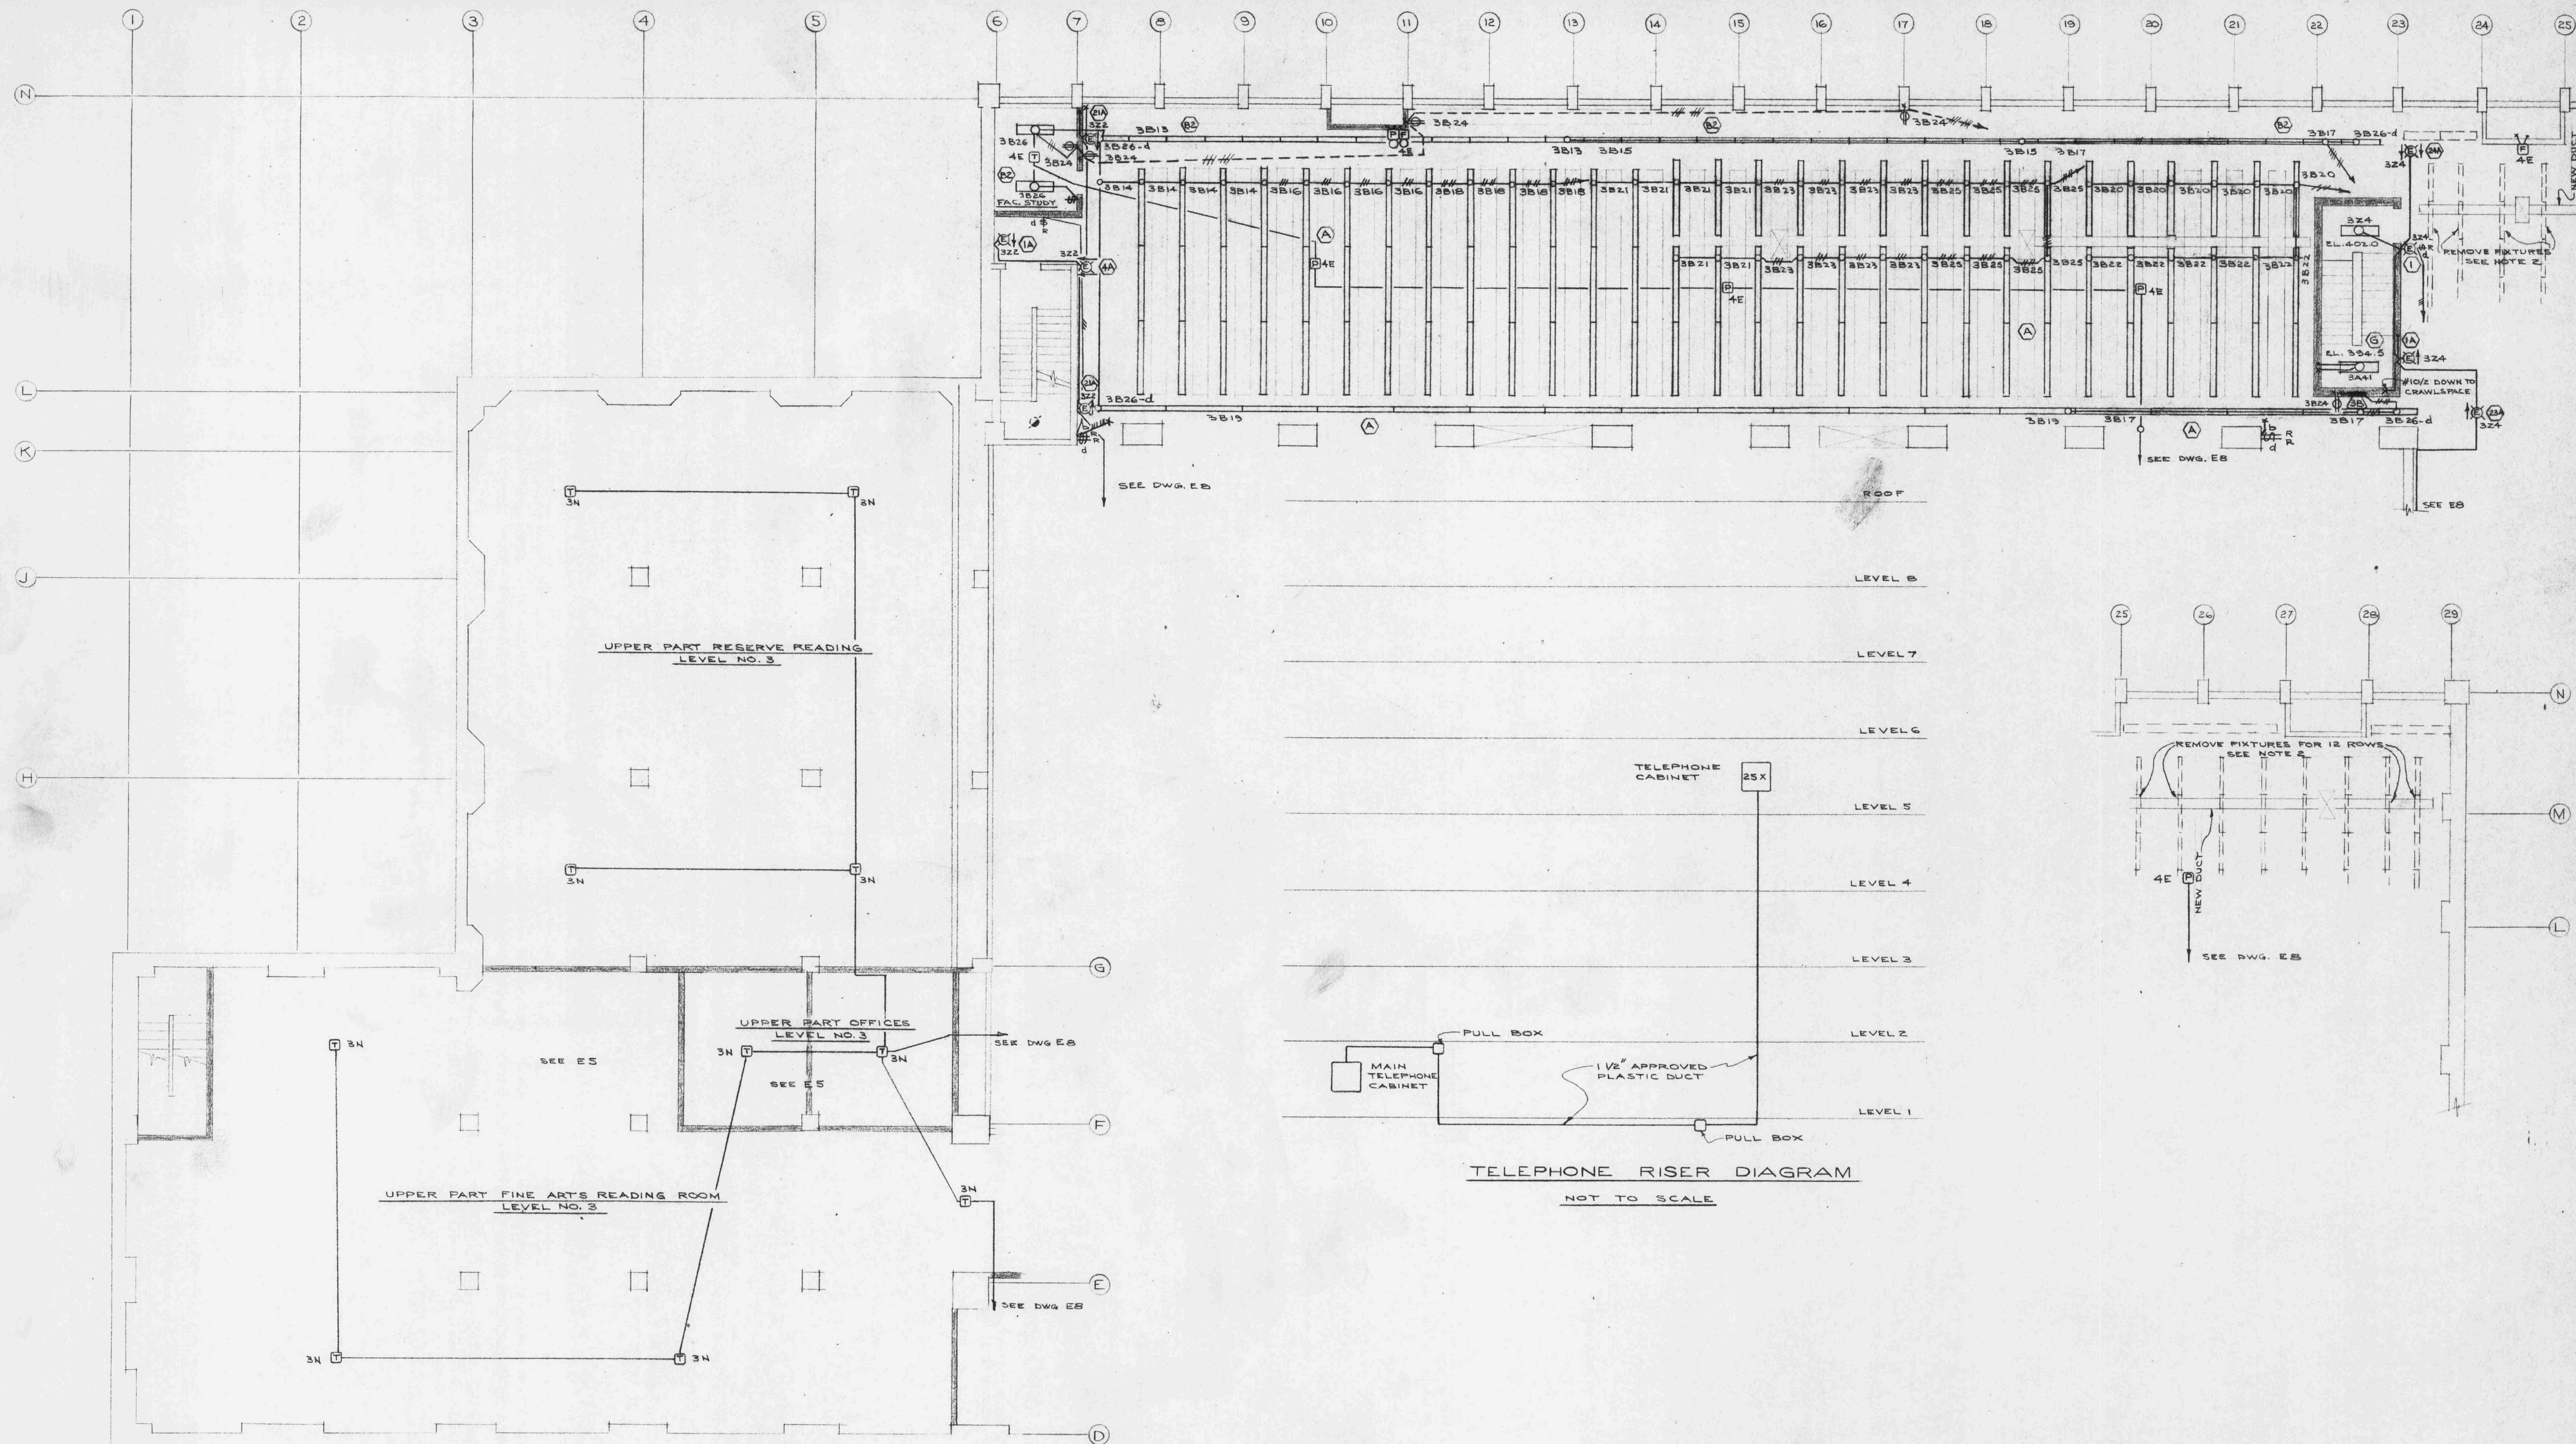


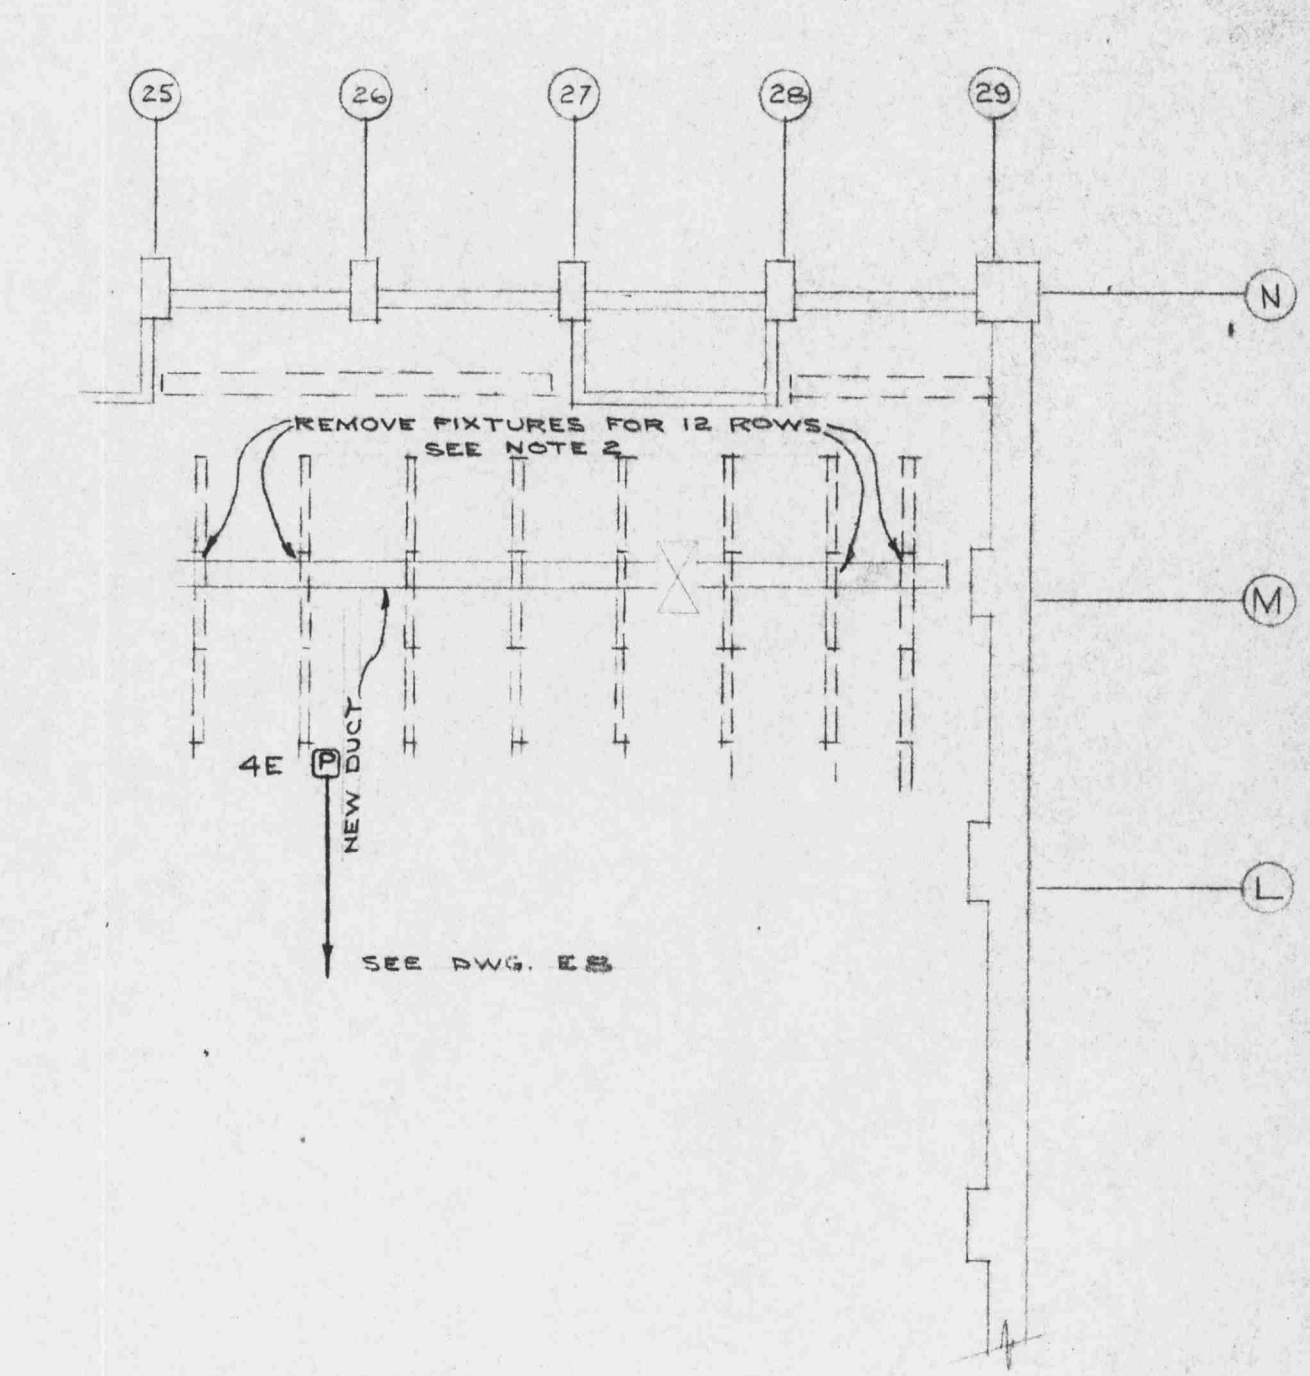

FLOOR PLAN-LEVEL NO. 4 N.E.
SCALE: 1/8" = 1'-0"

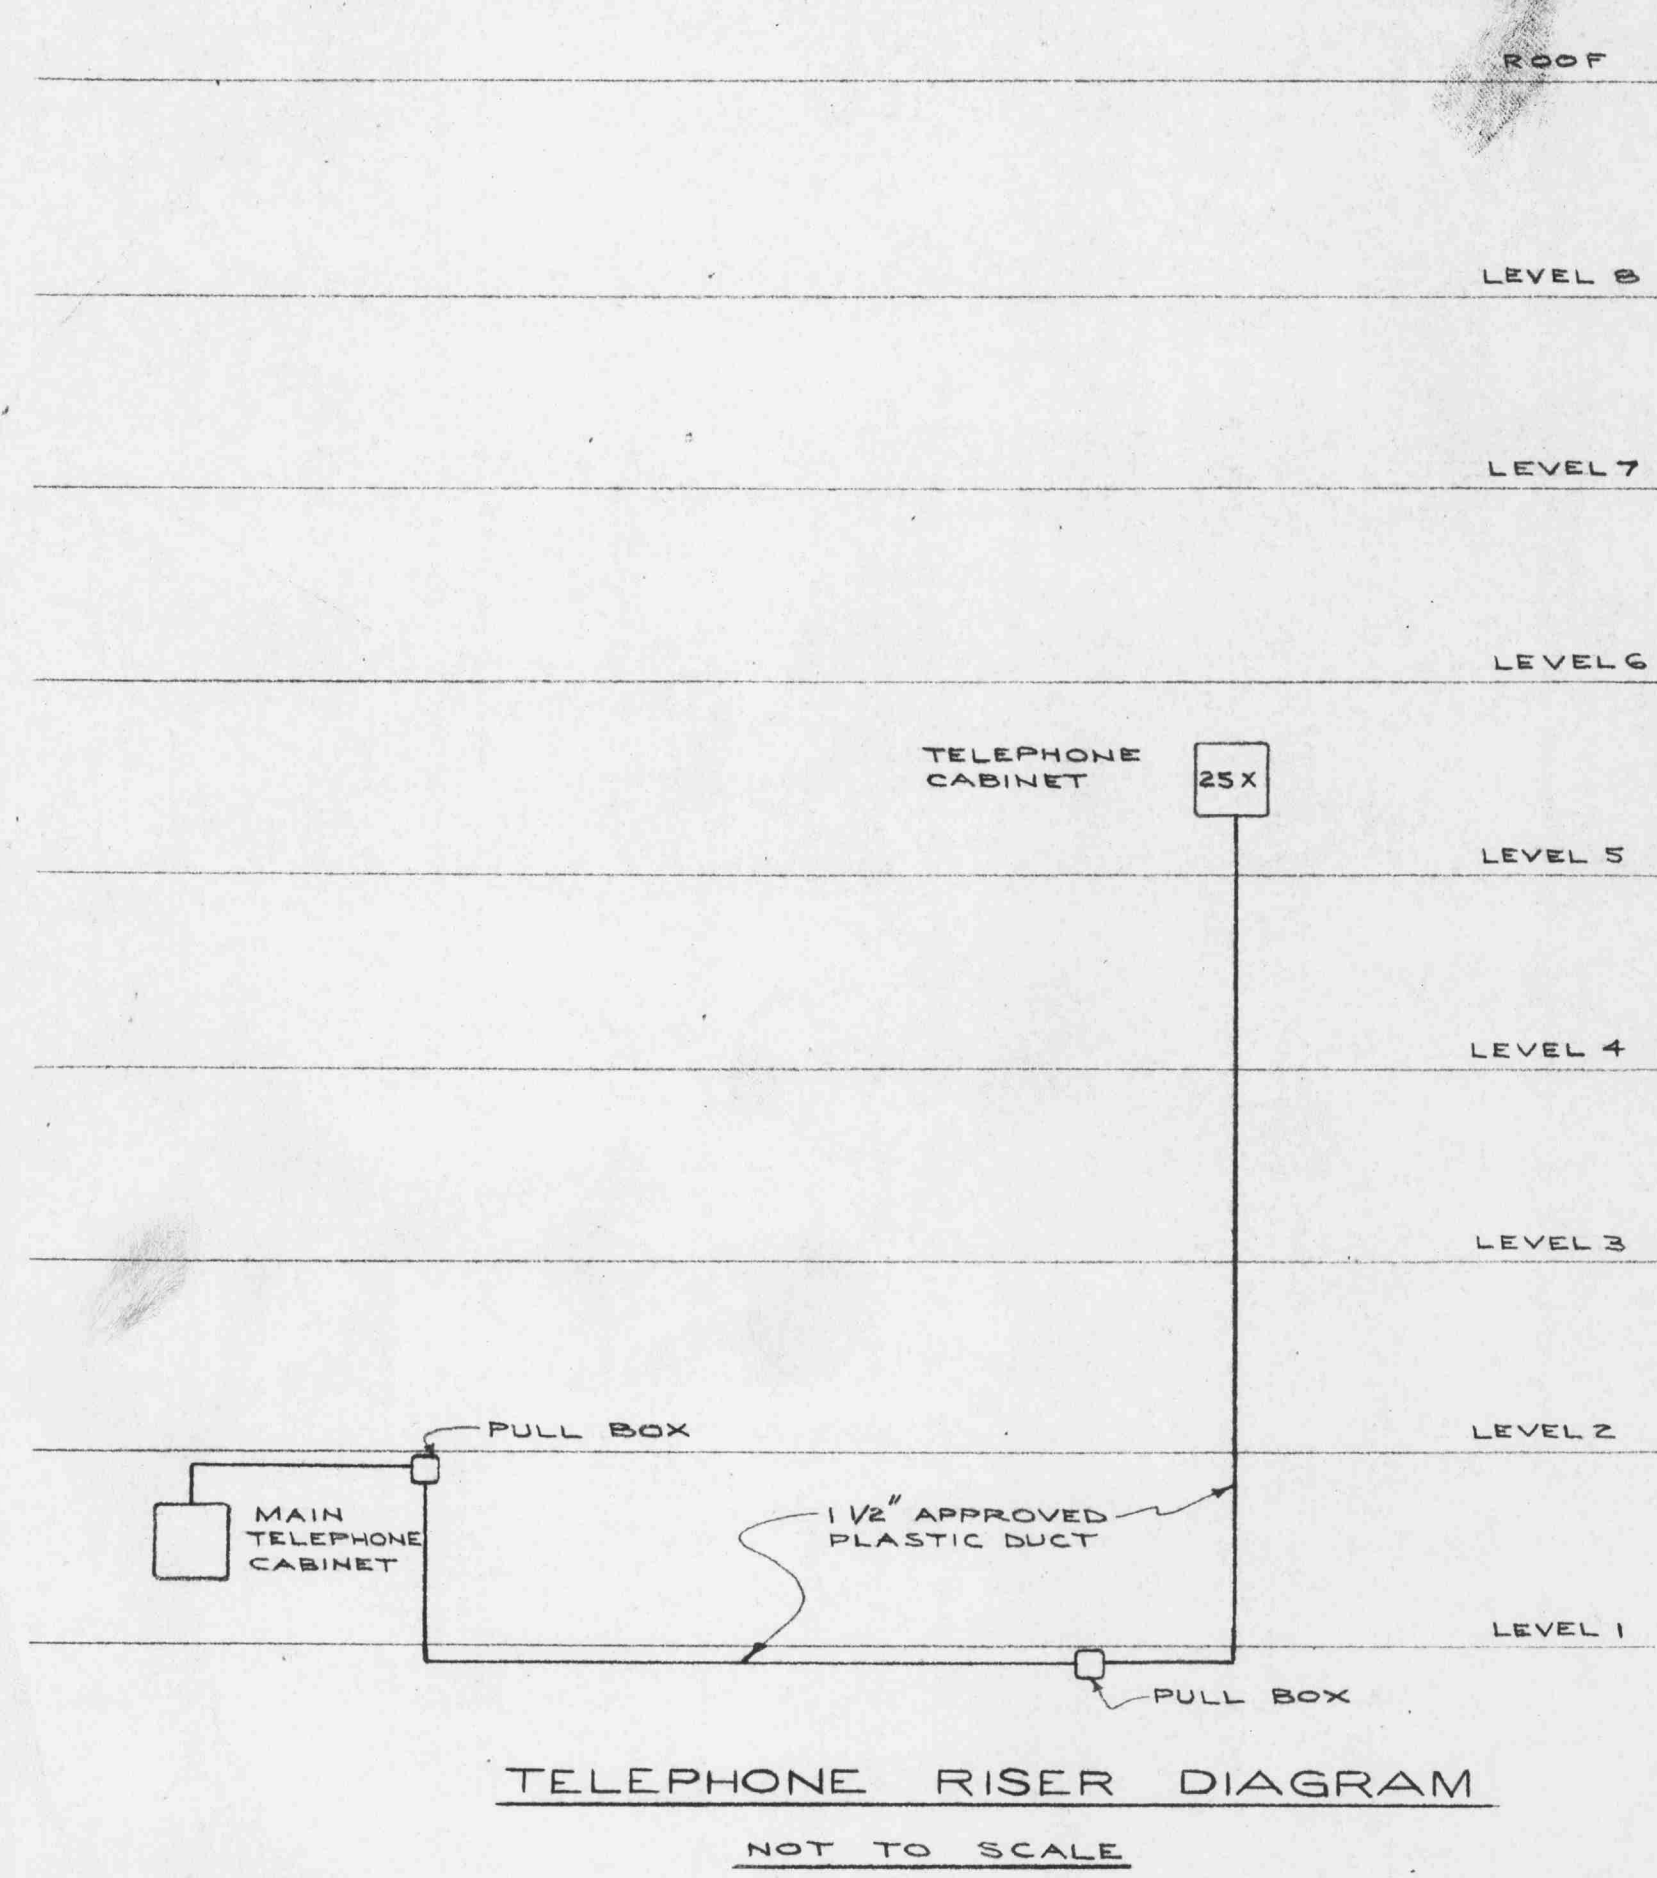

ELECTRICAL		ALTERATIONS TO THE LIBRARY UNIVERSITY OF BRITISH COLUMBIA		JOB No.
R. M. CAMPBELL P. ENG. ELECTRICAL ENGINEER 1770 WEST GEORGIA ST. VANCOUVER, B. C.		STACK LEVEL # 4 N.E.		DATE
DATE MARCH 31, 1964	SCALE AS NOTED	TOBY, RUSSELL & BUCKWELL ARCHITECTS - VANCOUVER, B.C.		DRAWN A.D.R.
JOB No. 685	SHEET No. E7 OF 16	No.	REVISION	CHECKED Amg
		DATE		DRAWING No. E7 OF 16