


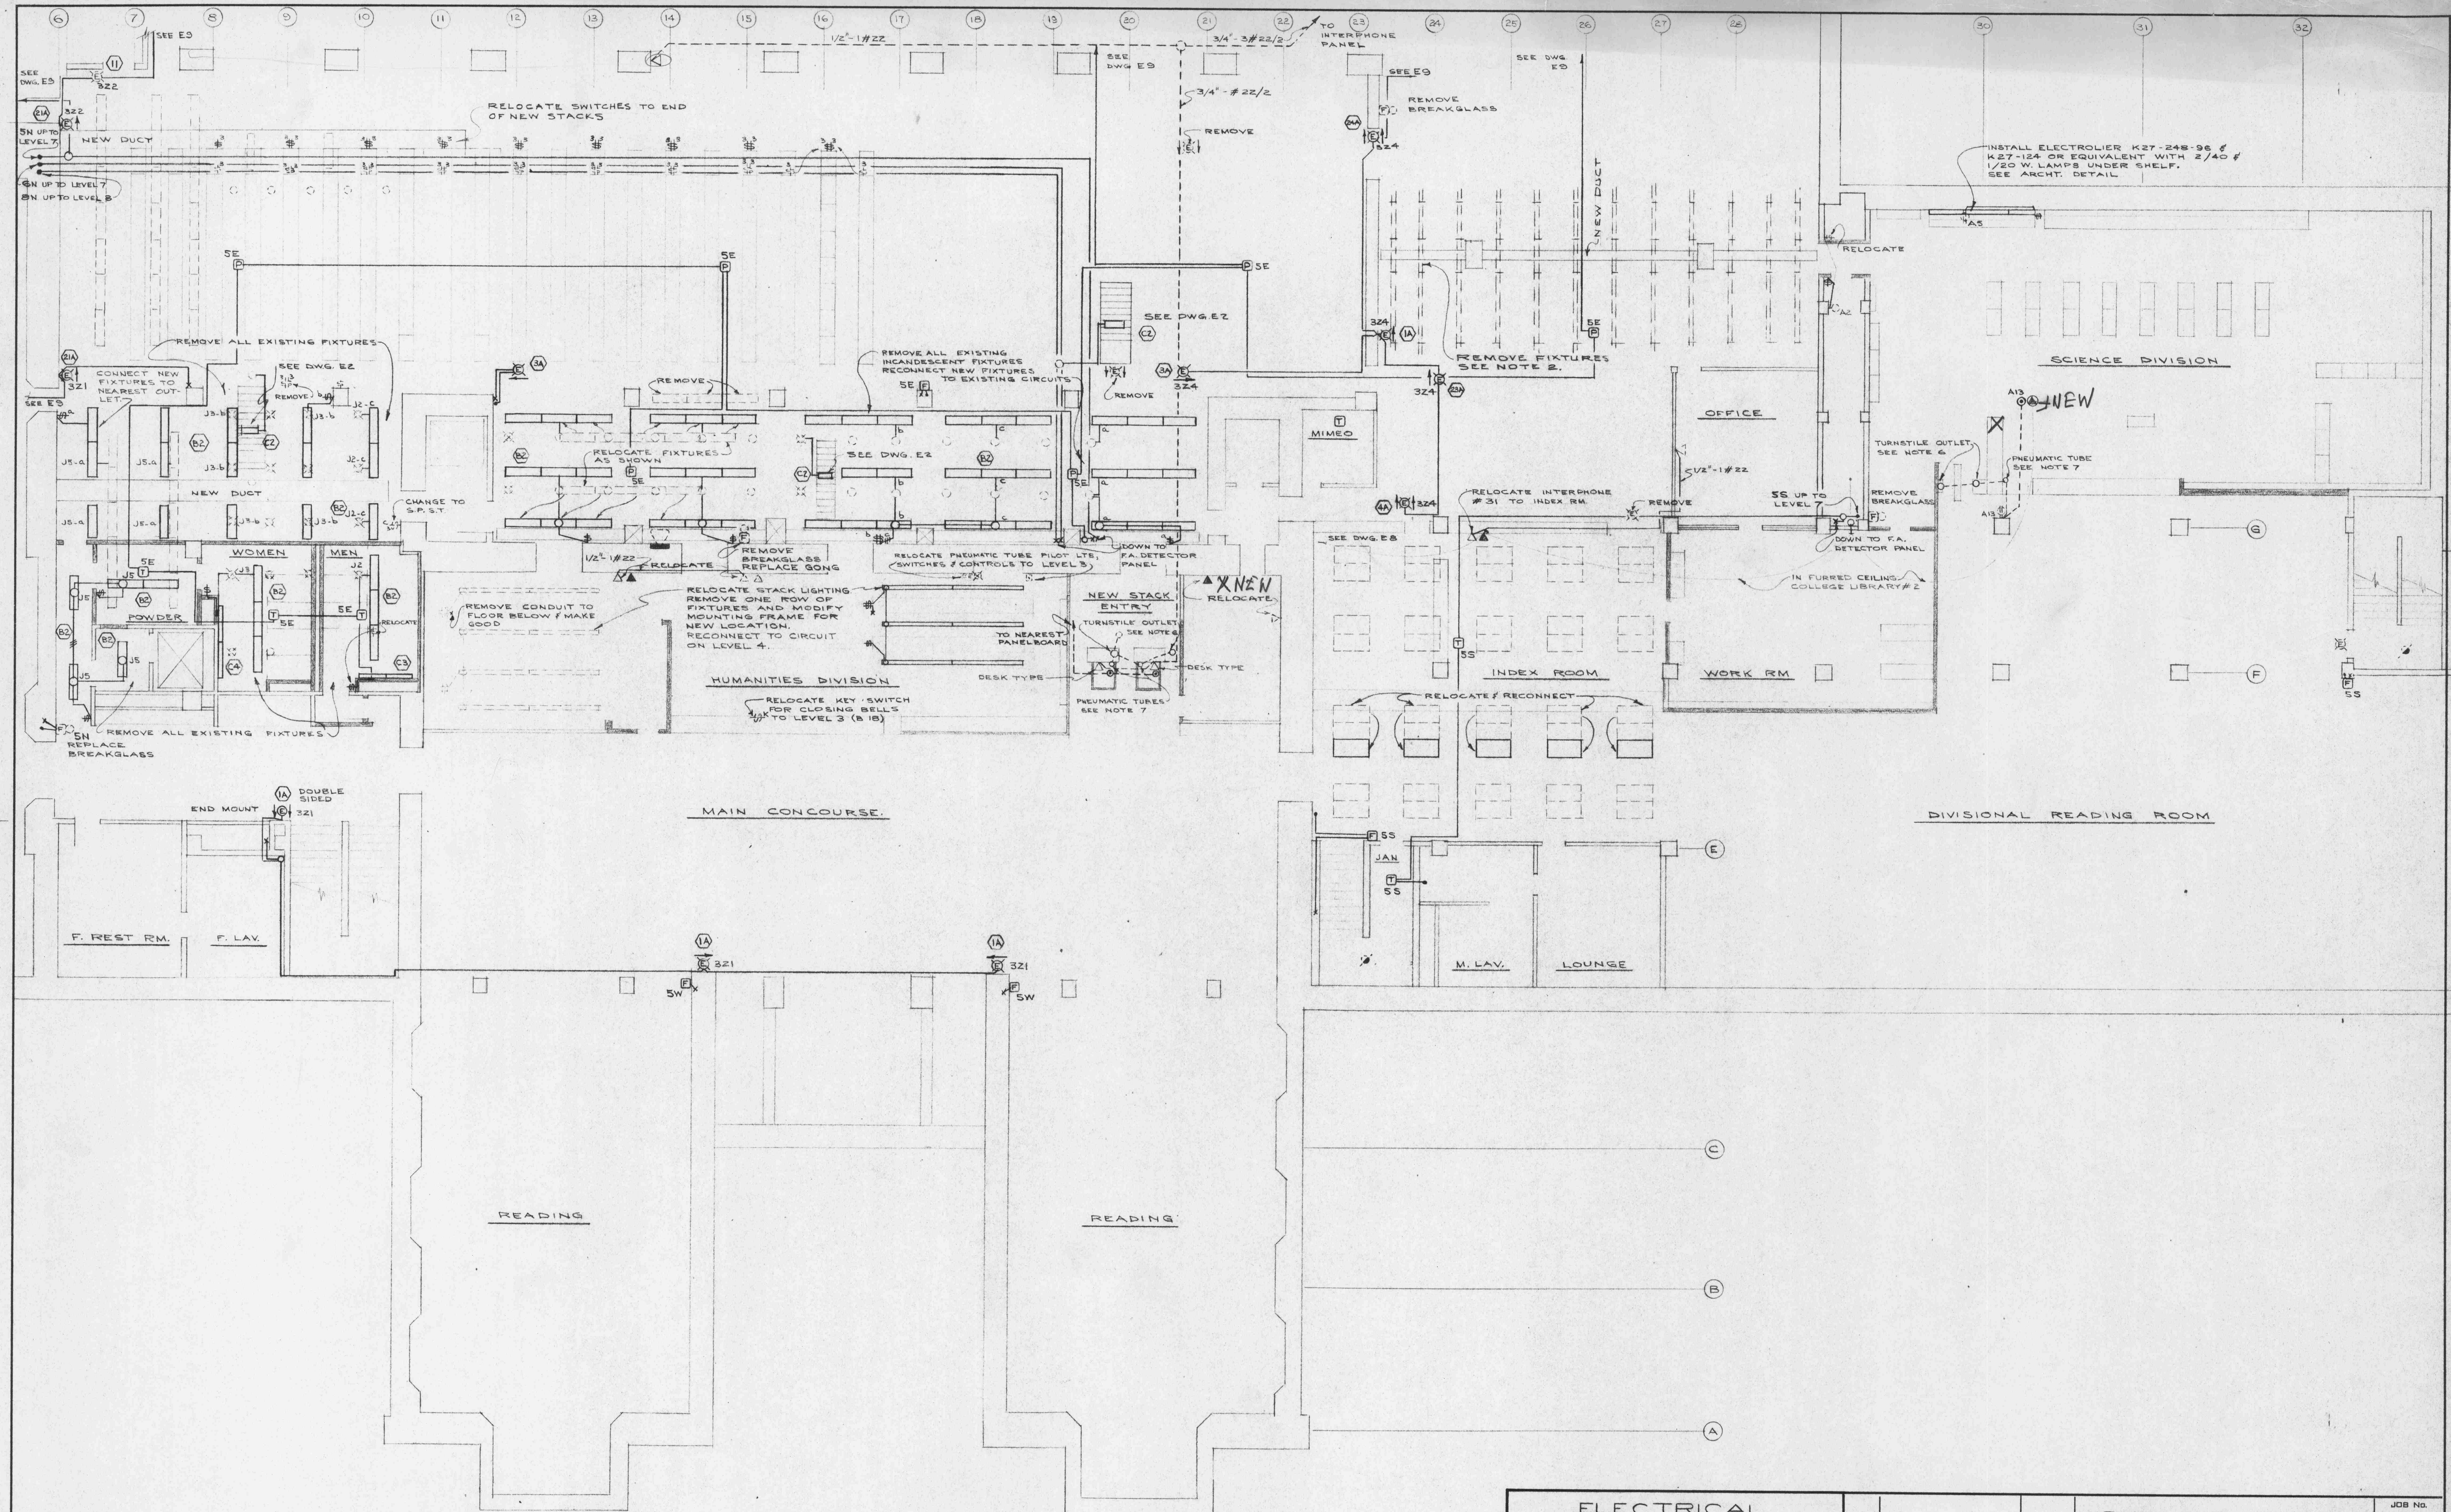

FLOOR PLAN - LEVEL NO. 5 S.W.

SCALE: 1/8" = 1'-0"

ELECTRICAL		ALTERATIONS TO THE LIBRARY		JOB No.
R. M. CAMPBELL P. ENG.		UNIVERSITY OF BRITISH COLUMBIA		DATE
1770 WEST GEORGIA ST. VANCOUVER, B. C.		STACK LEVEL #5 S.W.		DRAWN
DATE MARCH 31, 1964		TOBY, RUSSELL & BUCKWELL		CHECKED
JOB No. 685		ARCHITECTS - VANCOUVER, B. C.		DRAWING No.
SCALE AS NOTED		REVISION		E10 of 16
SHEET No. E10 OF 16		DATE		