


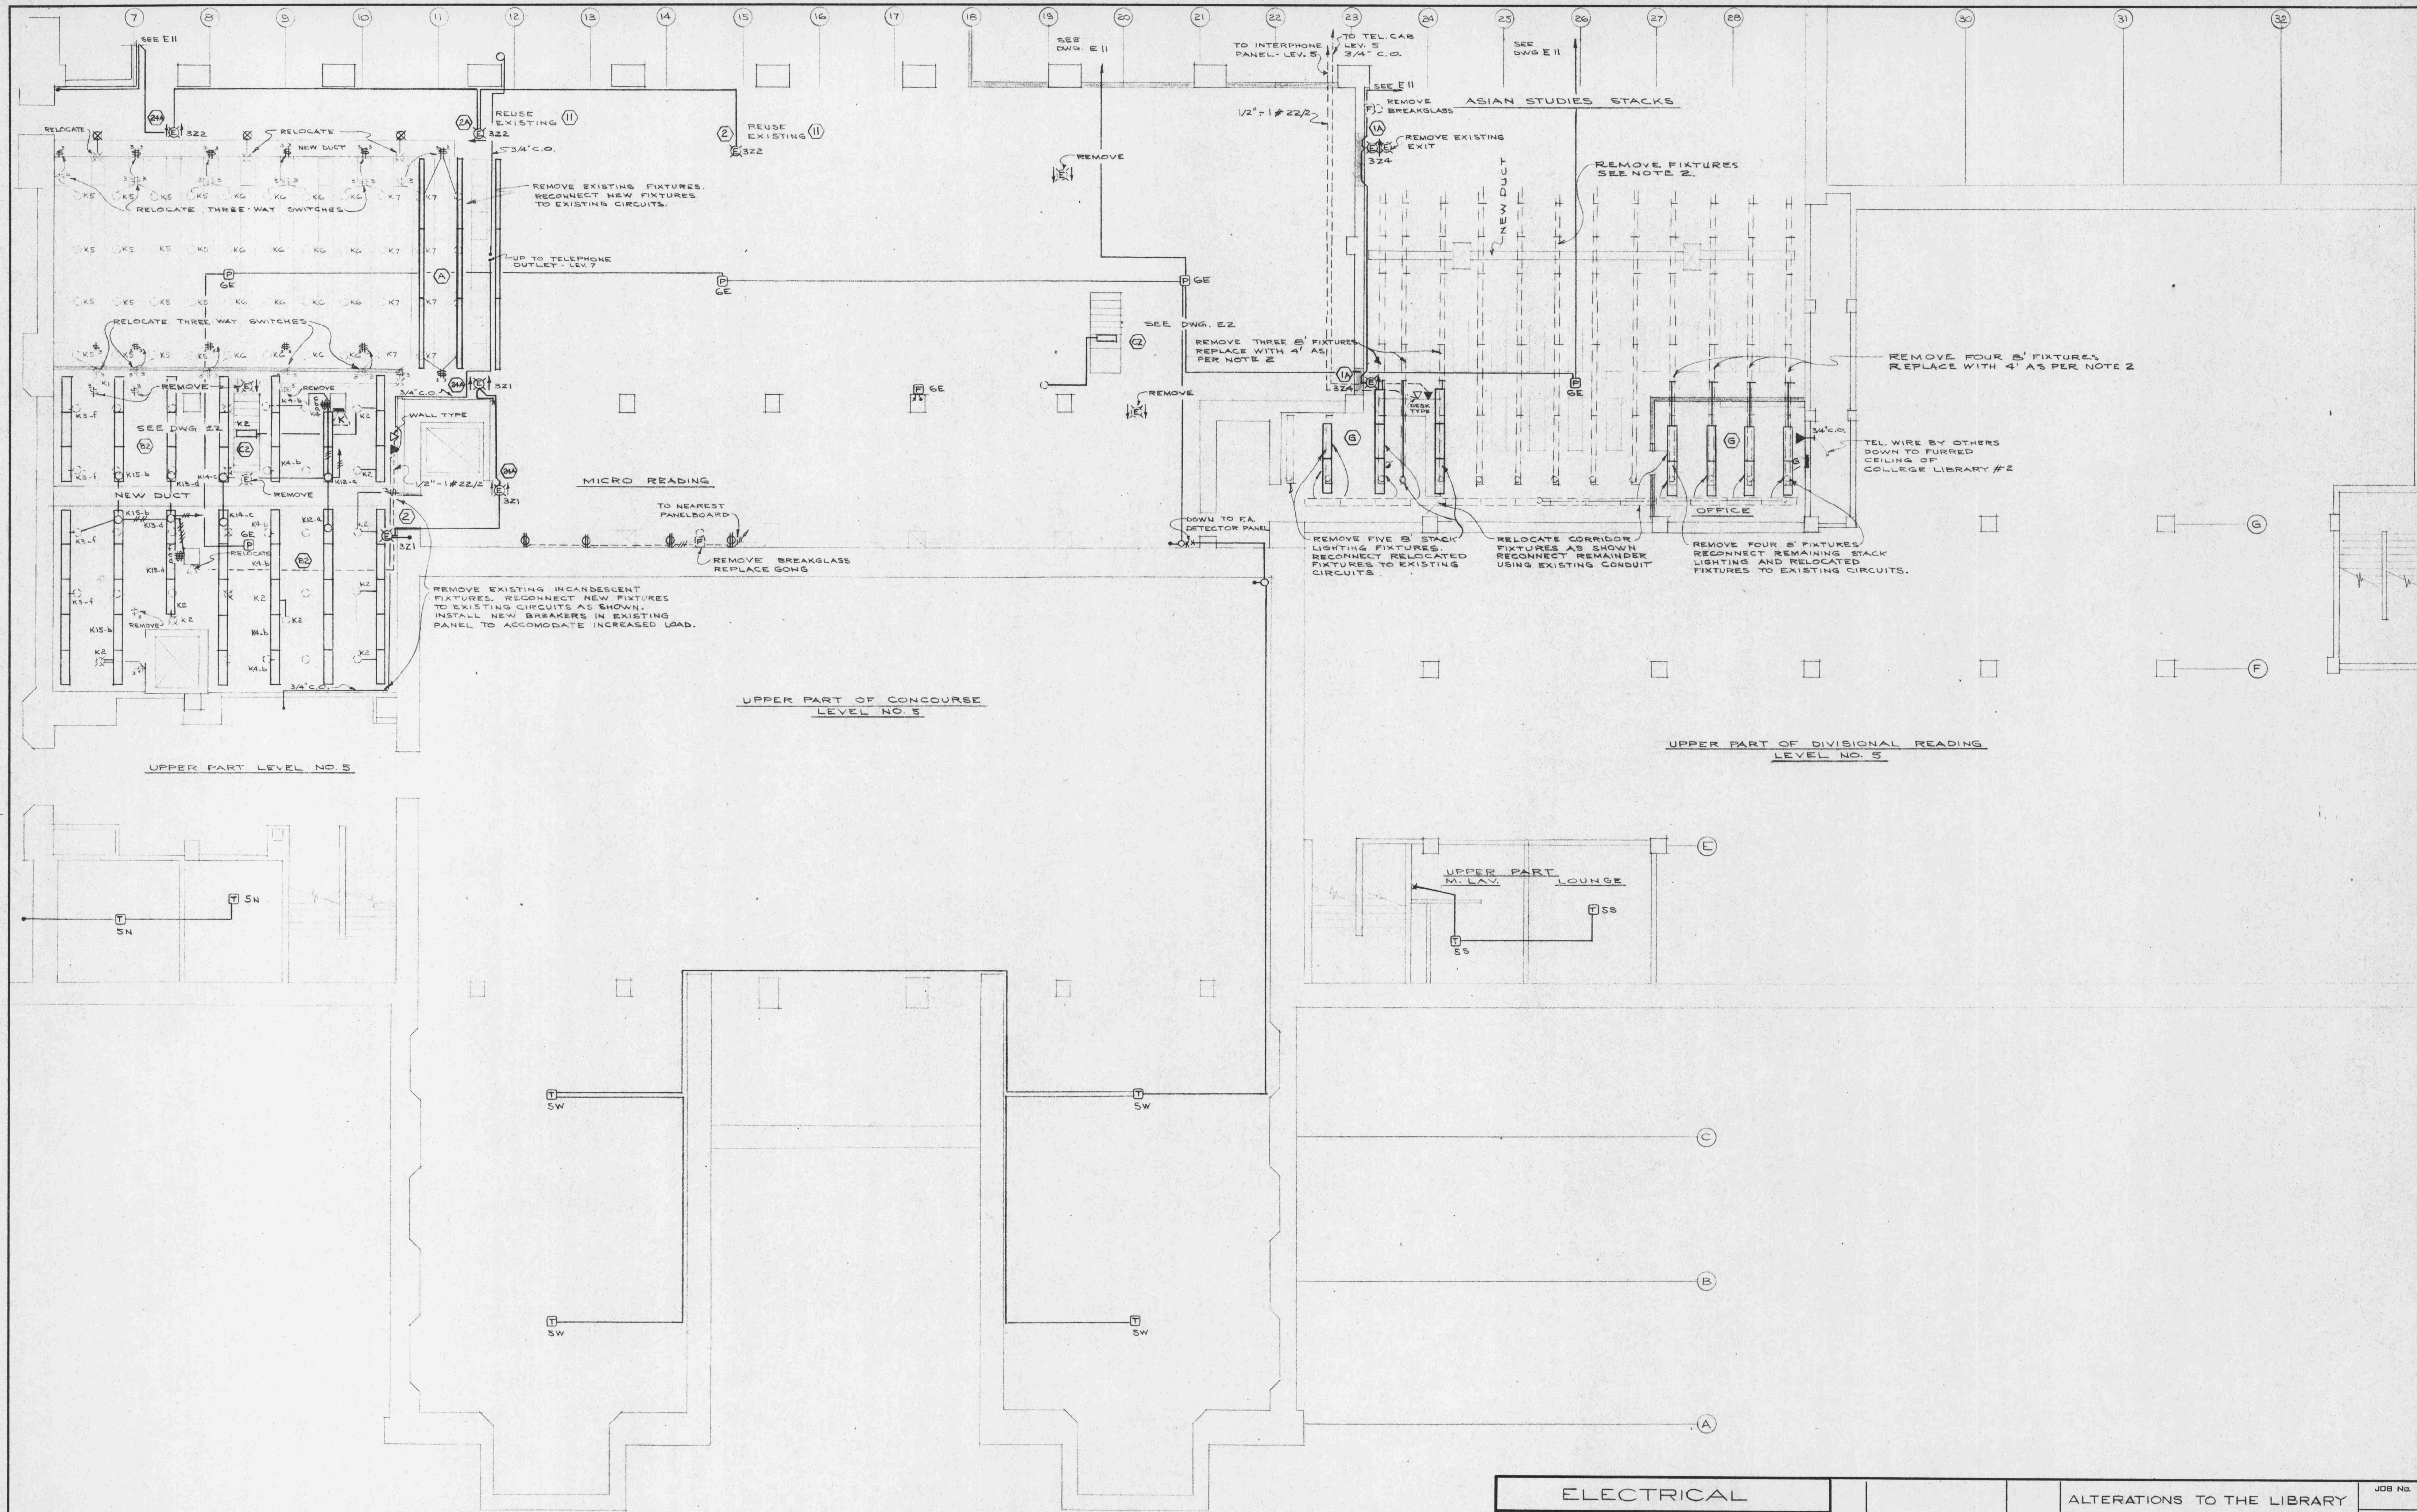

FLOOR PLAN-LEVEL NO.6 S.W.

SCALE: 1/8" = 1'-0"

ELECTRICAL		ALTERATIONS TO THE LIBRARY		JOB No.
R. M. CAMPBELL P. ENG.		UNIVERSITY OF BRITISH COLUMBIA		DATE
1770 WEST GEORGIA ST. VANCOUVER, B. C.		STACK LEVEL #6 S.W.		DRAWN A.D.R.
DATE MARCH 31, 1964		TOBY, RUSSELL & BUCKWELL		CHECKED <i>Am</i>
SHEET No. E 12 OF 16		ARCHITECTS, VANCOUVER, B. C.		DRAWING No. E 12 OF 16
No. 685		REVISION		DATE