


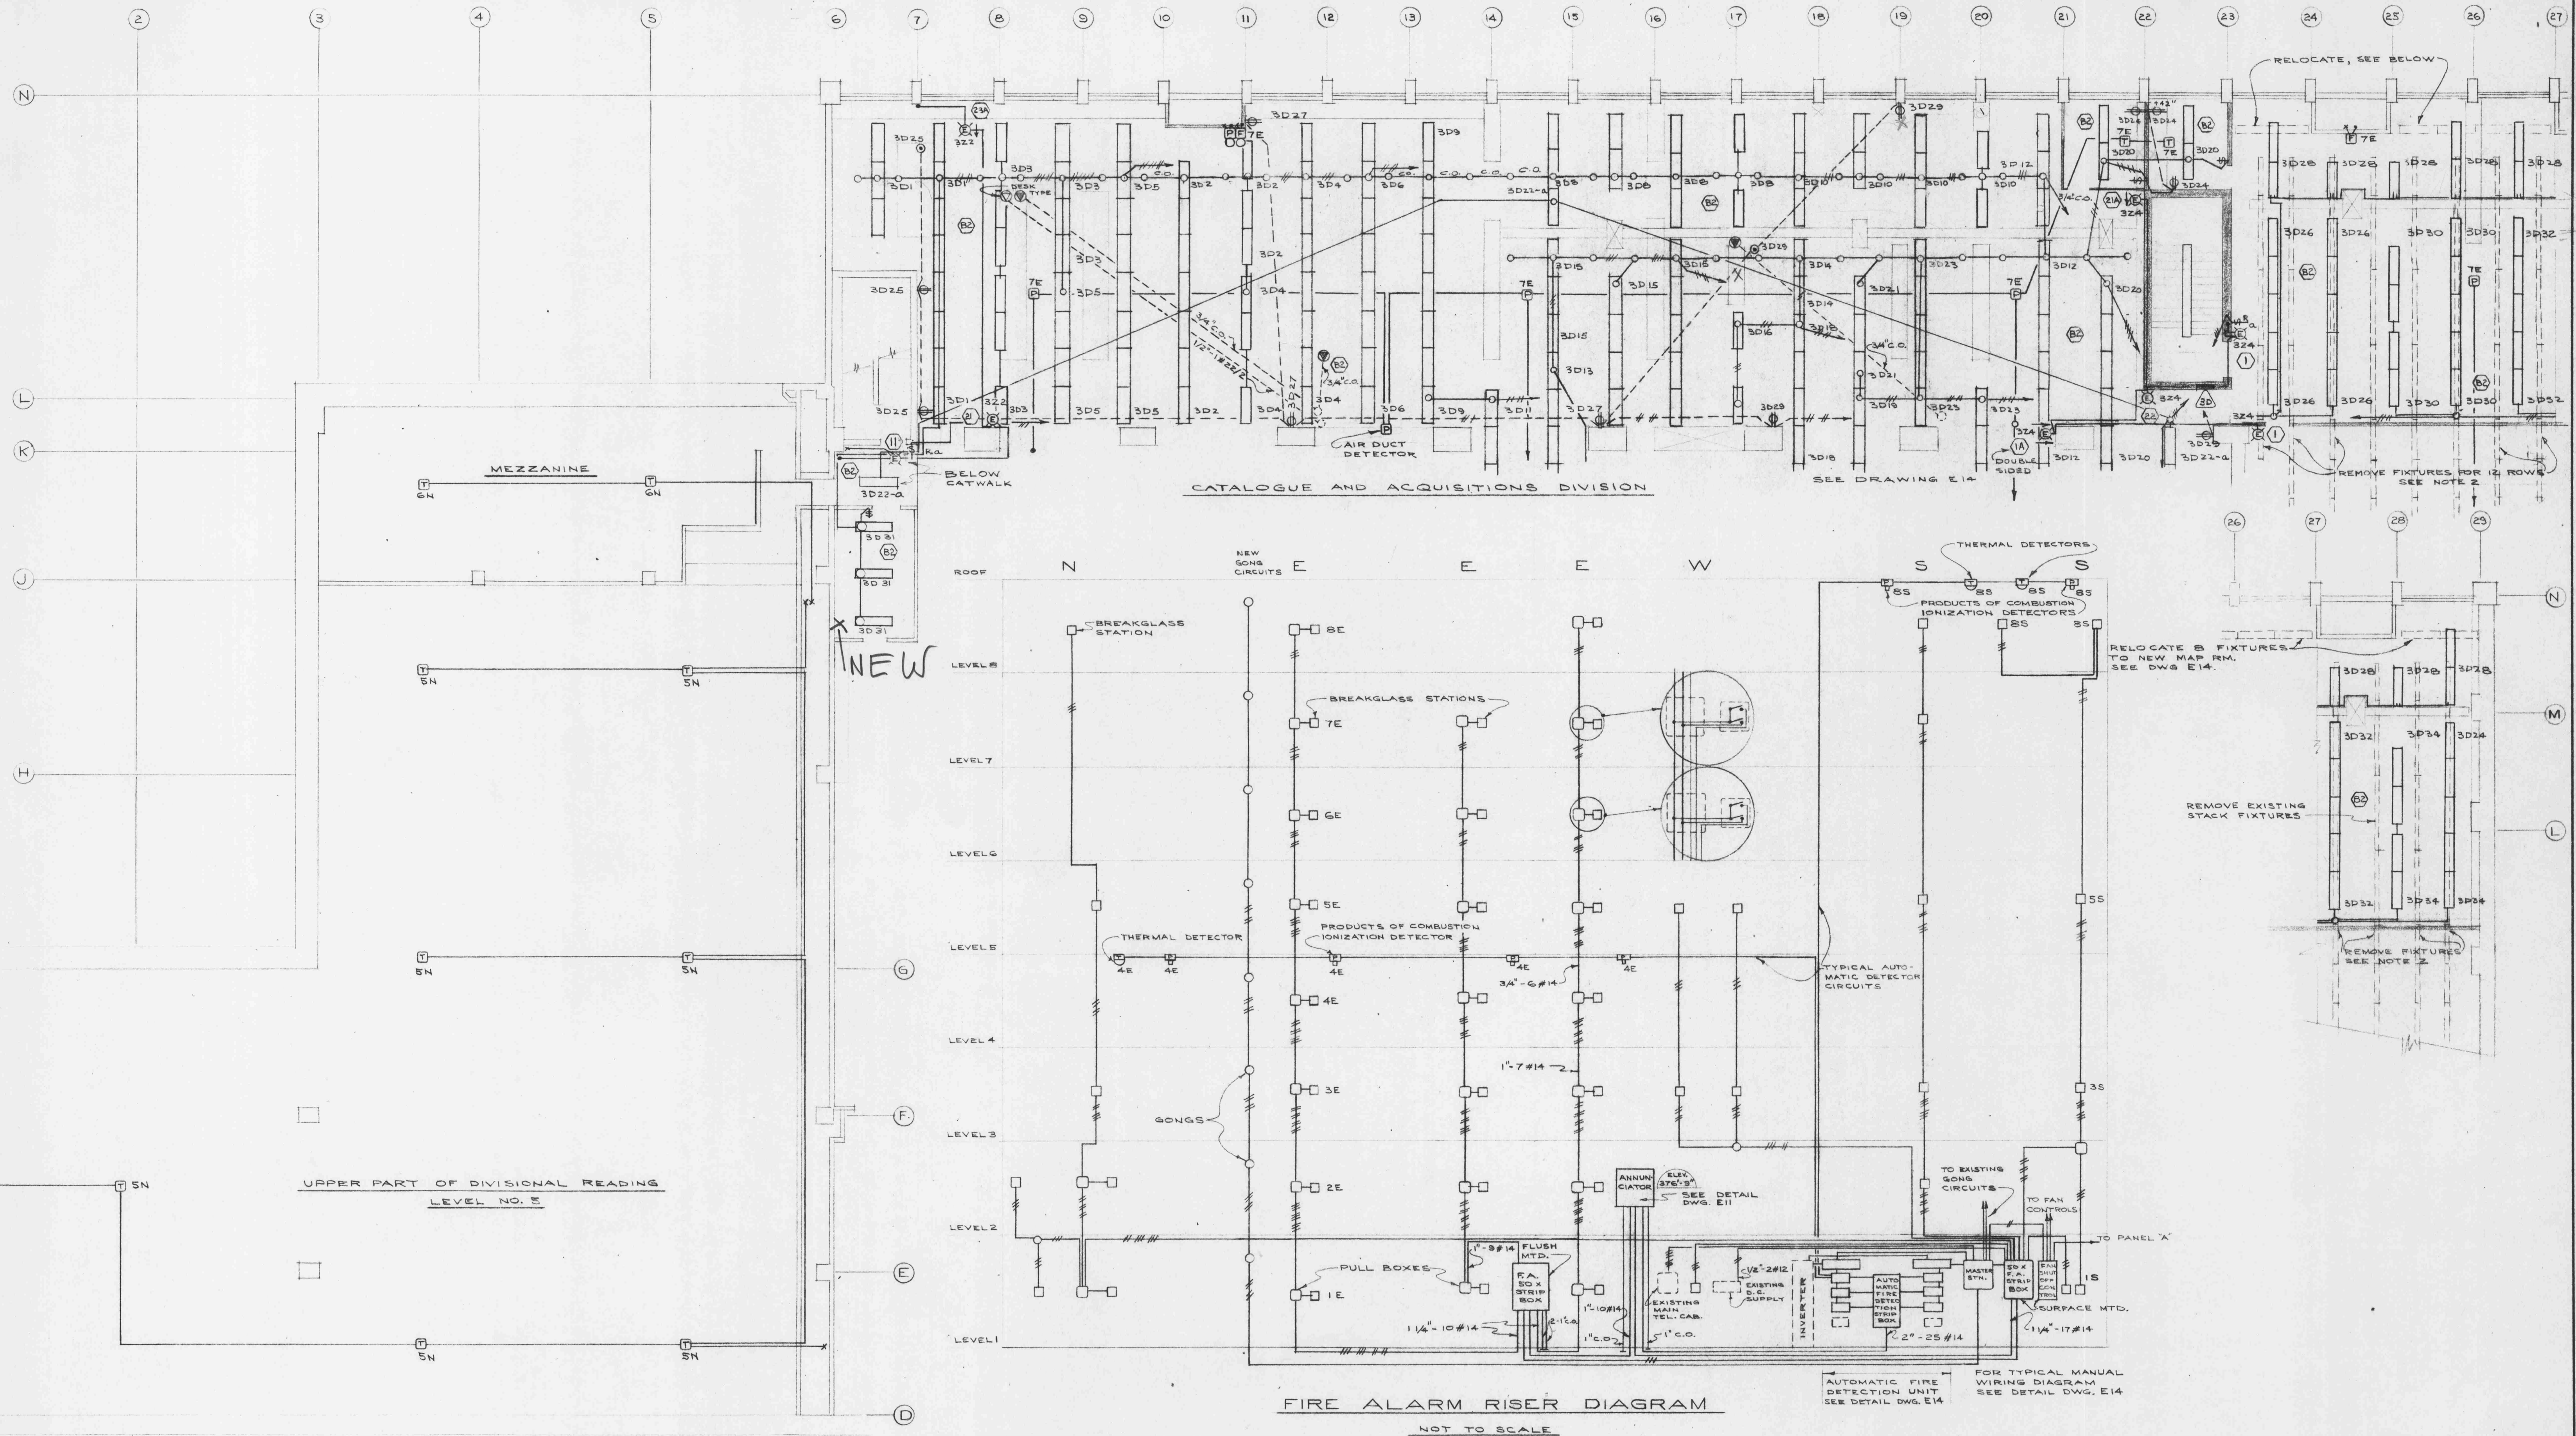

FLOOR PLAN — LEVEL NO. 7 N.E.

SCALE: 1/8" = 1'-0"

ELECTRICAL		ALTERATIONS TO THE LIBRARY		JOB No.
R. M. CAMPBELL P. ENG.		UNIVERSITY OF BRITISH COLUMBIA		DATE
ELECTRICAL ENGINEER		STACK LEVEL # 7 N.E.		DRAWN A.D.R.
1770 WEST GEORGIA ST. VANCOUVER, B. C.		TOBY, RUSSELL & BUCKWELL		CHECKED
DATE MARCH 31, 1964	SCALE AS NOTED	ARCHITECTS - VANCOUVER, B. C.		DRAWING No. E13 OF 16
JOB No. 685	SHEET No. E13 OF 16	No.	REVISION	DATE