


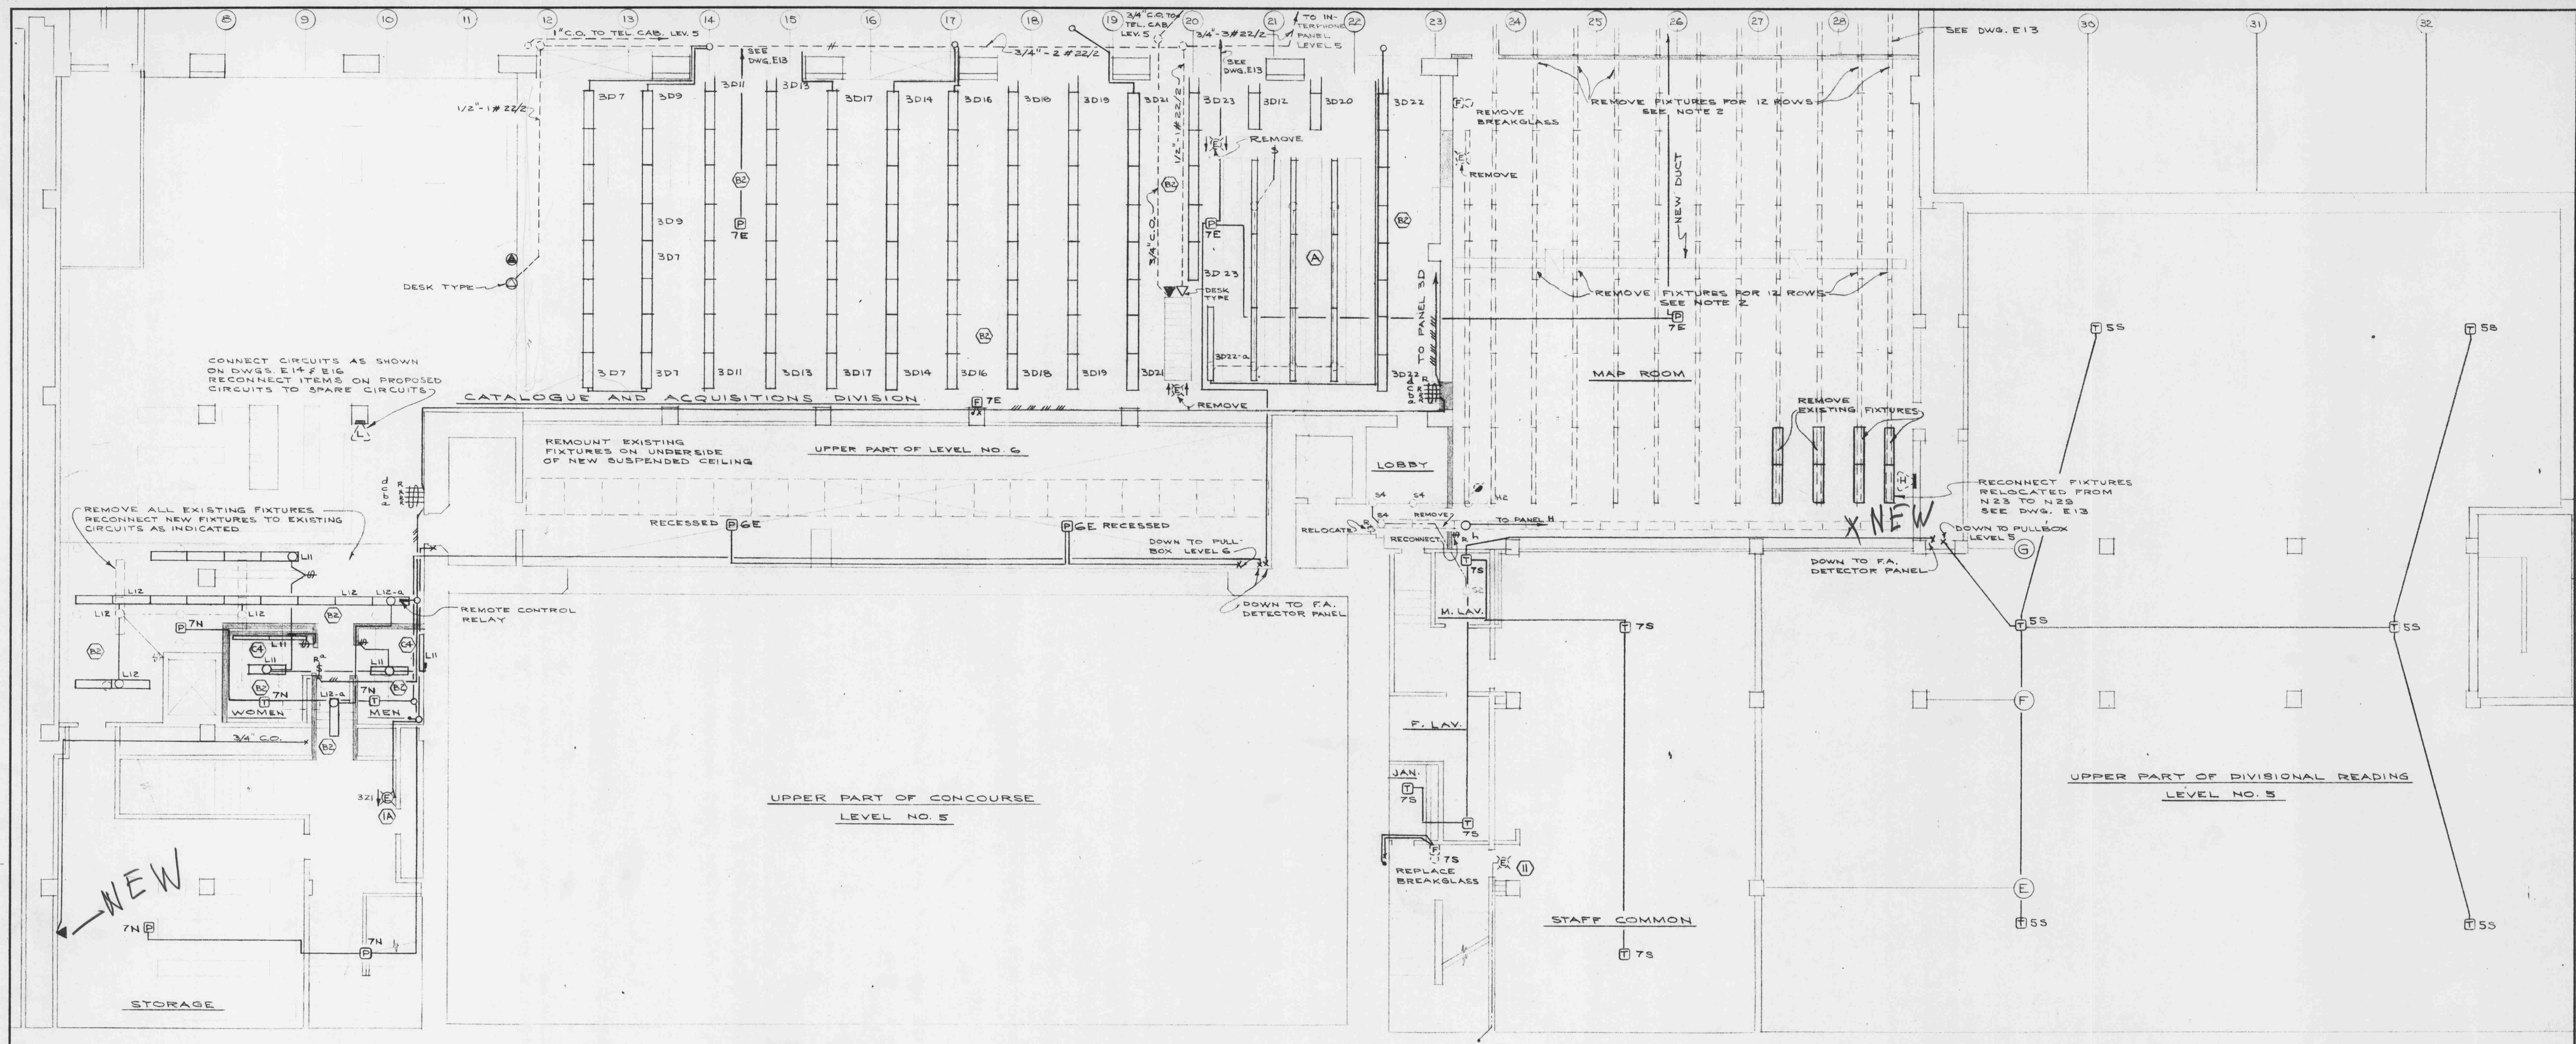

FLOOR PLAN - LEVEL NO. 7 S.W.

SCALE: $1/8" = 1' - 0"$


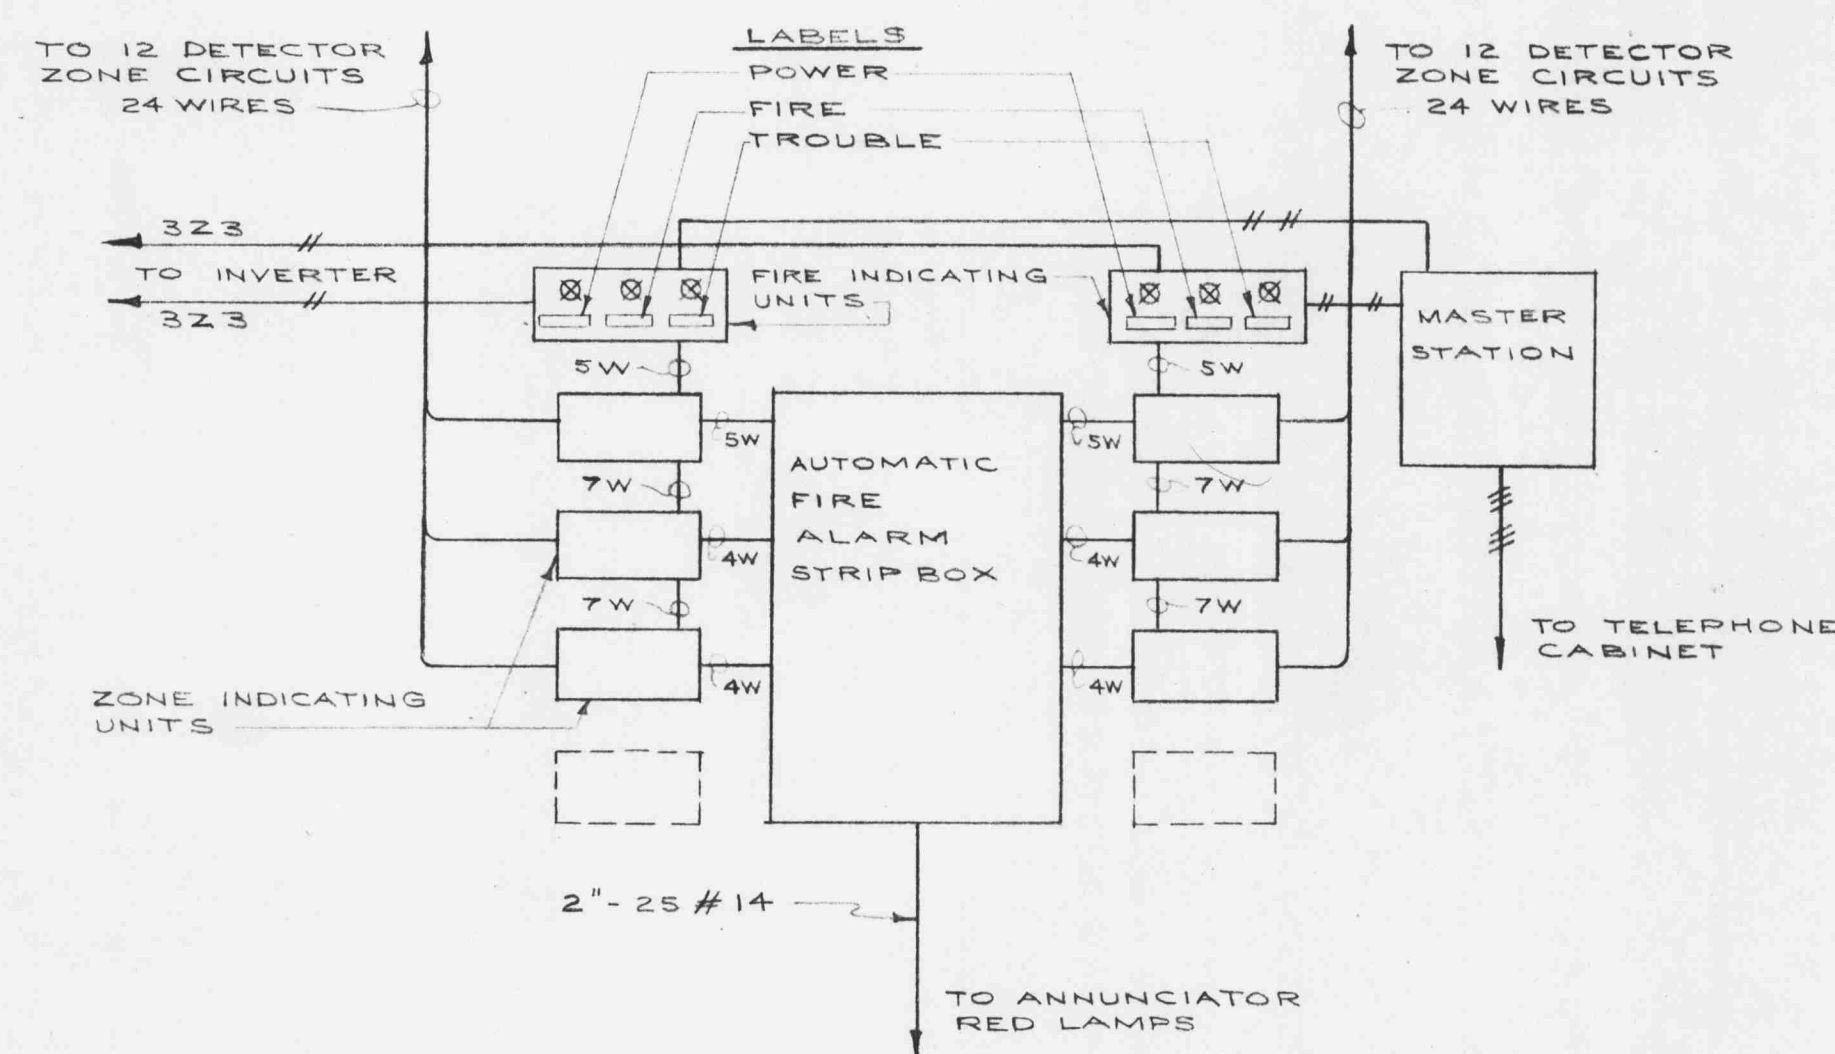


DIAGRAM OF AUTOMATIC DETECTOR UNIT

NOT TO SCALE

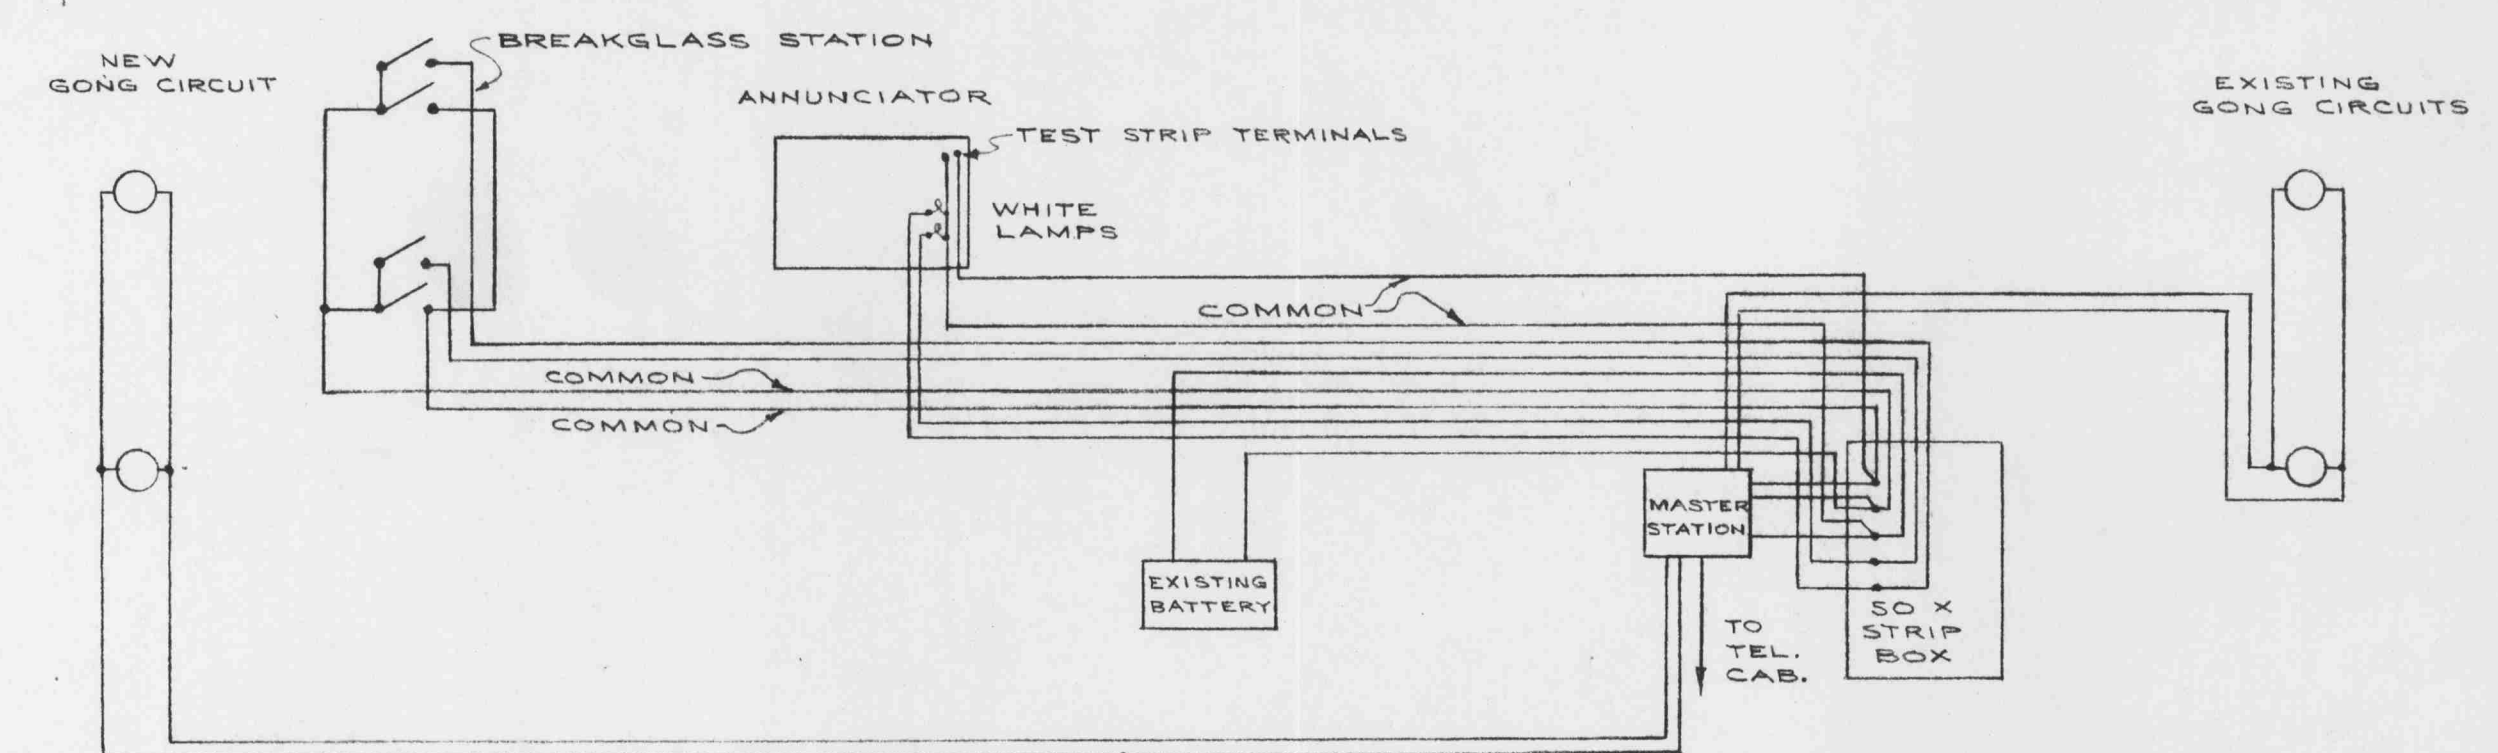

TYPICAL WIRING DIAGRAM FOR MANUAL FIRE ALARM SYSTEM

NOT TO SCALE

ELECTRICAL		No.	REVISION	DATE	ALTERATIONS TO THE LIBRARY UNIVERSITY OF BRITISH COLUMBIA	JOB No.
R. M. CAMPBELL P. ENG. ELECTRICAL ENGINEER 1770 WEST GEORGIA ST. VANCOUVER, B. C.					DATE	
DATE MARCH 31, 1964 SCALE AS NOTED					DRAWN A. C. R.	
JOB No. 685 SHEET No. E14 OF 16					CHECKED <i>Stach</i> DRAWING NO. E14 OF 16	
					STACK LEVEL # 7 S.W.	
					TOBY, RUSSELL & BUCKWELL ARCHITECTS - VANCOUVER, B. C.	