


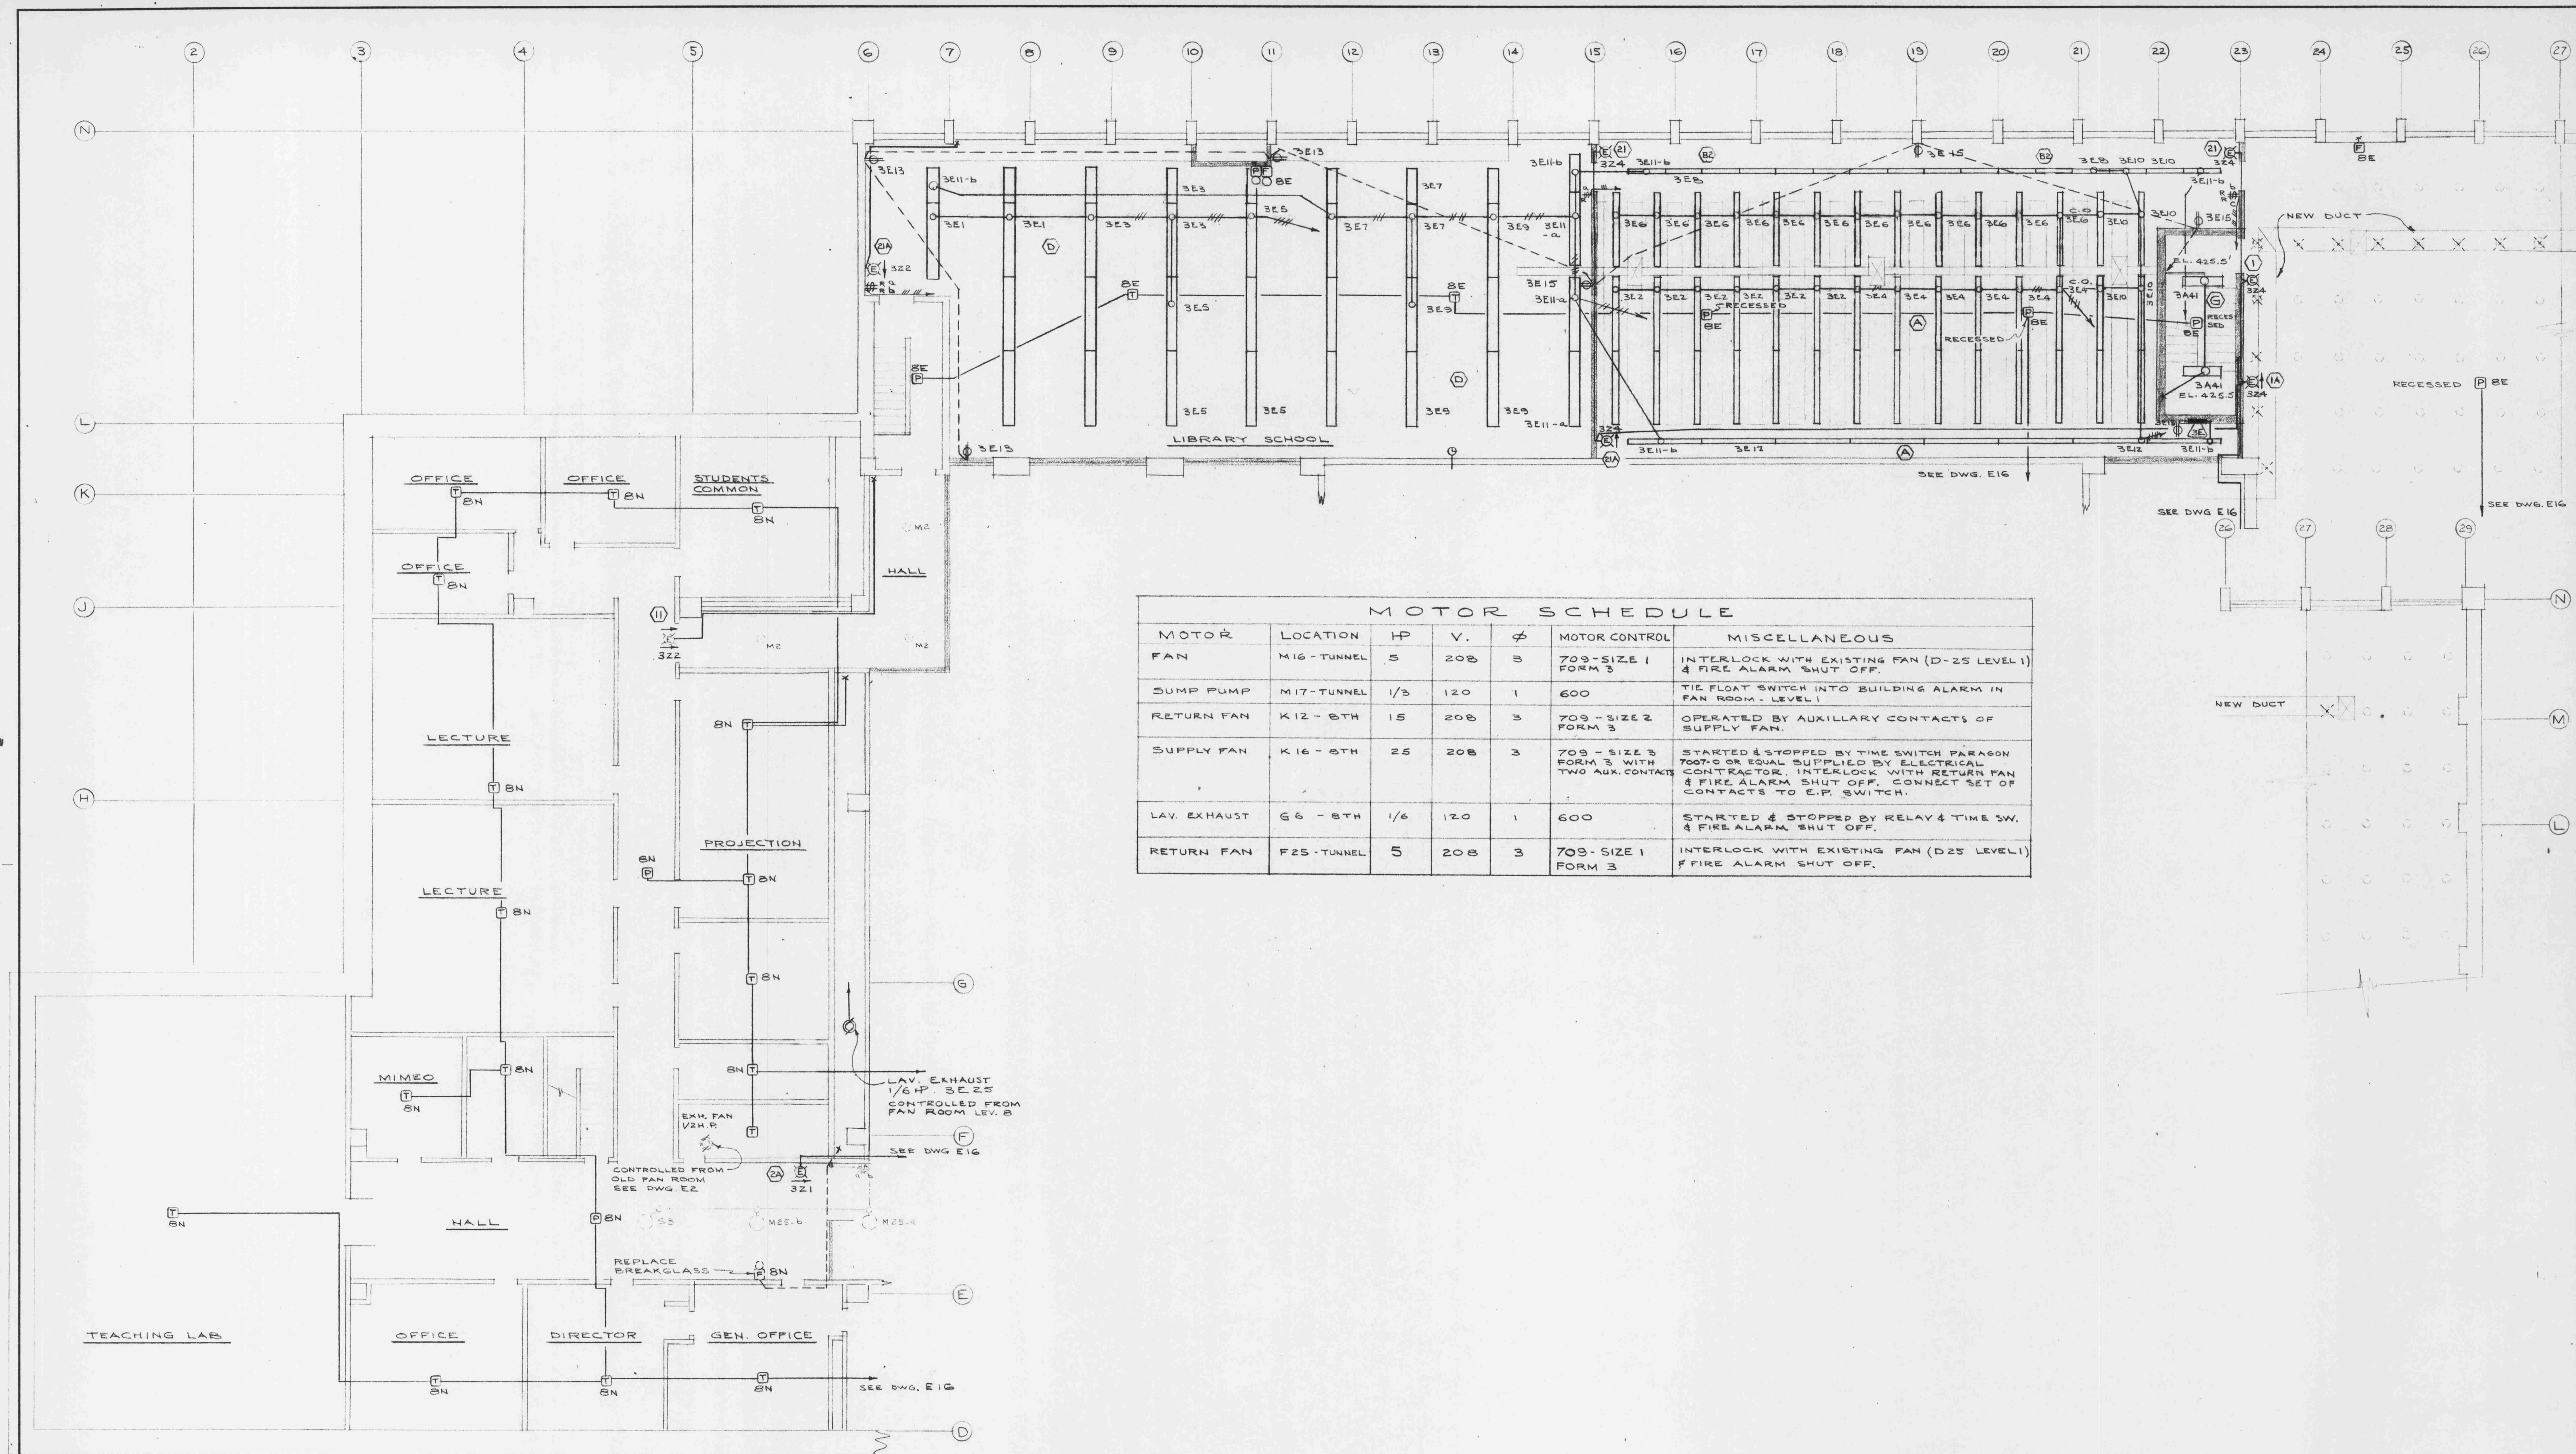

FLOOR PLAN - LEVEL NO. 8 N.E.

SCALE: 1/8" = 1'-0"

ELECTRICAL		ALTERATIONS TO THE LIBRARY		JOB No.
R. M. CAMPBELL P. ENG.		UNIVERSITY OF BRITISH COLUMBIA		DATE
ELECTRICAL ENGINEER		STACK LEVEL #8 N.E.		DRAWN A.D.R.
1770 WEST GEORGIA ST. VANCOUVER, B.C.		TOBY, RUSSELL & BUCKWELL		CHECKED <i>Amble</i>
DATE MARCH 31, 1964	SCALE AS NOTED	ARCHITECTS - VANCOUVER, B.C.		DRAWING No.
JOB No. 685	SHEET No. E15 OF 16	REVISION		E15 OF 16