


- (F₁) - PUMPER CONNECTION - 2 WAY C 2 1/2"
- (F₂) - 4" DRY STAND PIPE WITH 2 1/2" OUTLET
- (F₃) - 4" DRY STAND PIPE
- (F₄) - PUMPER CONNECTION 4 WAY C 2 1/2"
- (F₅) - 6" DRY STAND PIPE
- (F₆) - 6" DRY STANDPIPE WITH 2 1/2" OUTLET
- (F₇) - 2 1/2" WET STAND PIPE & FIRE HOSE CABINET
- (F₈) - 2 1/2" WET STANDPIPE ISOLATION & DRAIN VALVE

NOTES:

1. PROVIDE CHECK VALVE & GATE VALVE ON EACH LINE AT POINT OF CONNECTION ON H.W.R. LINE PROVIDE SARCO TYPE V. BALANCE FITTING.
2. PROVIDE ADJUSTABLE COUNTERWEIGHT MECHANISM FOR EXISTING ALUMINUM BACK DRAFT DAMPERS (42x96) & MODIFY TRANSFORMER VAULT FAN DUCTWORK AS DIRECTED

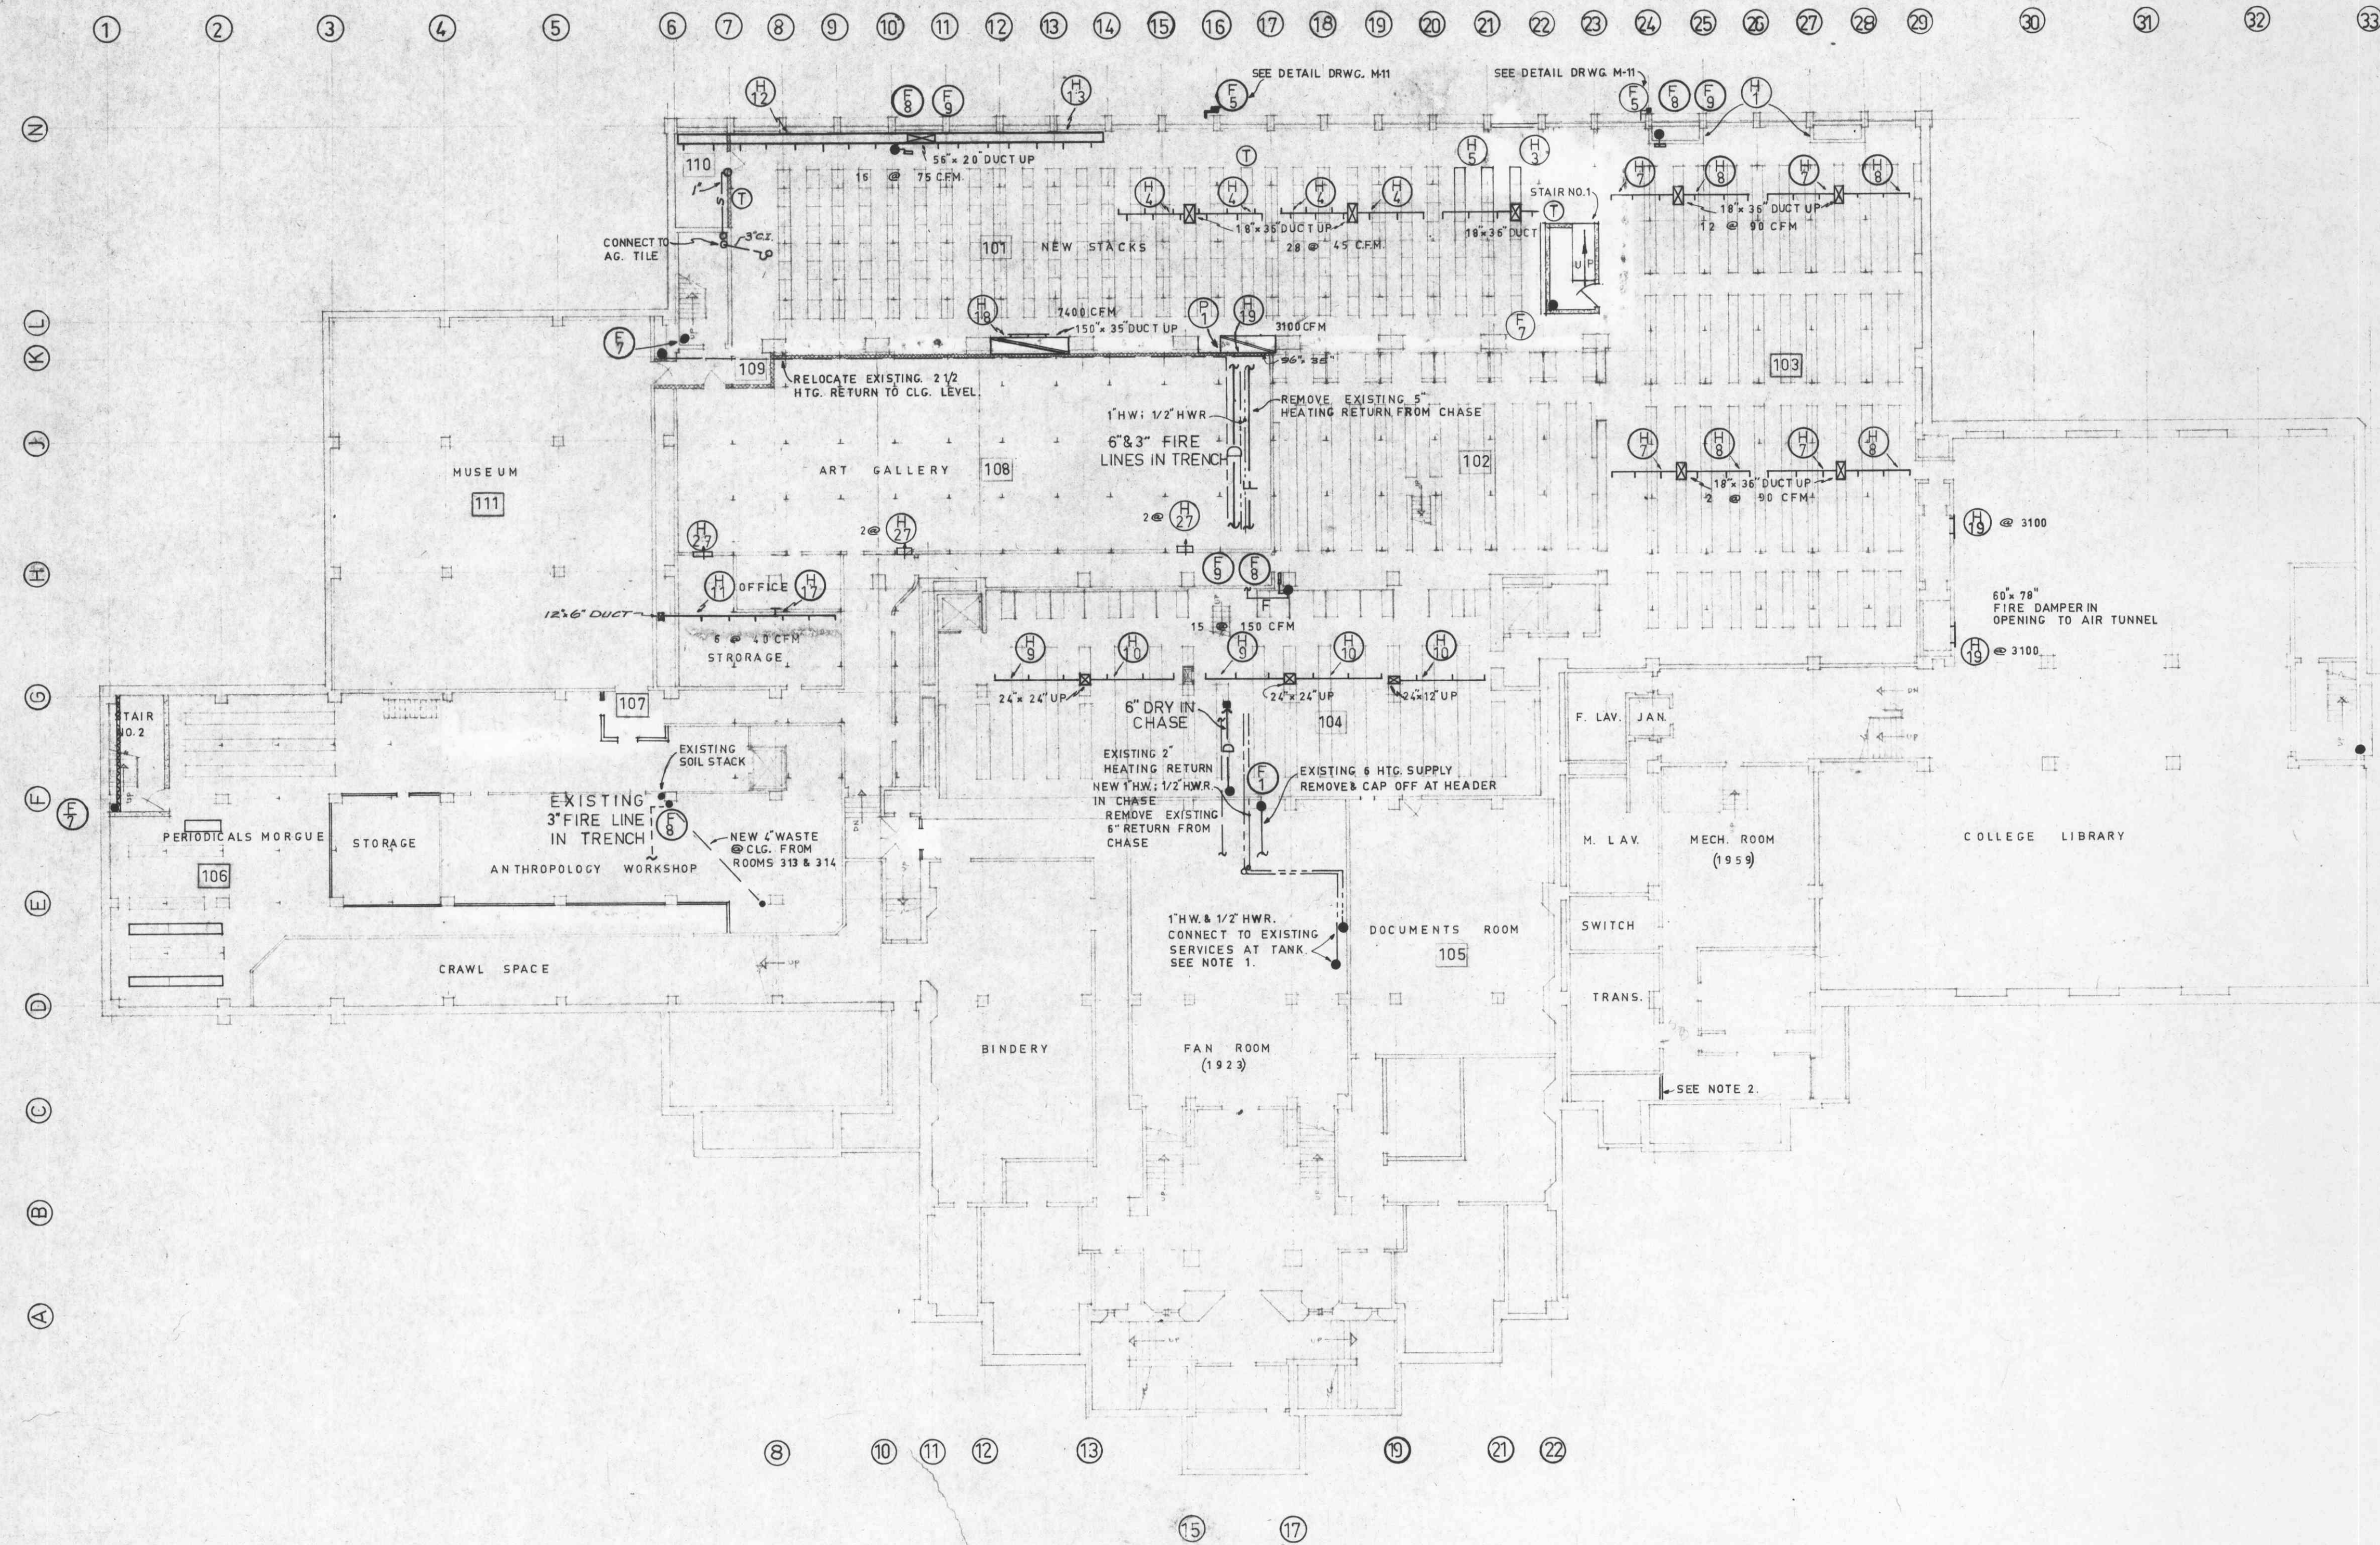

SCALE 1/16"=1'-0" STACK FLOOR ELEV. 365'02"



JOHN M. BEAN P. ENG.
CONSULTING MECHANICAL ENGINEER
779 WEST BROADWAY VANCOUVER B.C.

ALTERATIONS TO THE LIBRARY		JOB No.
UNIVERSITY OF BRITISH COLUMBIA		6366
FLOOR PLAN - STACK LEVEL No 1		DATE MARCH 31/64
DRAWN JDS & DJ		CHECKED J.M.B.
TOBY, RUSSELL & BUCKWELL		DRAWING No. M1 of 11
ARCHITECTS VANCOUVER, B.C.		

SET No 8