



VENTILATION SYSTEM SYMBOLS

- (H 1) REMOVE EXISTING 36" x 24" E F R F RETURN GRILLES AND RE-USE WHEN INDICATED. PROVIDE A NEW G V O L DAMPER AS INDICATED. MAKE GOOD FURRING.
- (H 2) PROVIDE FIRE DAMPERS IN RETURN AIR SHAFTS AT EACH FLOOR AND SIMILAR TO THE FIRE DAMPER DETAILED ON DRAWING M-10
- (H 3) TO (H 16) SEE SCHEDULE OF WING DUCTS ON DRAWING M-10


SIZE	USE	BARBER COLEMAN TYPE	DAMPER	FINISH
10" x 4"	SUPPLY	EA1A	G V O L	CAD PLATE
3" - 36" x 24"	RETURN	—	NEW G V O L	EXIST. (H-1)
48" x 28"	RETURN	EFVF	G V O L	CAD PLATE
36" x 24"	RETURN	—	G V O L	EXIST. (H-1)
24" x 6"	SUPPLY	EA1A	G V O L	CAD PLATE
8" x 4"	EXHAUST	EFVF	G V O L	"
8" x 6"	EXHAUST	EFVF	G V O L	"
12" x 8"	DOOR	AFVF	—	"
14" x 5"	EXHAUST	EFVF	G V O L	"
18" x 16"	DOOR	AFVF	—	"
RELOCATED (H 1) WITH NEW FIRE DAMPERS IN FIRE WALL (NO G V O L)				
2 @ 36" x 24"	TRANSFER	EFVF	—	CAD PLATE
2 @ 30" x 16"	TRANSFER	EFVF	FIRE DAMPER IN FIRE WALLS	"
NEW VENTILATION SYSTEM THERMOSTAT & GUARD				
24" x 3"	SUPPLY	EA1A	G V O L	CAD PLATE
2 @ 24" x 12"	TRANSFER	EFVF	—	"
18" x 10"	EXHAUST	EFVF	G V O L	"

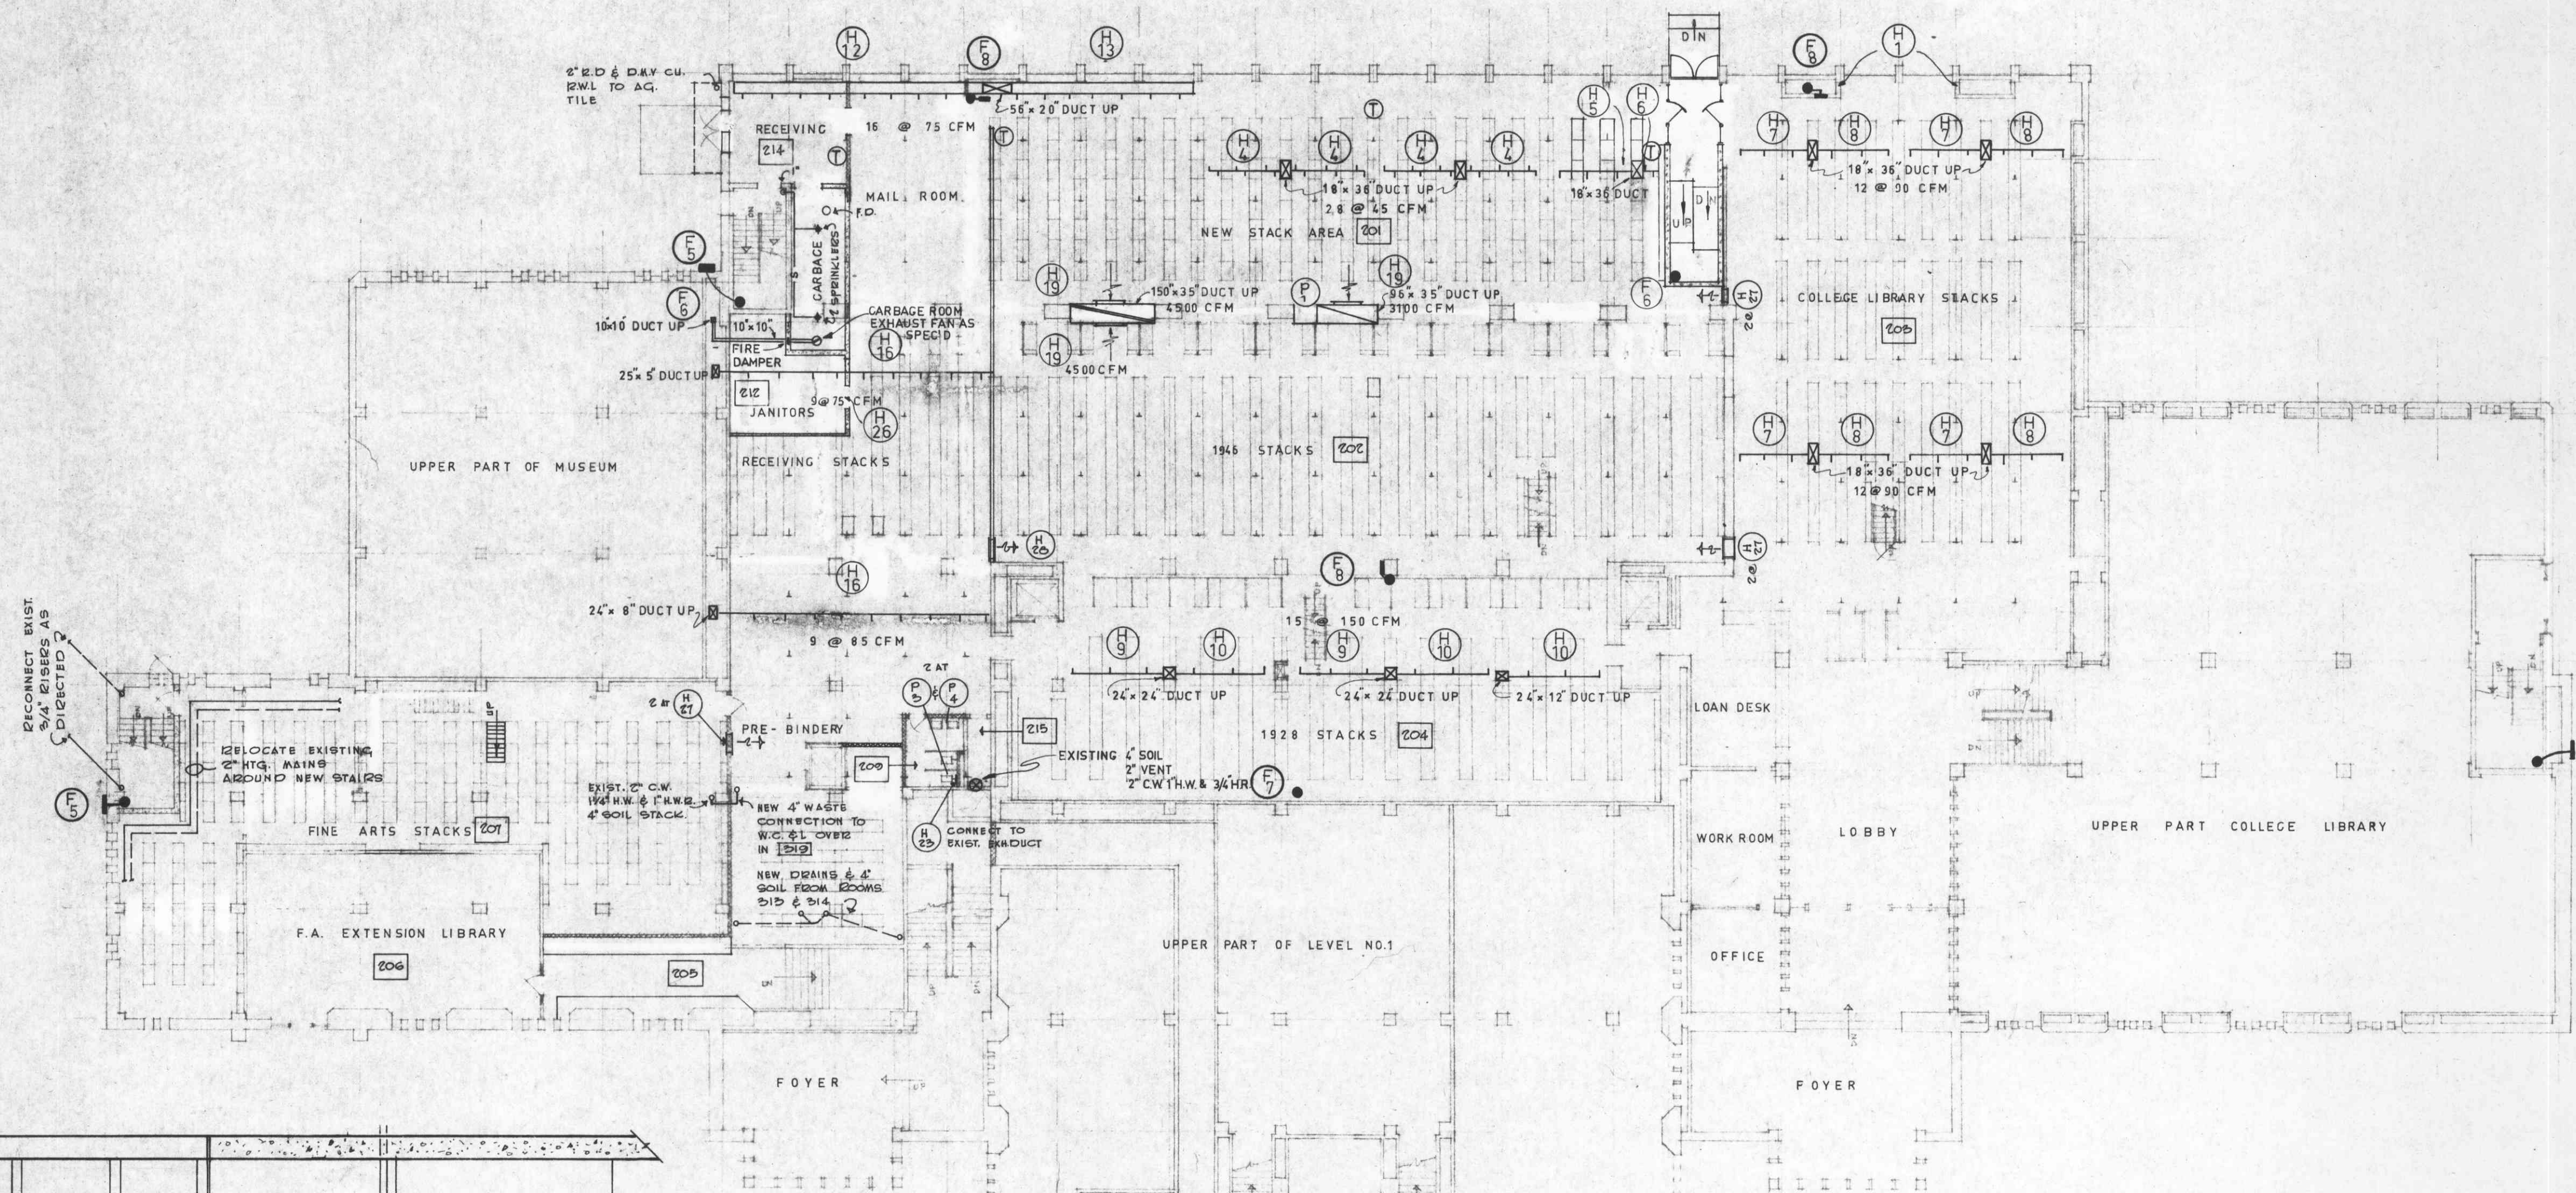


SOUND ISOLATE 6 FEET OF RETURN DUCT AT K-17

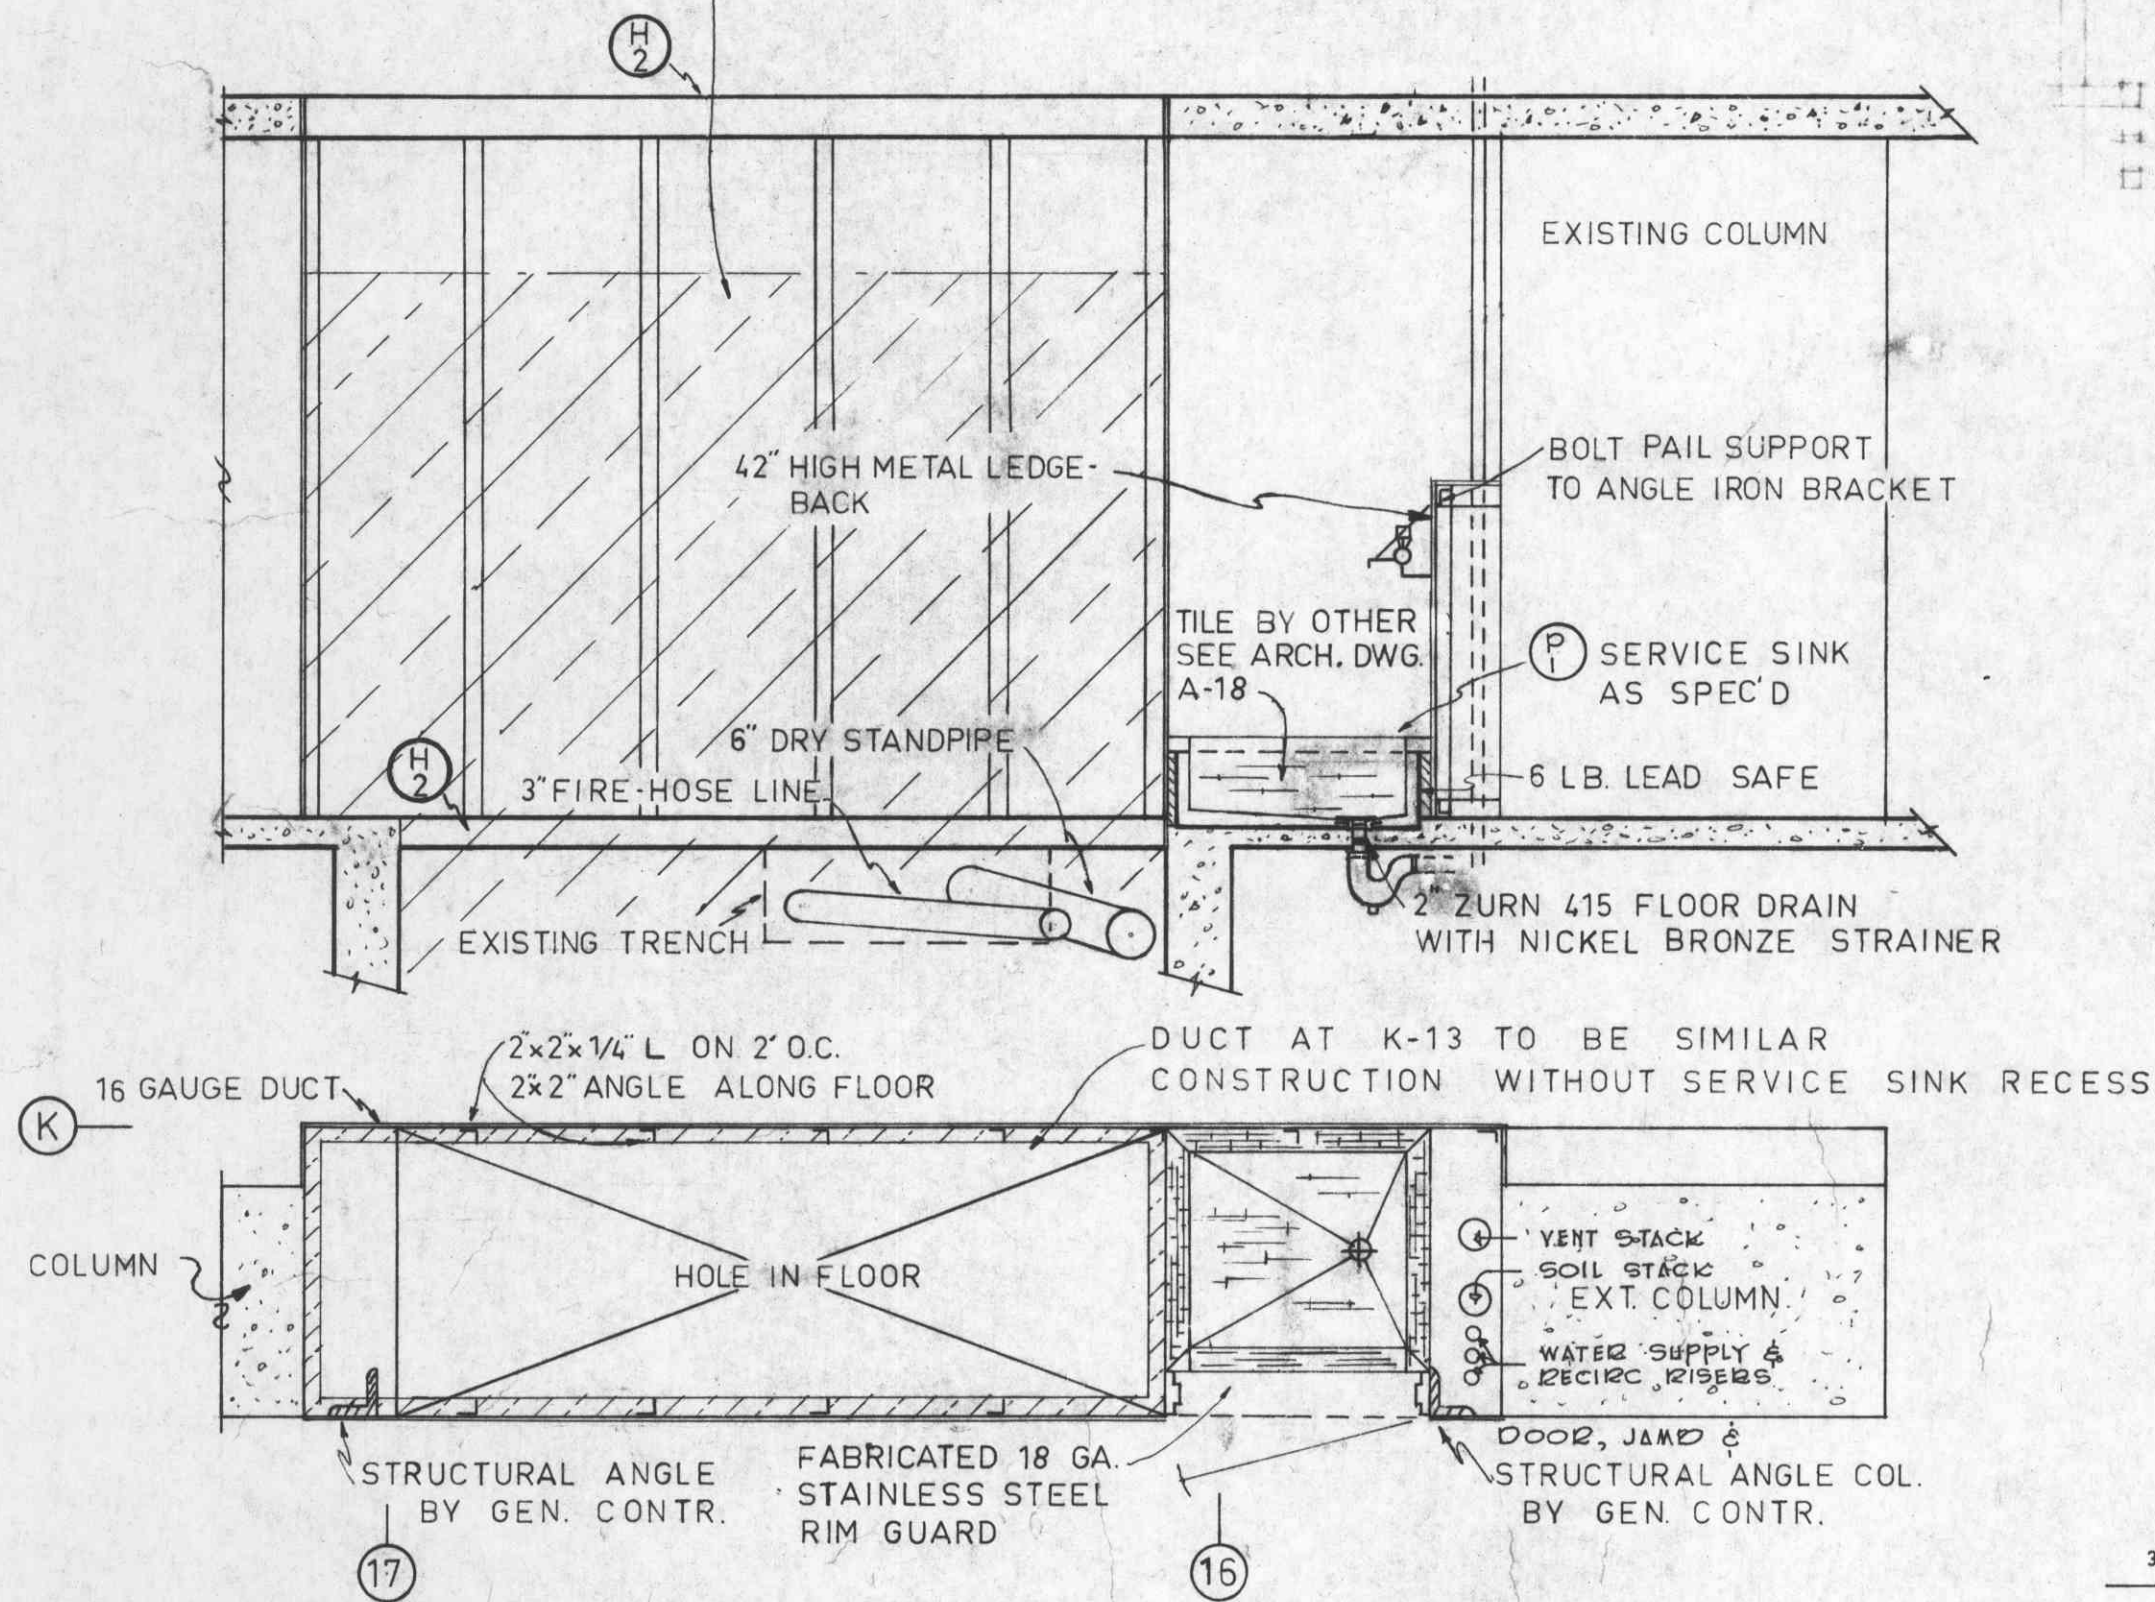

DETAIL OF RETURN AIR SHAFT
1/2" = 1'-0"

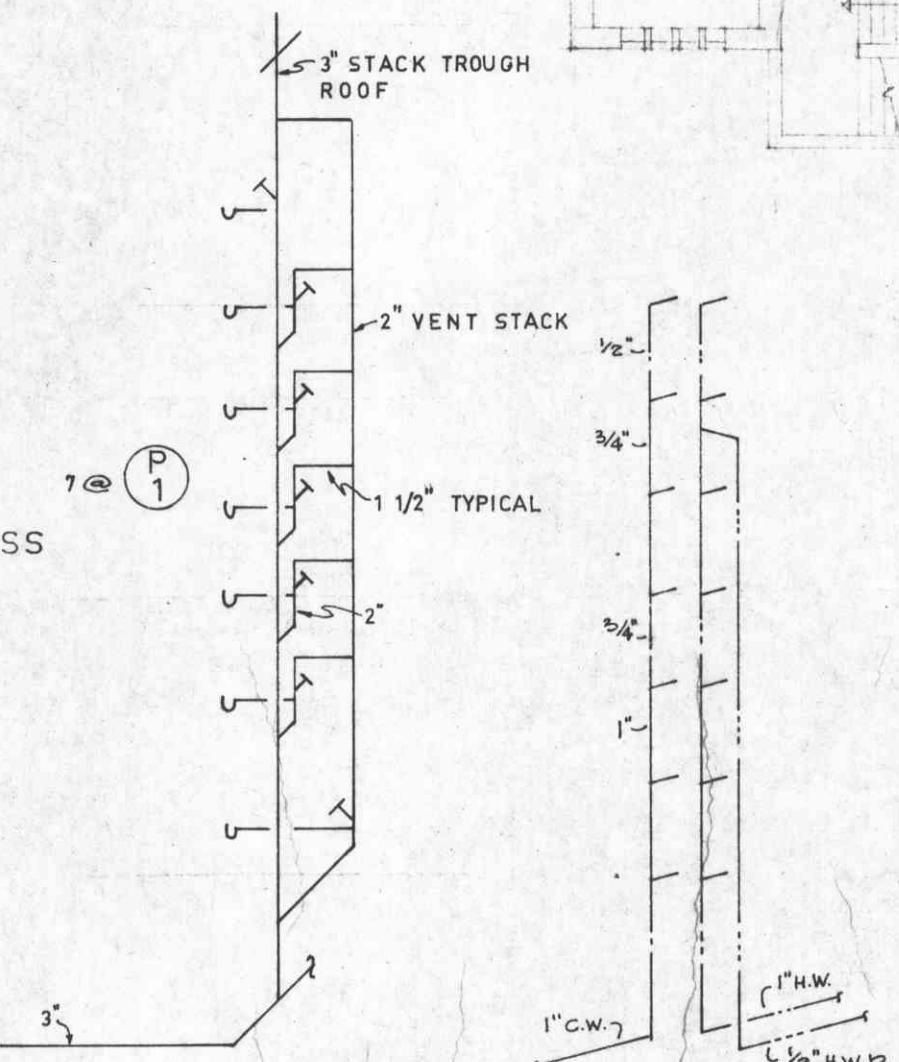

SERVICE SINK RISER SCHEMATICS

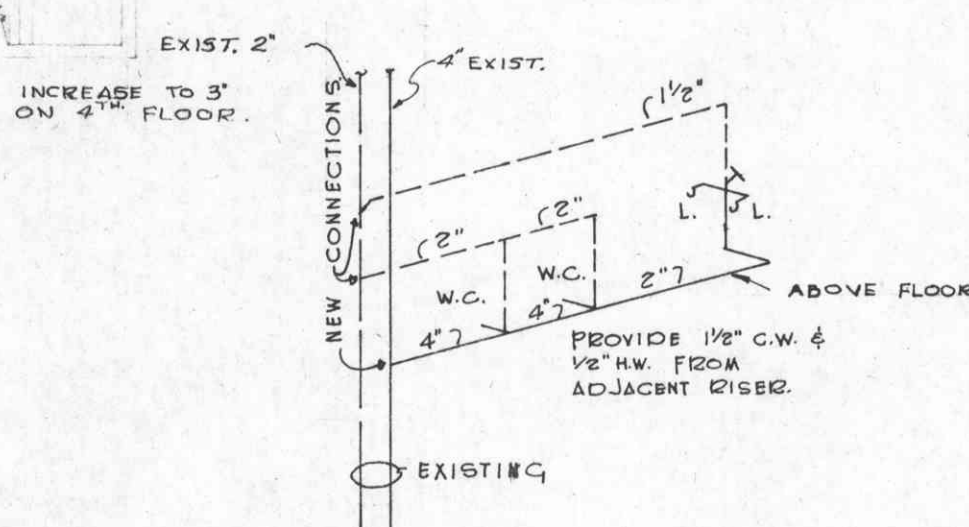

PLUMBING SCHEMATIC FOR RM. 209

SCALE 1/16" = 1'-0" STACK FLOOR ELEV. 372.5'



JOHN M. BEAN P. ENG.
CONSULTING MECHANICAL ENGINEER
779 WEST BROADWAY VANCOUVER B.C.

ALTERATIONS TO THE LIBRARY UNIVERSITY OF BRITISH COLUMBIA	JOB NO. 6366
FLOOR PLAN - STACK LEVEL No 2	DATE MARCH 31/64
TOBY, RUSSELL & BUCKWELL ARCHITECTS VANCOUVER, B.C.	DRAWN J.D.S. & D.J.
	CHECKED J.M.B.
	DRAWING NO. M2 OF 11