


PLUMBING SYSTEM SYMBOLS

- P 1 NEW SERVICE SINK
- P 2 NEW FLOOR DRAIN
- P 3 NEW WATER CLOSET
- P 4 NEW LAVATORY
- P 5 NEW URINAL
- P 6 NEW DRINKING FOUNTAIN
- P 7 NEW SERVICE SINK

MAXIMUM NO. OF FIXTURES ON PIPING

PIPE SIZE	1/2"	3/4"	1"	1 1/4"	1 1/2"	2"
BASINS	3					
URINALS		1	2	5		
W.C.'S			1	2	3	8

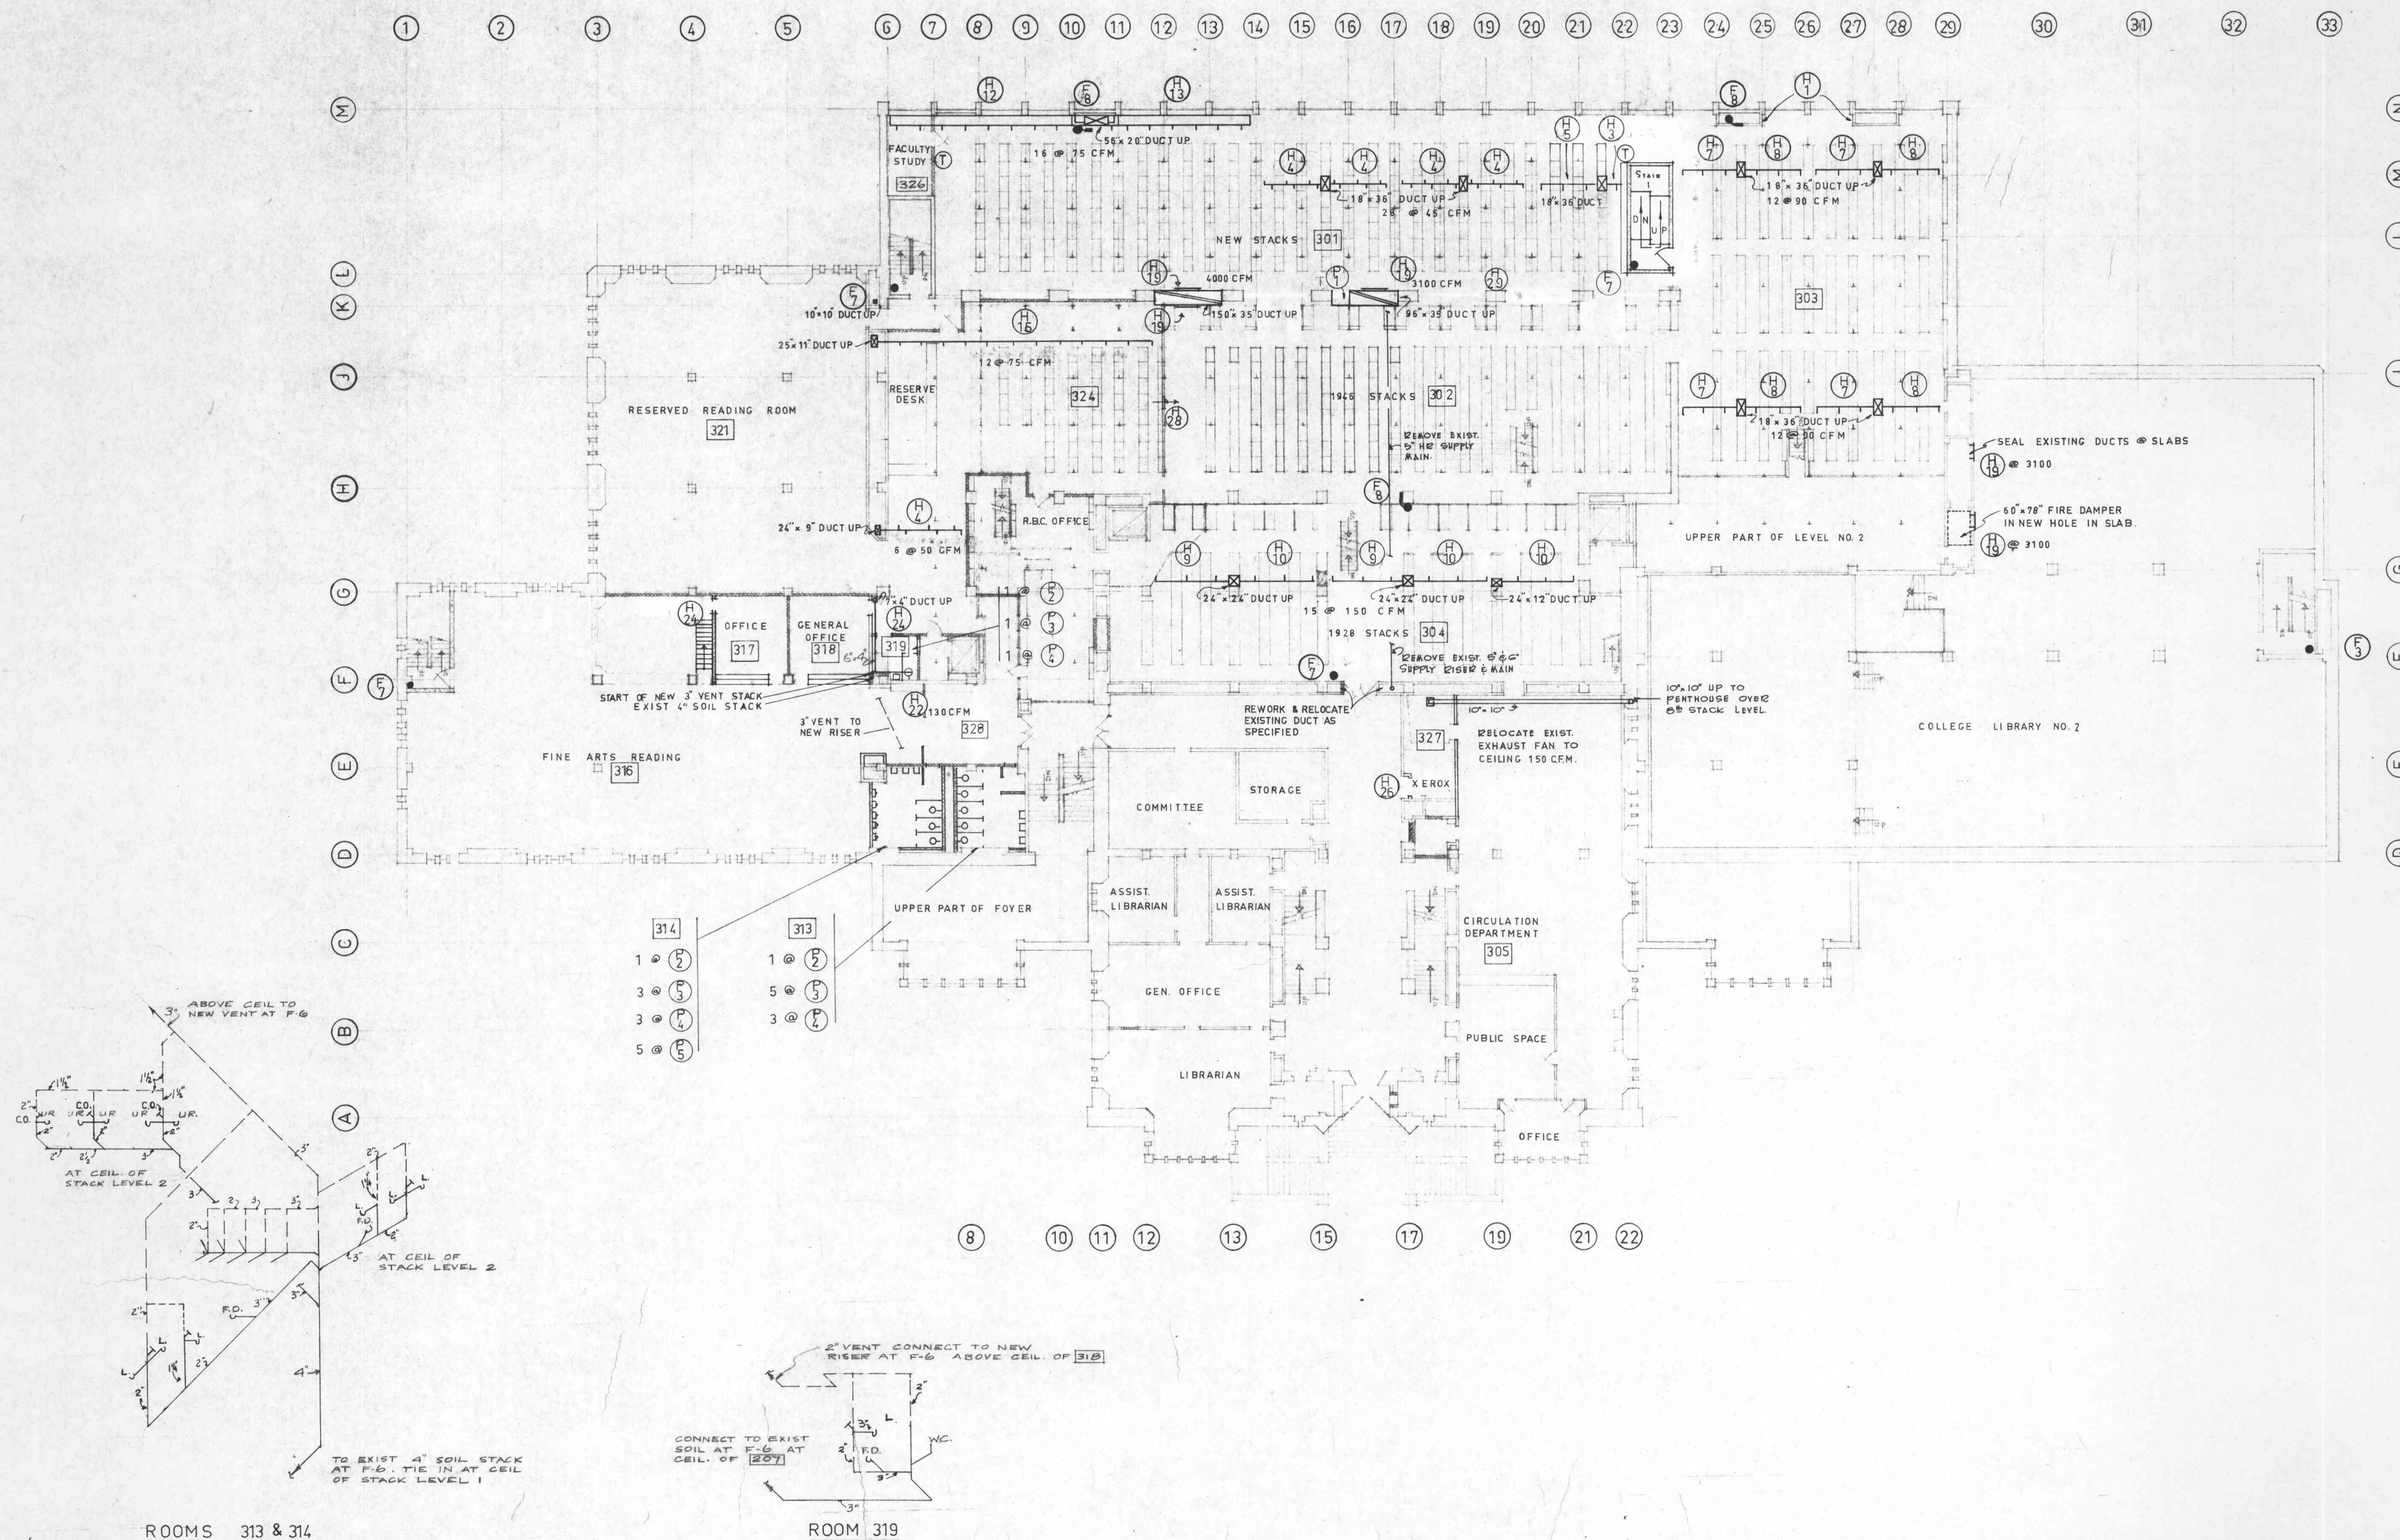

SCALE 1/16"=1'-0" STACK FLOOR ELEV. 380'-0"

PLUMBING SCHEMATIC DIAGRAMS

PROVIDE 2" C.W. SUPPLY, 1" H.W. SUPPLY & 1/2" REG. H.W. FROM RISERS AT F-6 ABOVE CEIL. OF 313 & 322

JOHN M. BEAN P. ENG.

CONSULTING MECHANICAL ENGINEER

779 WEST BROADWAY VANCOUVER B.C.

ALTERATIONS TO THE LIBRARY	JOB NO. 6366
UNIVERSITY OF BRITISH COLUMBIA	DATE MARCH 31/64
FLOOR PLAN - STACK LEVEL NO. 3	DRAWN J.D.S. & D.J.
TOBY, RUSSELL & BUCKWELL ARCHITECTS VANCOUVER, B.C.	CHECKED J.M.B.
	DRAWING NO. M3 OF 11

NO. REVISION DATE