



SITE PLAN
SCALE - 1" = 100'

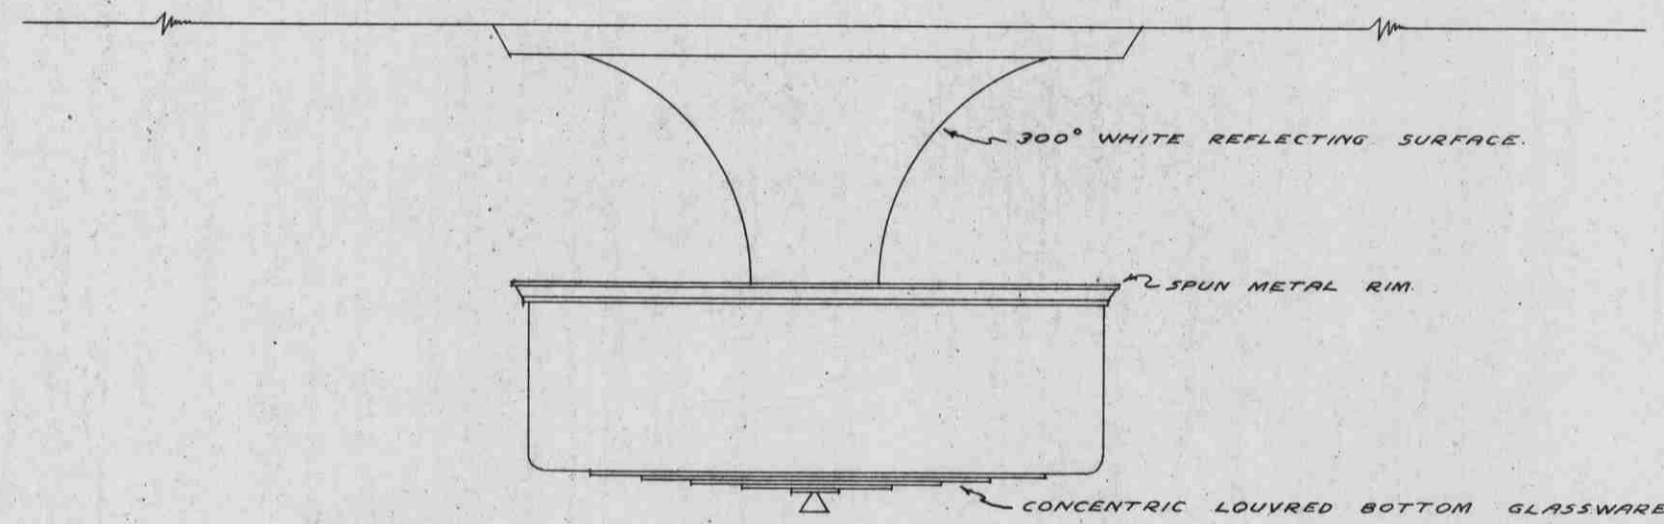


TYPE J FIXTURE DETAIL
SCALE - 1/4" = 1"

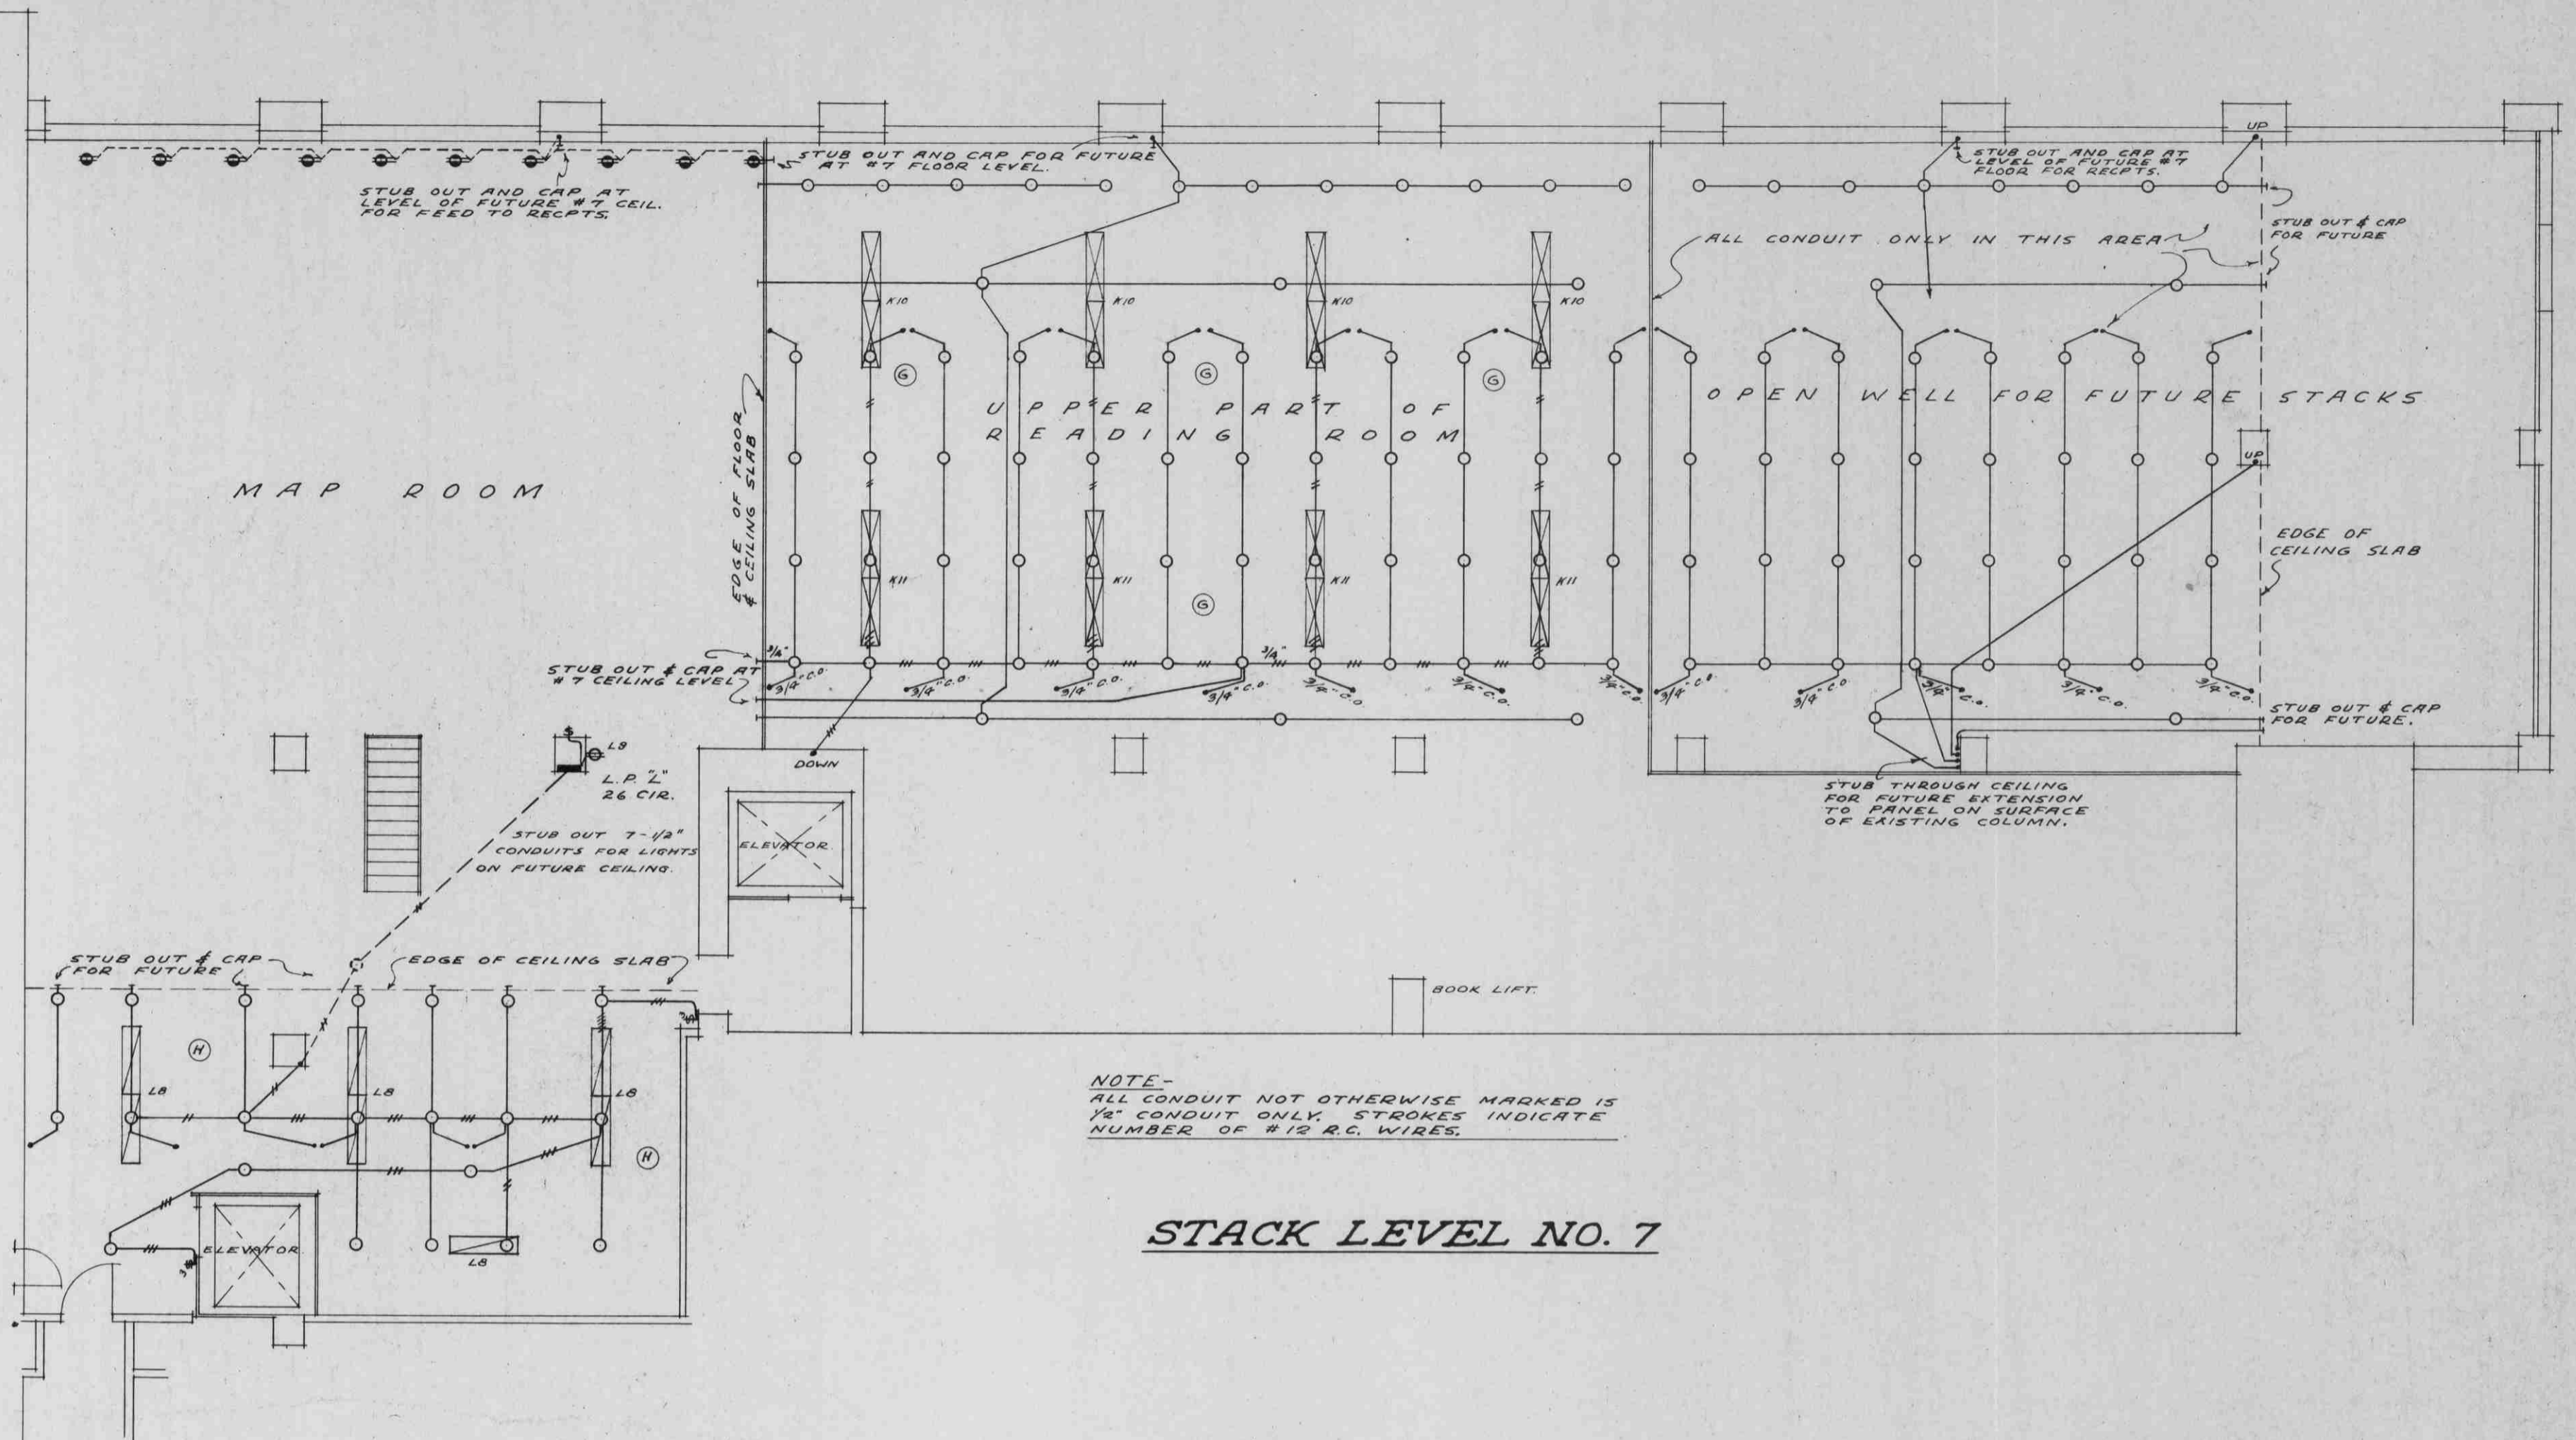

NOTE - ALL CONDUIT NOT OTHERWISE MARKED IS 1/2" CONDUIT ONLY. STROKES INDICATE NUMBER OF #12 R.C. WIRES.

STACK LEVEL NO. 7

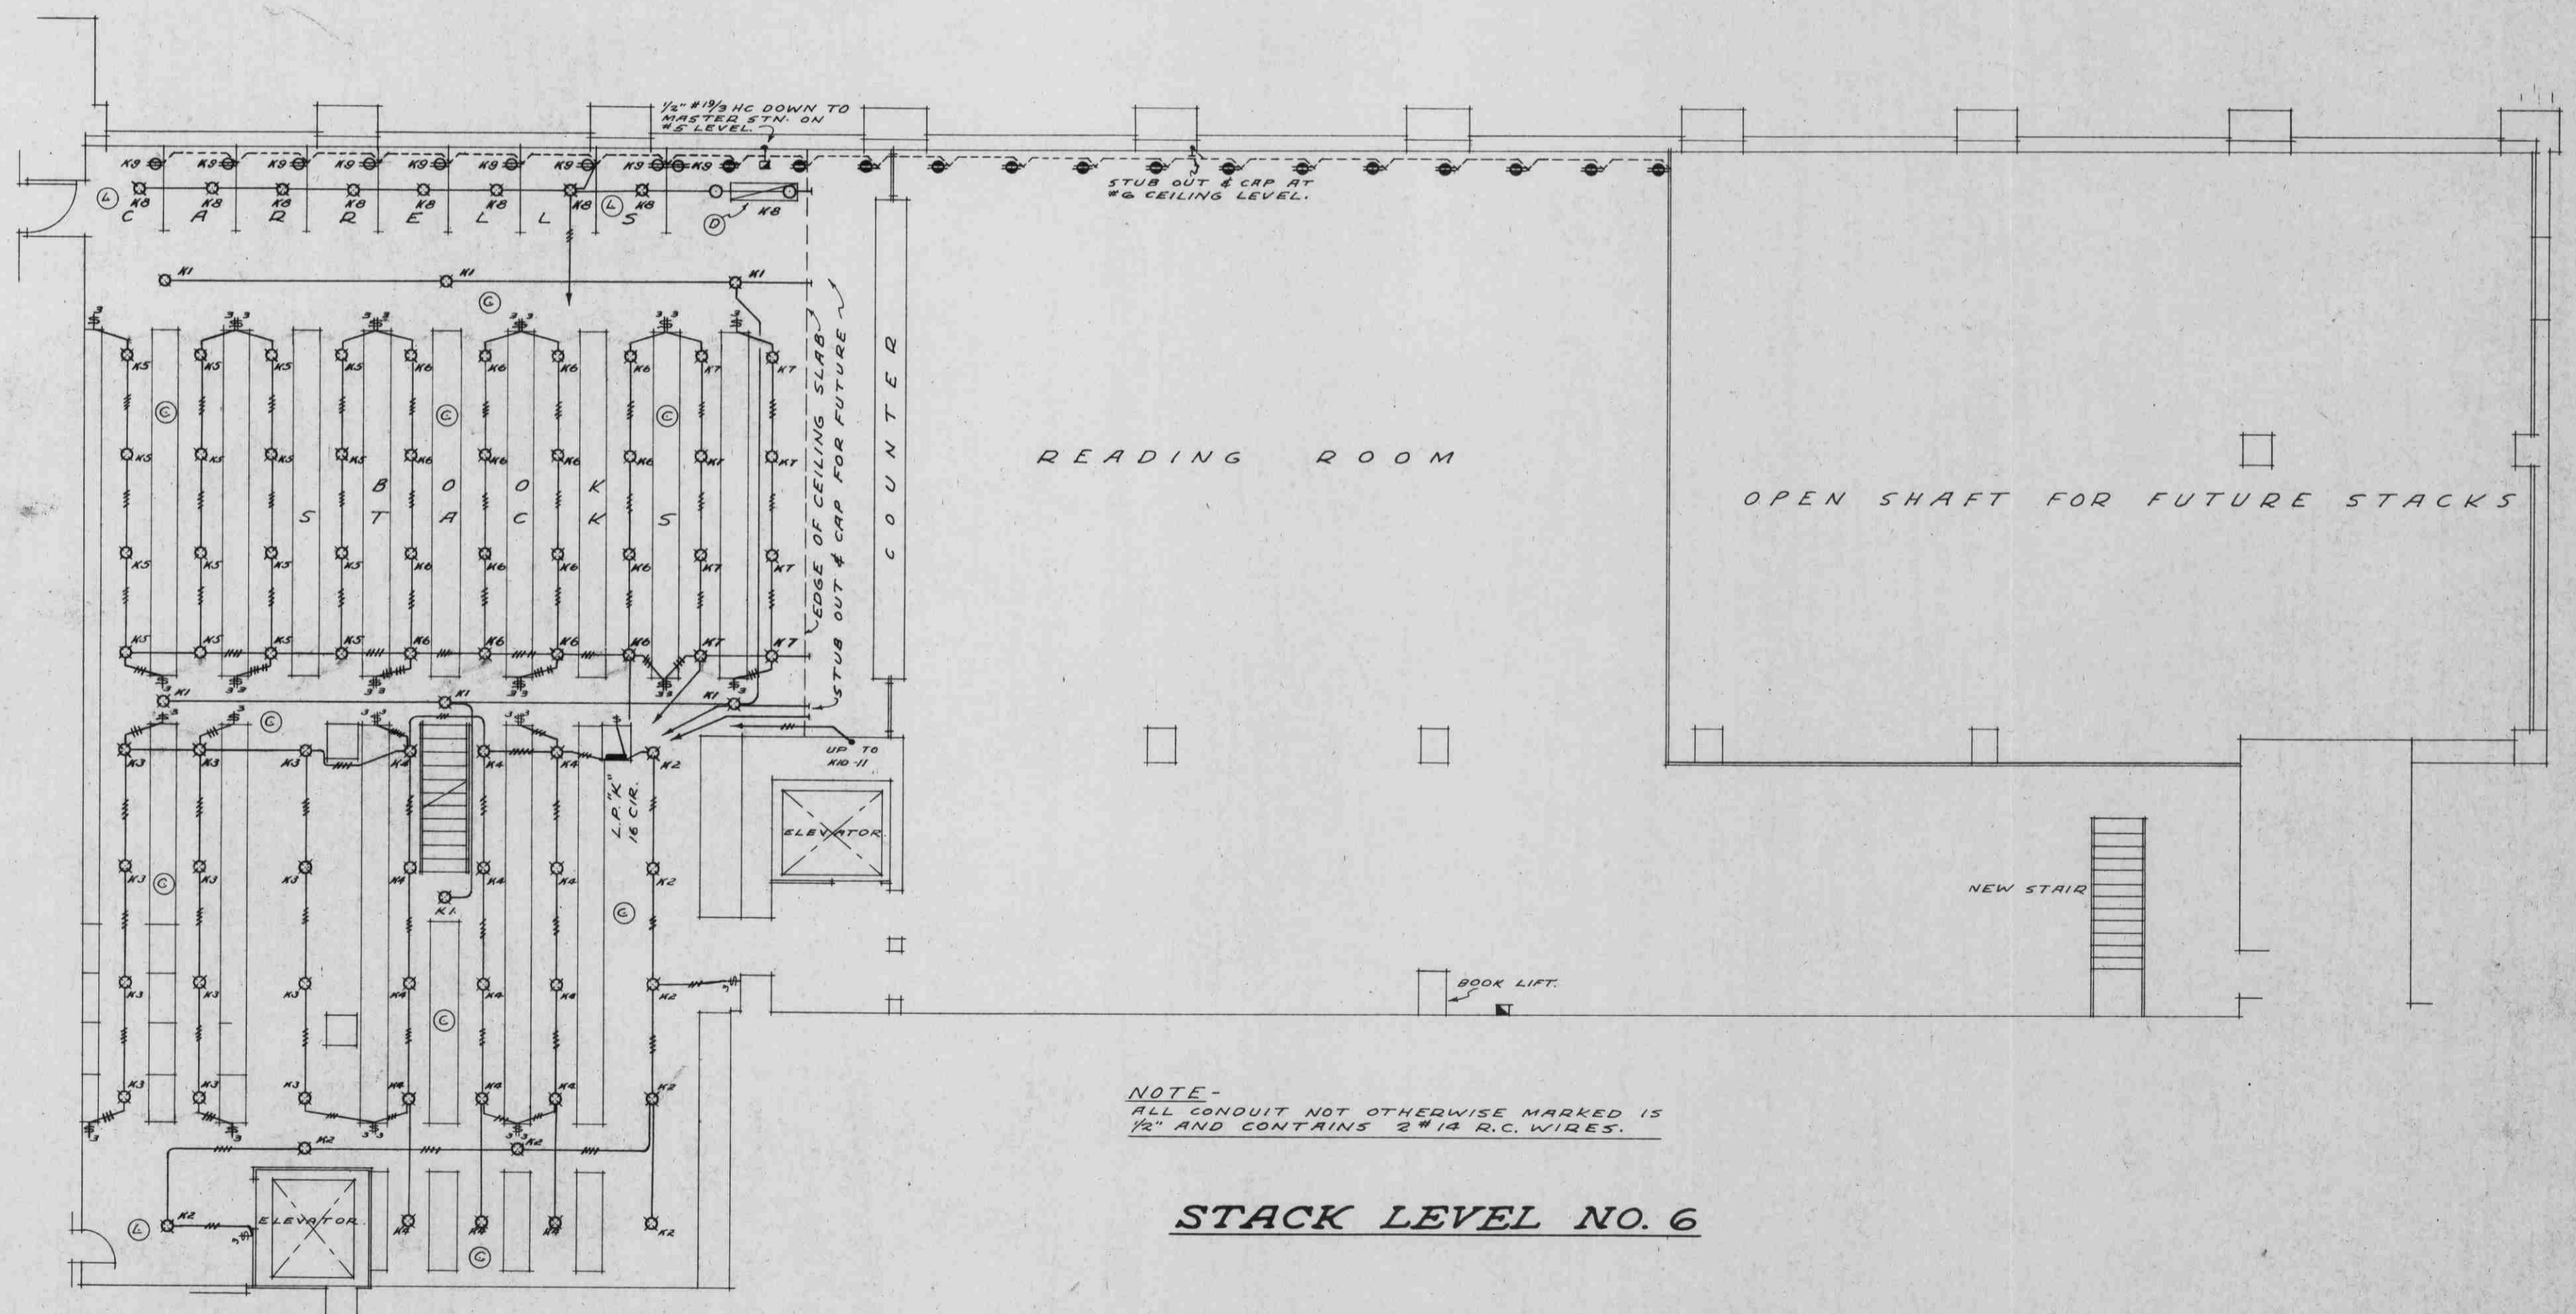

NOTE - ALL CONDUIT NOT OTHERWISE MARKED IS 1/2" AND CONTAINS 2 #12 R.C. WIRES.

STACK LEVEL NO. 6

ELECTRICAL PLAN
STACK LEVELS 6 & 7

REVISION DATE 25 JULY 1946	ADDITION TO LIBRARY		SCALE 1/8" = 1'-0"
	UNIVERSITY OF B.C.		DATE 25 JULY, 1946
	A. EDWARD SIMPSON ELECTRICAL ENGINEER VANCOUVER, B.C.	SHARP & THOMPSON ARCHITECTS VANCOUVER, B.C.	DRAWING NO. U2-5-6