


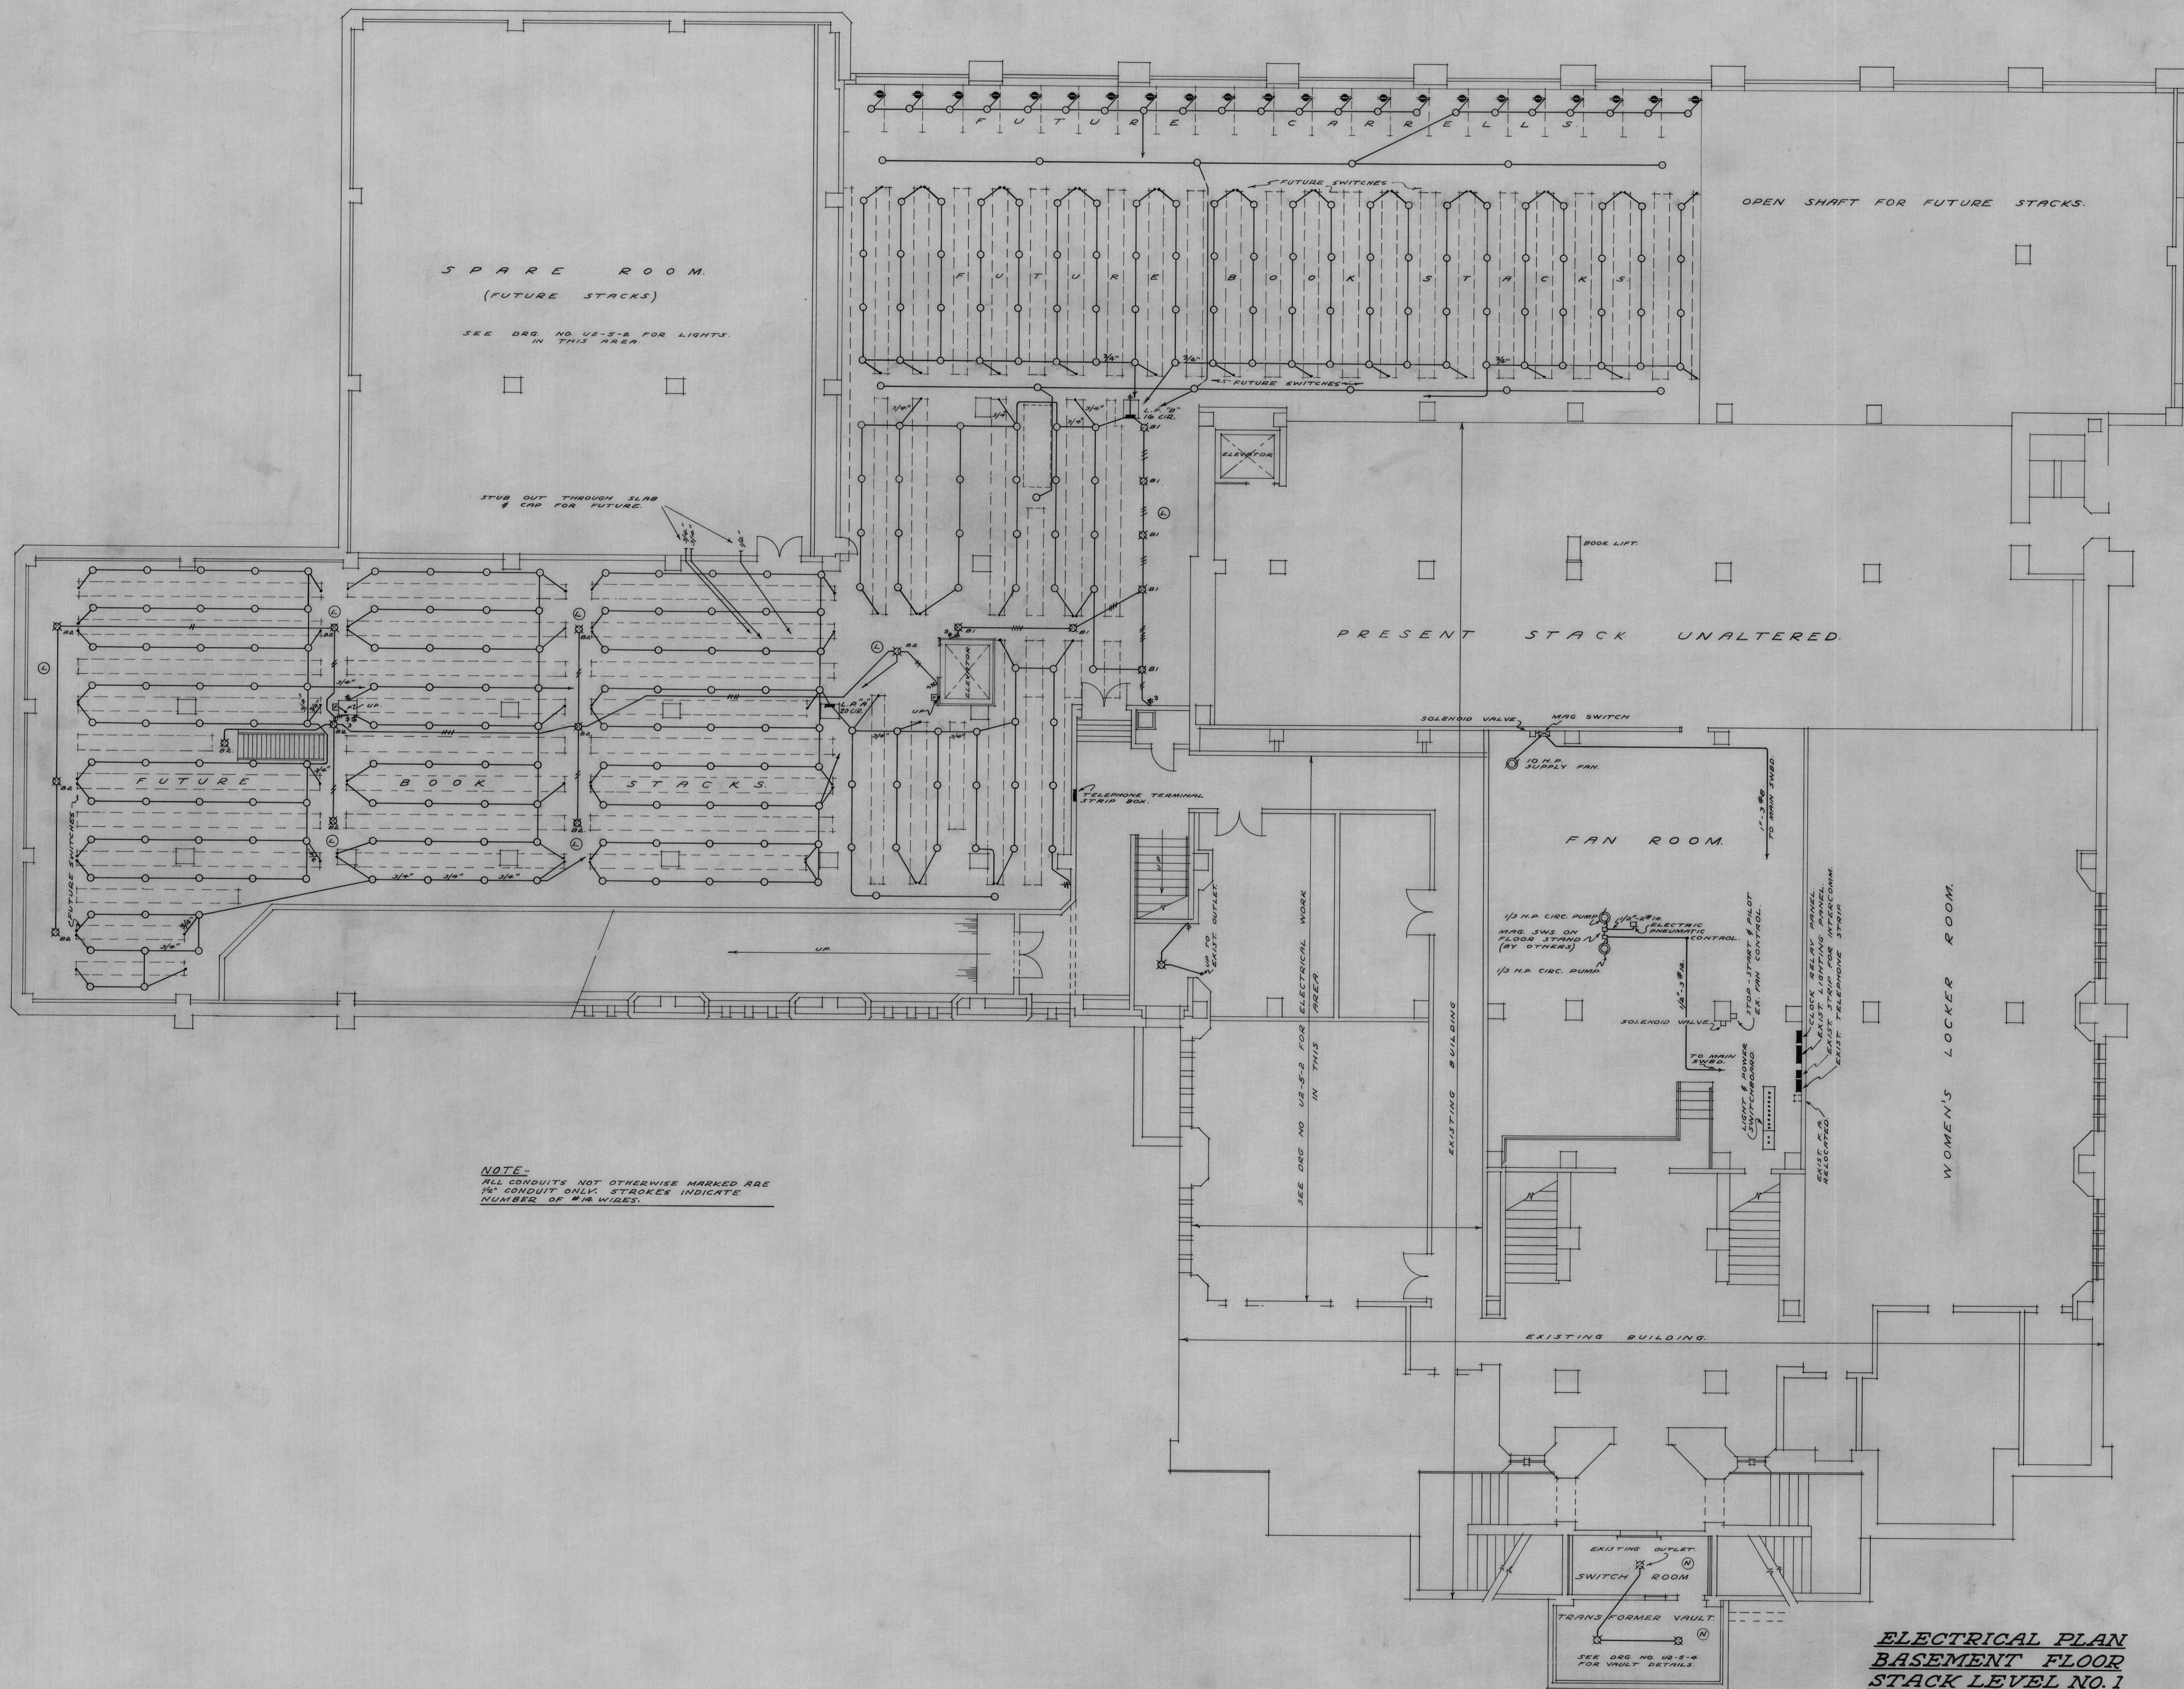

**ELECTRICAL PLAN
BASEMENT FLOOR
STACK LEVEL NO. 1**

REVISION DATE 28 APRIL 47	ADDITION TO LIBRARY		SCALE 1/8" = 1'-0"
	UNIVERSITY OF B.C.		DATE 25 JULY, 1946
	A. EDWARD SIMPSON ELECTRICAL ENGINEER VANCOUVER, B.C.		DRAWING NO. U2-5-1
	SHARP & THOMPSON ARCHITECTS VANCOUVER, B.C.		