

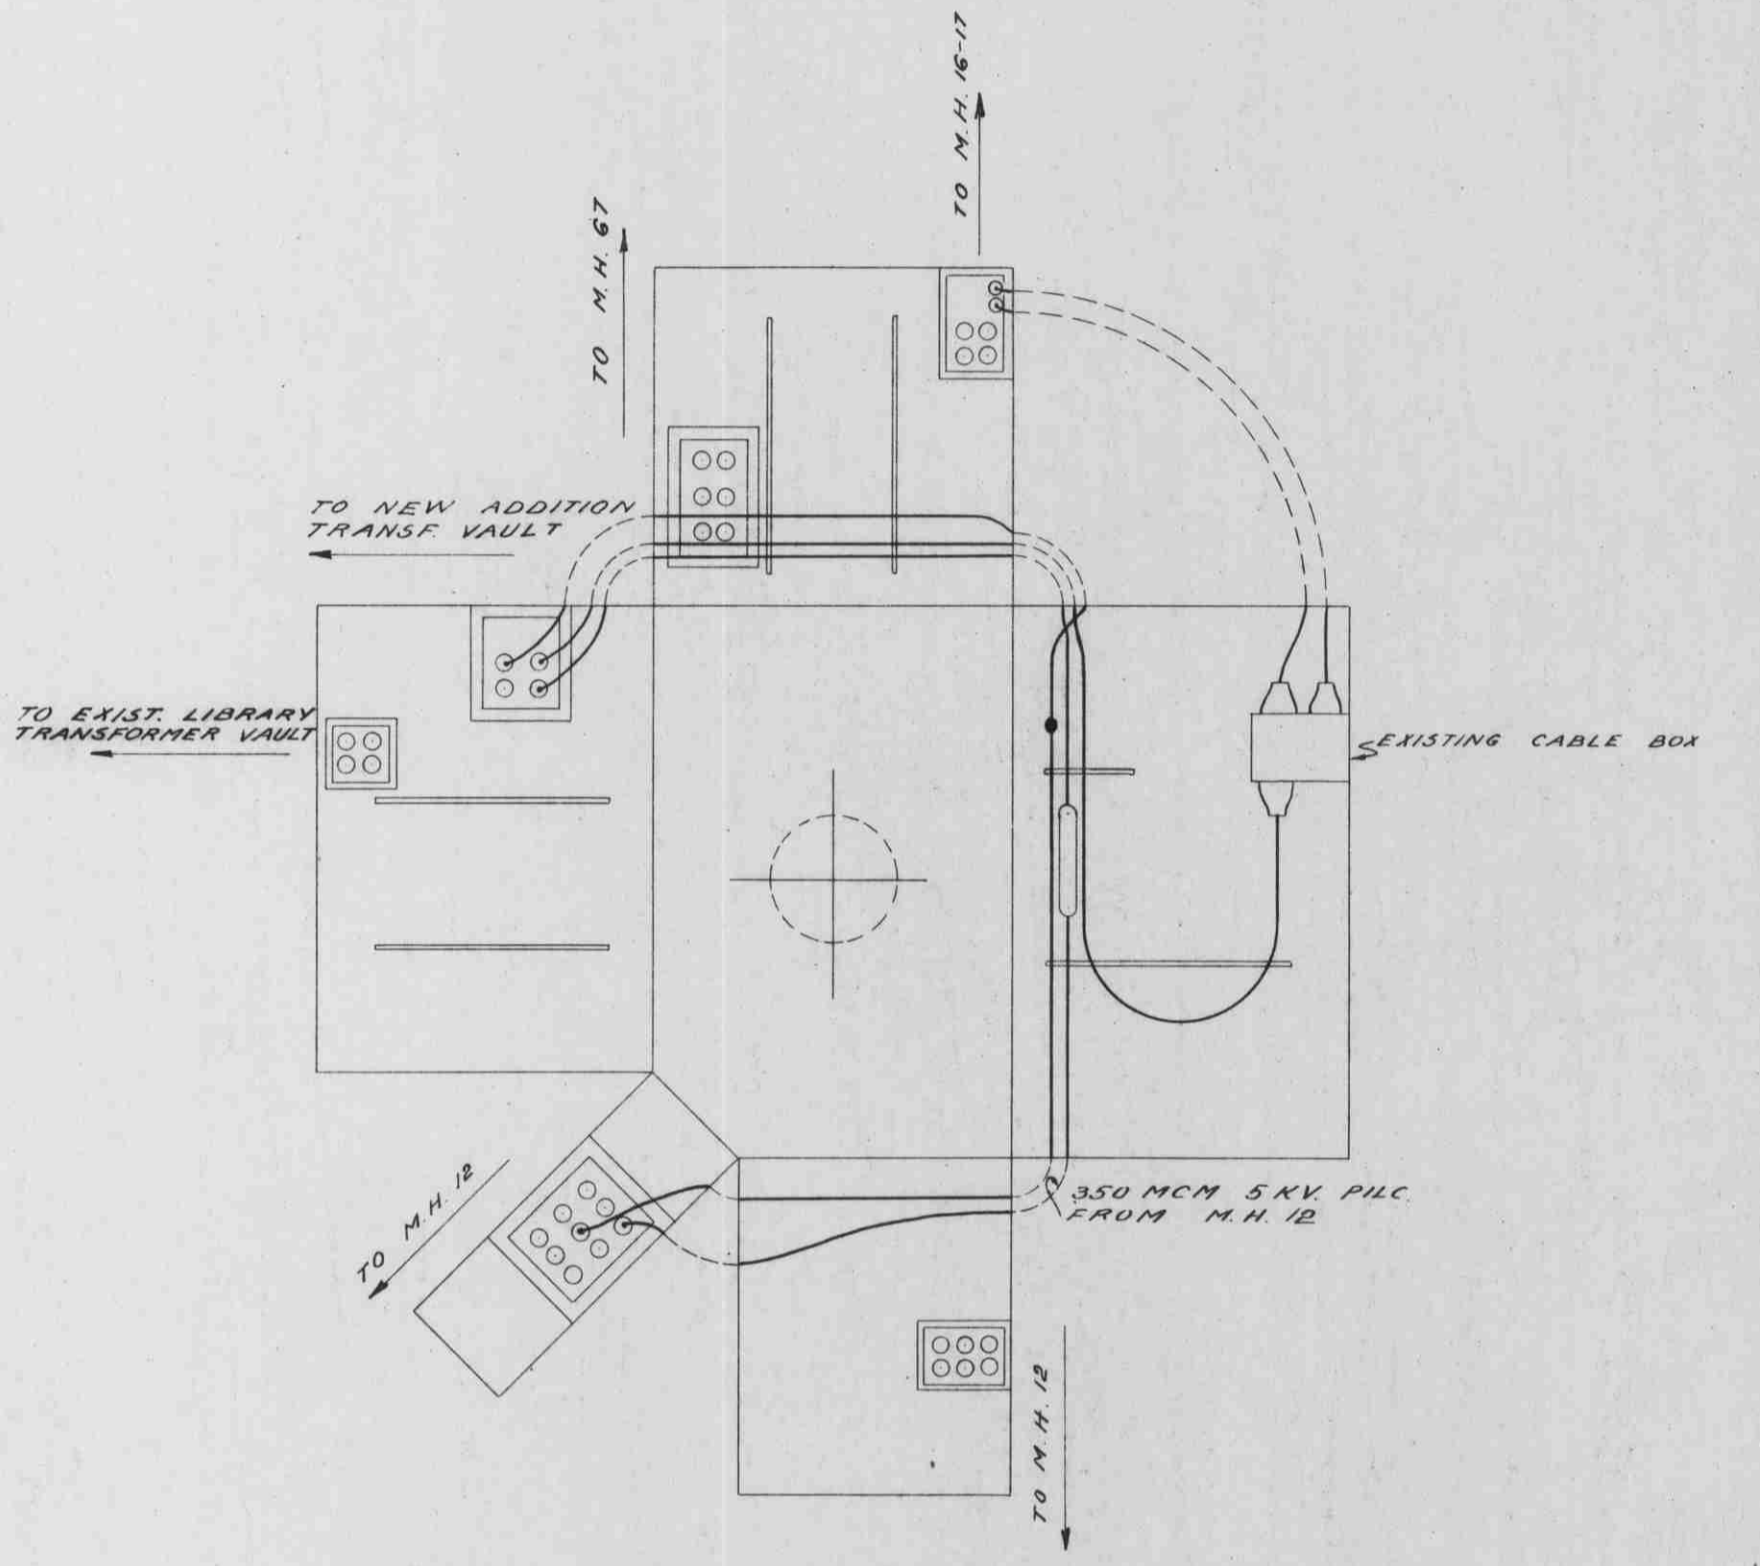


SITE PLAN SCALE: 1" = 30'-0"

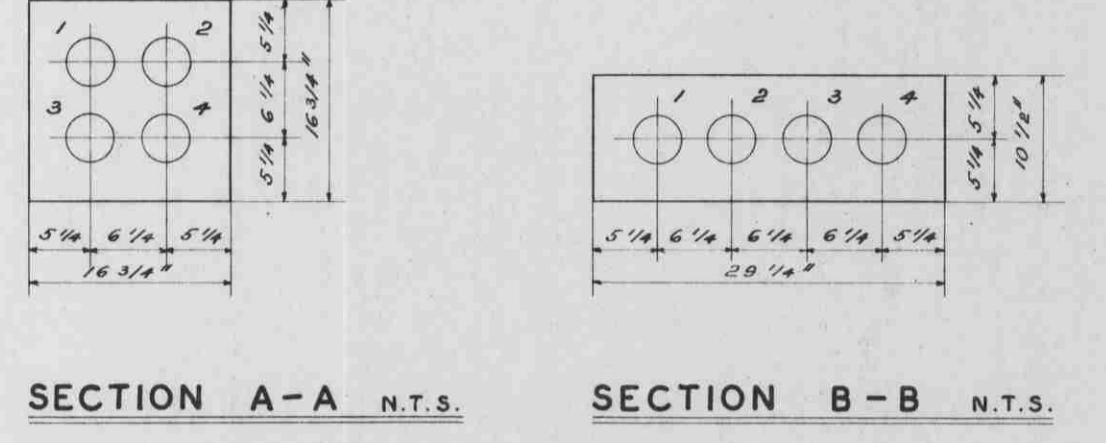

DEVELOPMENT PLAN OF MANHOLE #14 SCALE: 1/4" = 1'-0"

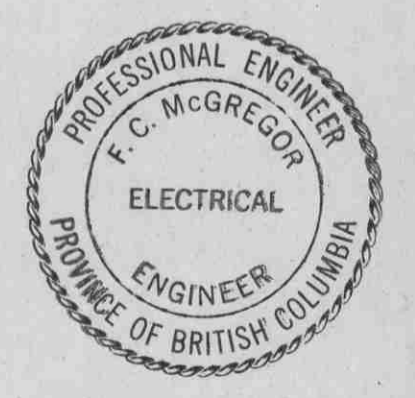

SIMPSON & MCGREGOR CONSULTING ELECTRICAL ENGINEERS VANCOUVER, VICTORIA, B.C.	THOMPSON, BERWICK & PRATT ARCHITECTS 1555 ROBSON ST. VANCOUVER 5, B.C.		ADDITIONS TO THE LIBRARY FOR THE UNIVERSITY OF BRITISH COLUMBIA	JOB NUMBER E-1005
				SHEET NUMBER 6 OF 6
No.	DATE	REVISION	DRAWN, R.V.D.R. CHECKED, S.V. SCALE AS NOTED DATE, MAY 1959.	