




DETAIL OF PIPE ANCHOR IN TRENCH
SCALE: 1/2" = 1'-0"

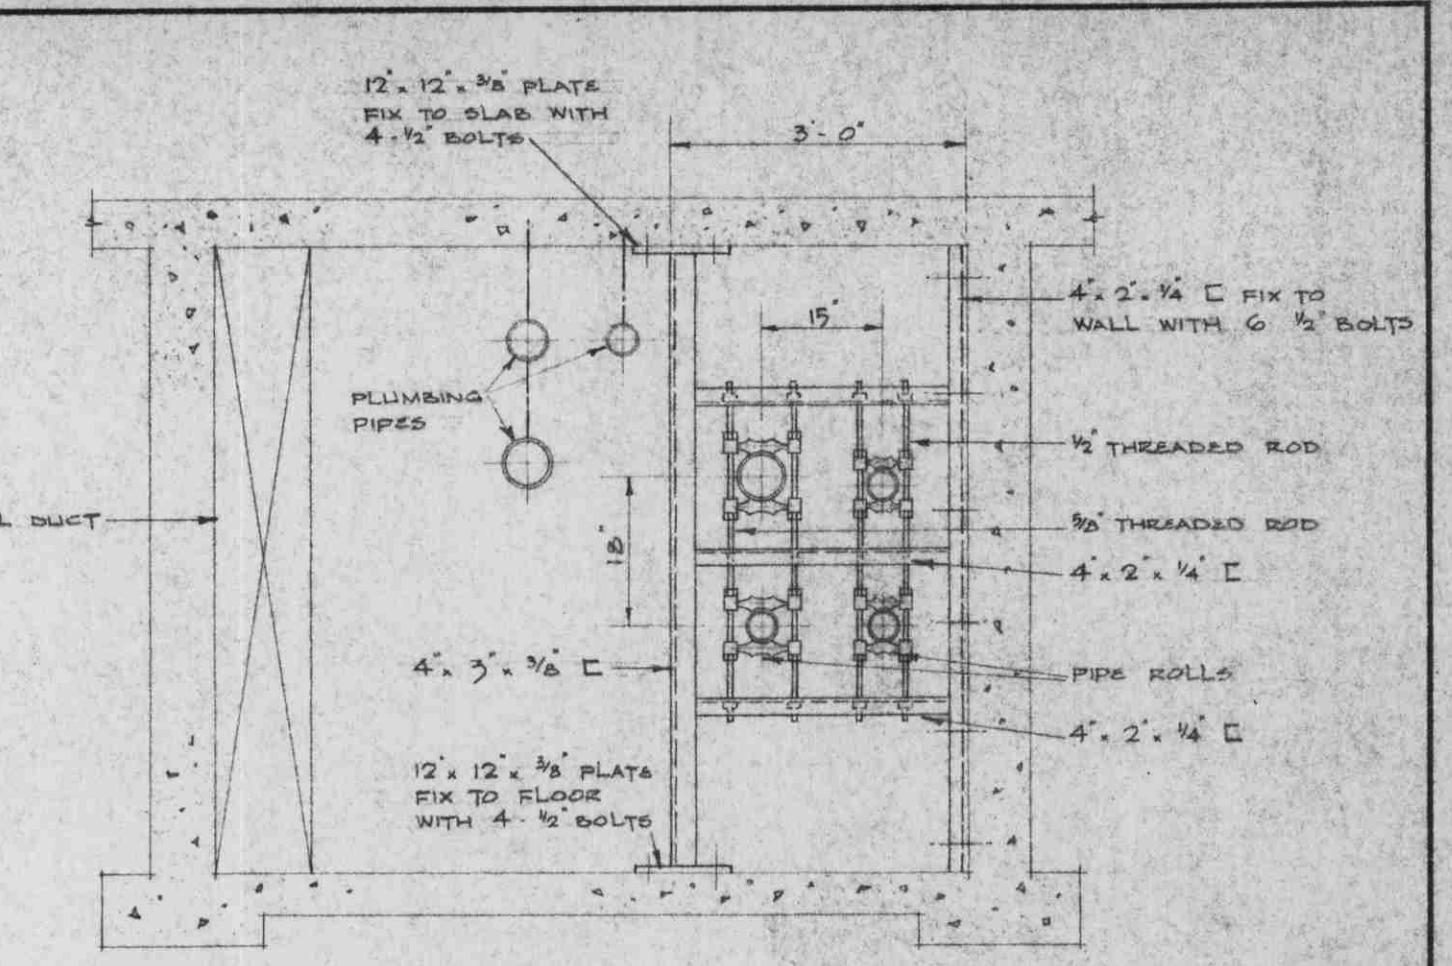

DETAIL OF PIPE GUIDES IN TRENCH
SCALE: 1/2" = 1'-0"

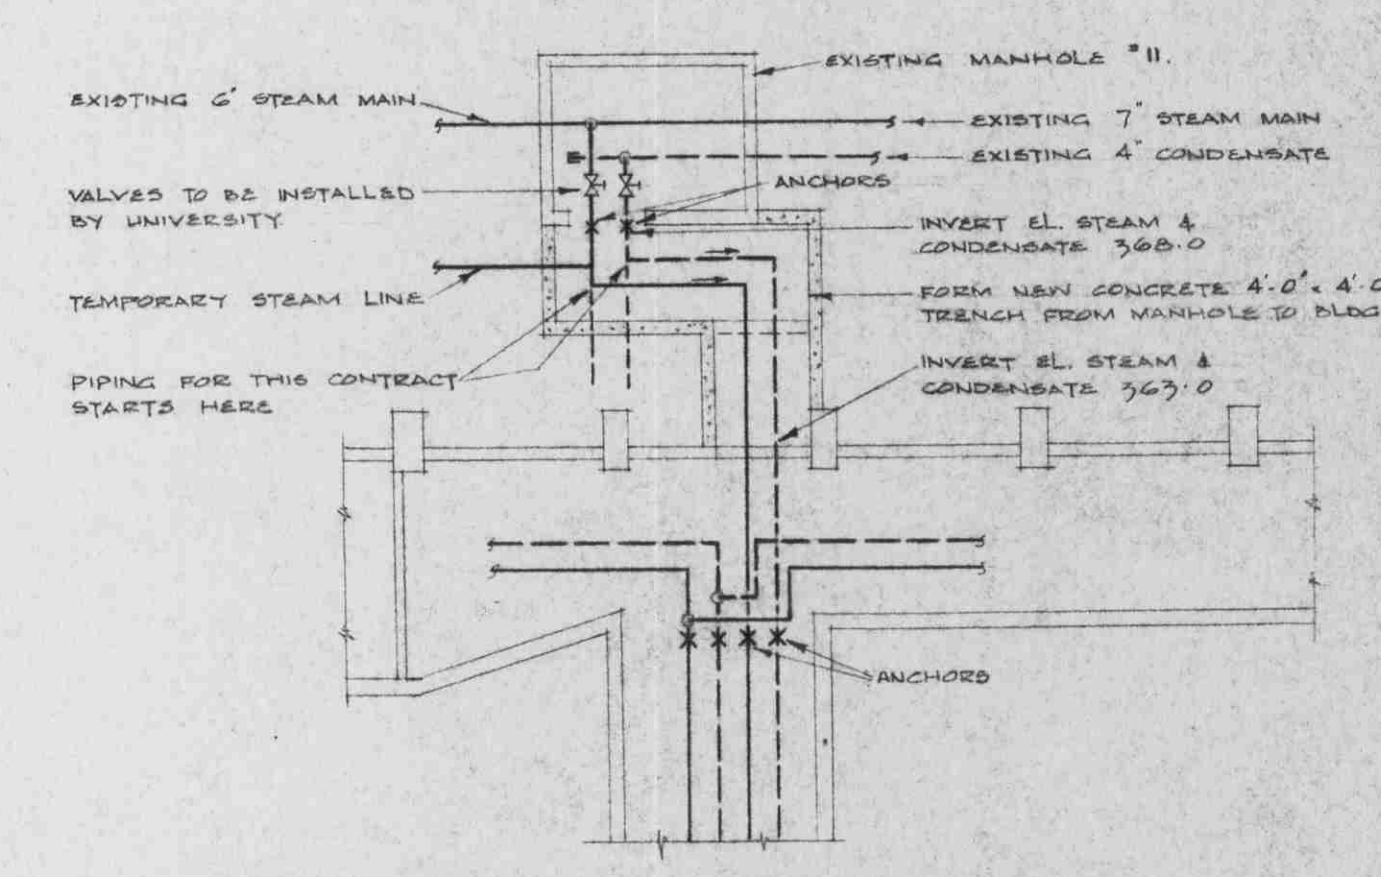

PLAN OF STEAM ENTRY
SCALE: 1/8" = 1'-0"

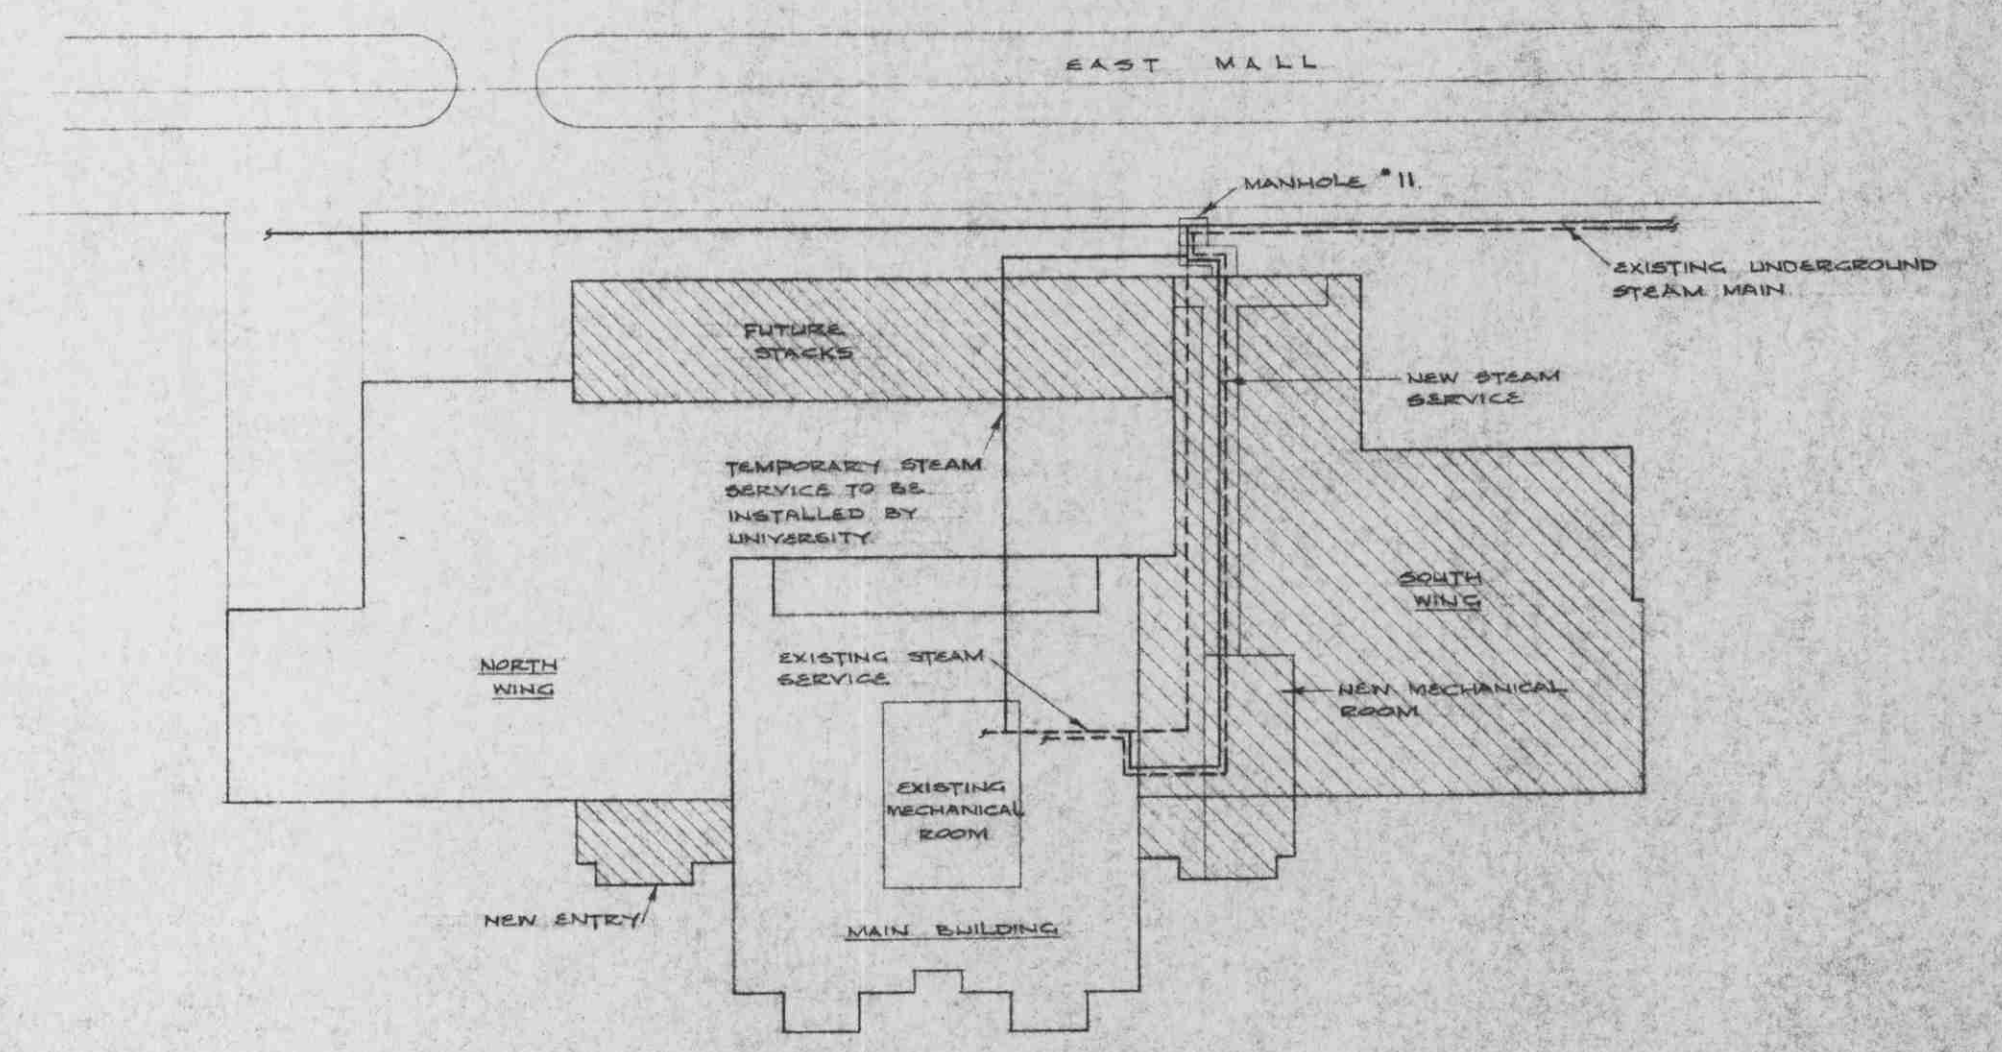

PLOT PLAN
SCALE: 1" = 50'-0"

FOUNDATION PLAN STACK LEVEL # 1.		HEATING & VENTILATING		JOB No. 1287.
D. W. THOMSON & COMPANY LTD. CONSULTING MECHANICAL ENGINEERS 1690 WEST BROADWAY VANCOUVER 9, B.C.		THOMPSON, BERWICK & PRATT ARCHITECTS 1555 ROBSON ST. VANCOUVER 5, B. C.		SHEET No. M - 1 OF
No.	DATE	REVISION	DRAWN: J.H.C. CHECKED: R.L.R. SCALE: 1/8" = 1'-0" DATE: 15th MAY '59.	