




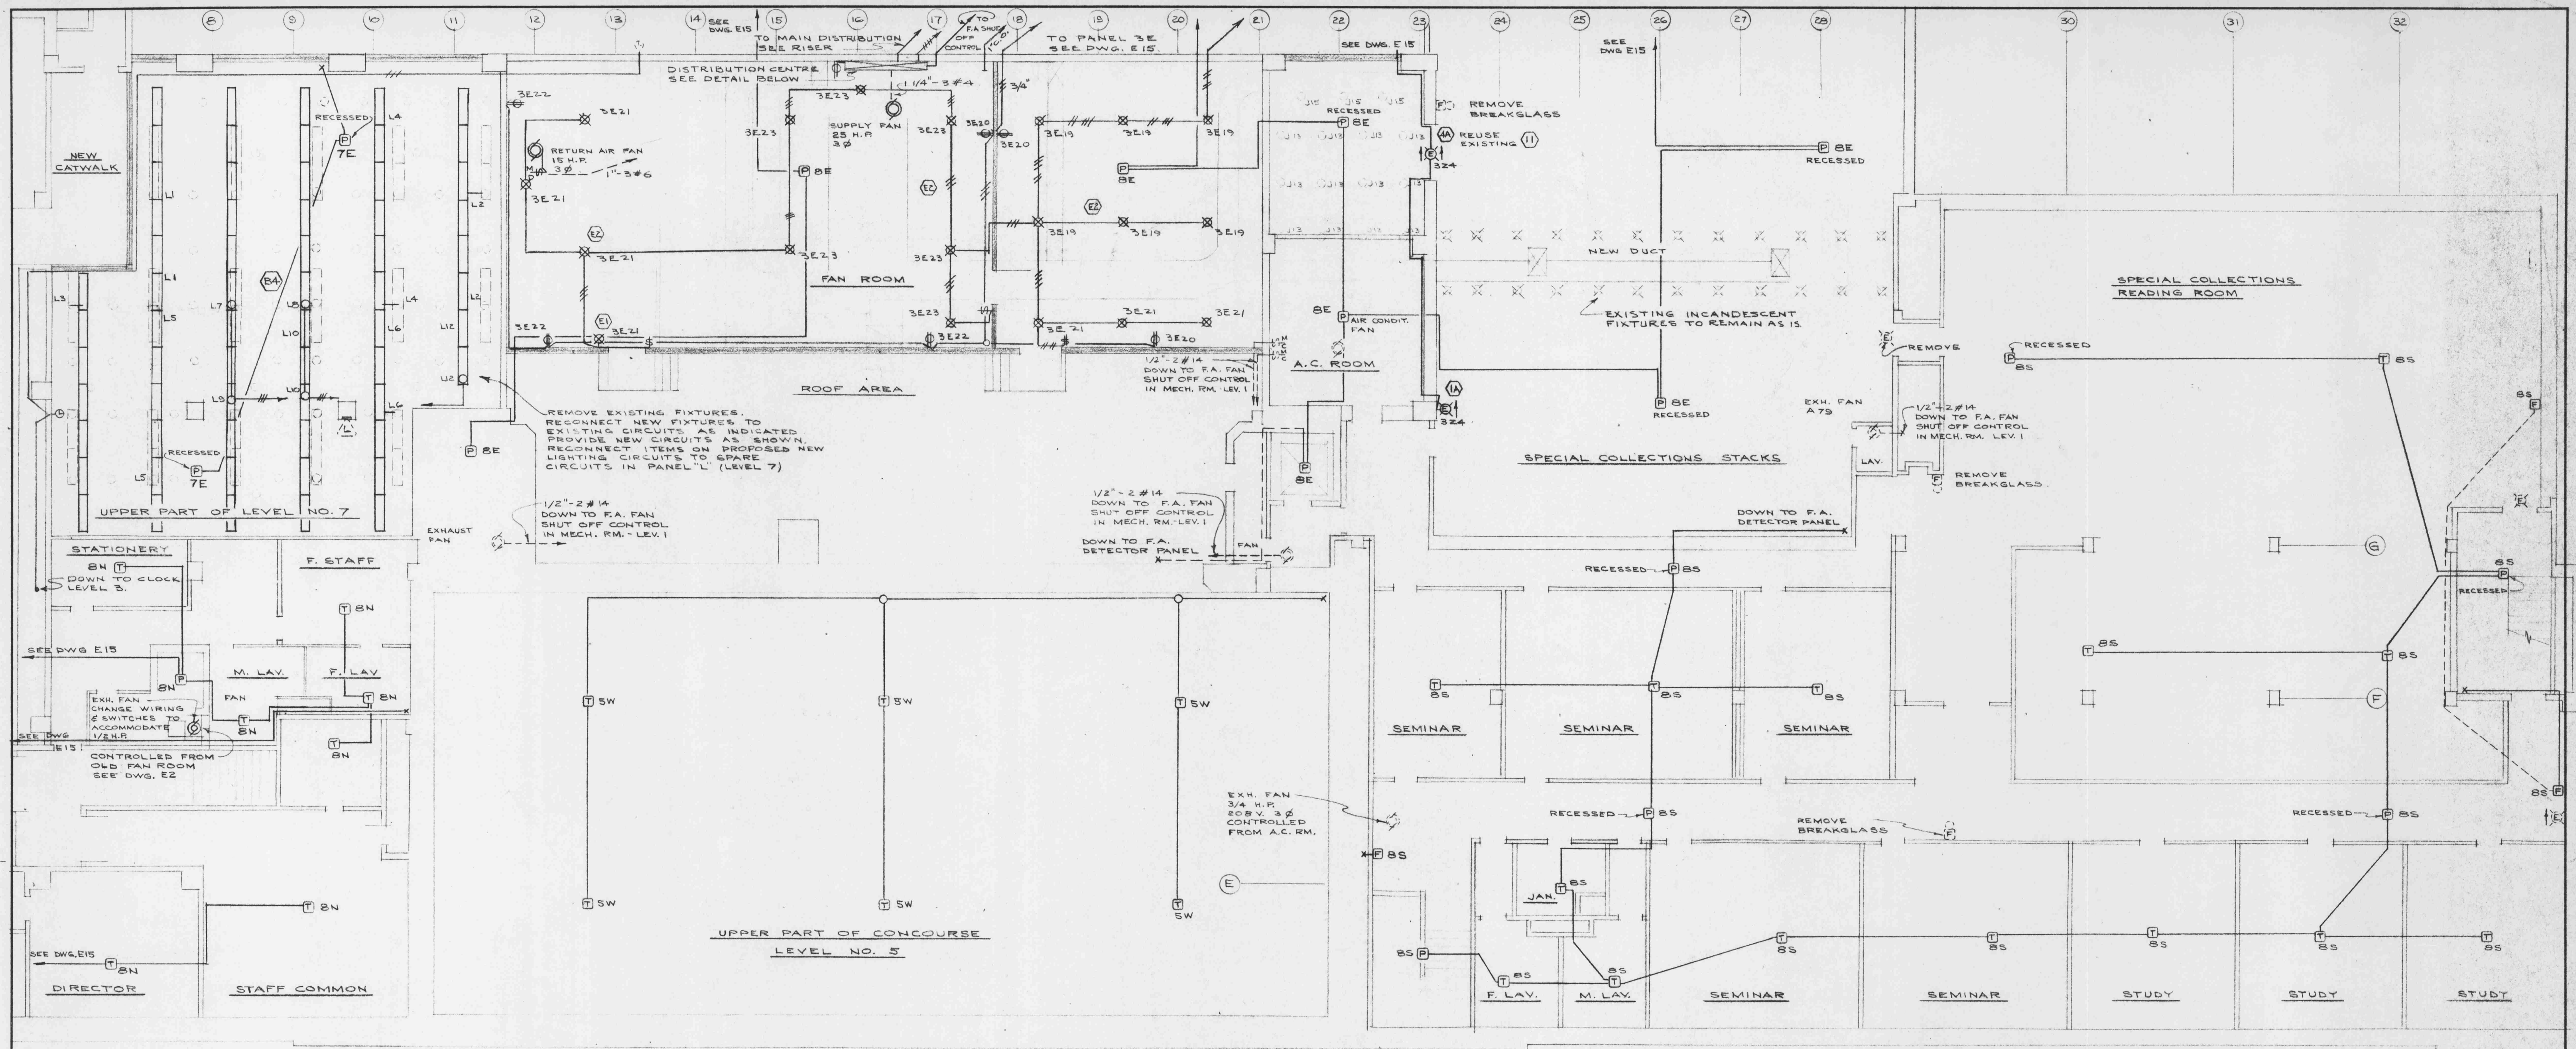

FLOOR PLAN - LEVEL NO. 8 S.W.
SCALE: 1/8" = 1'-0"

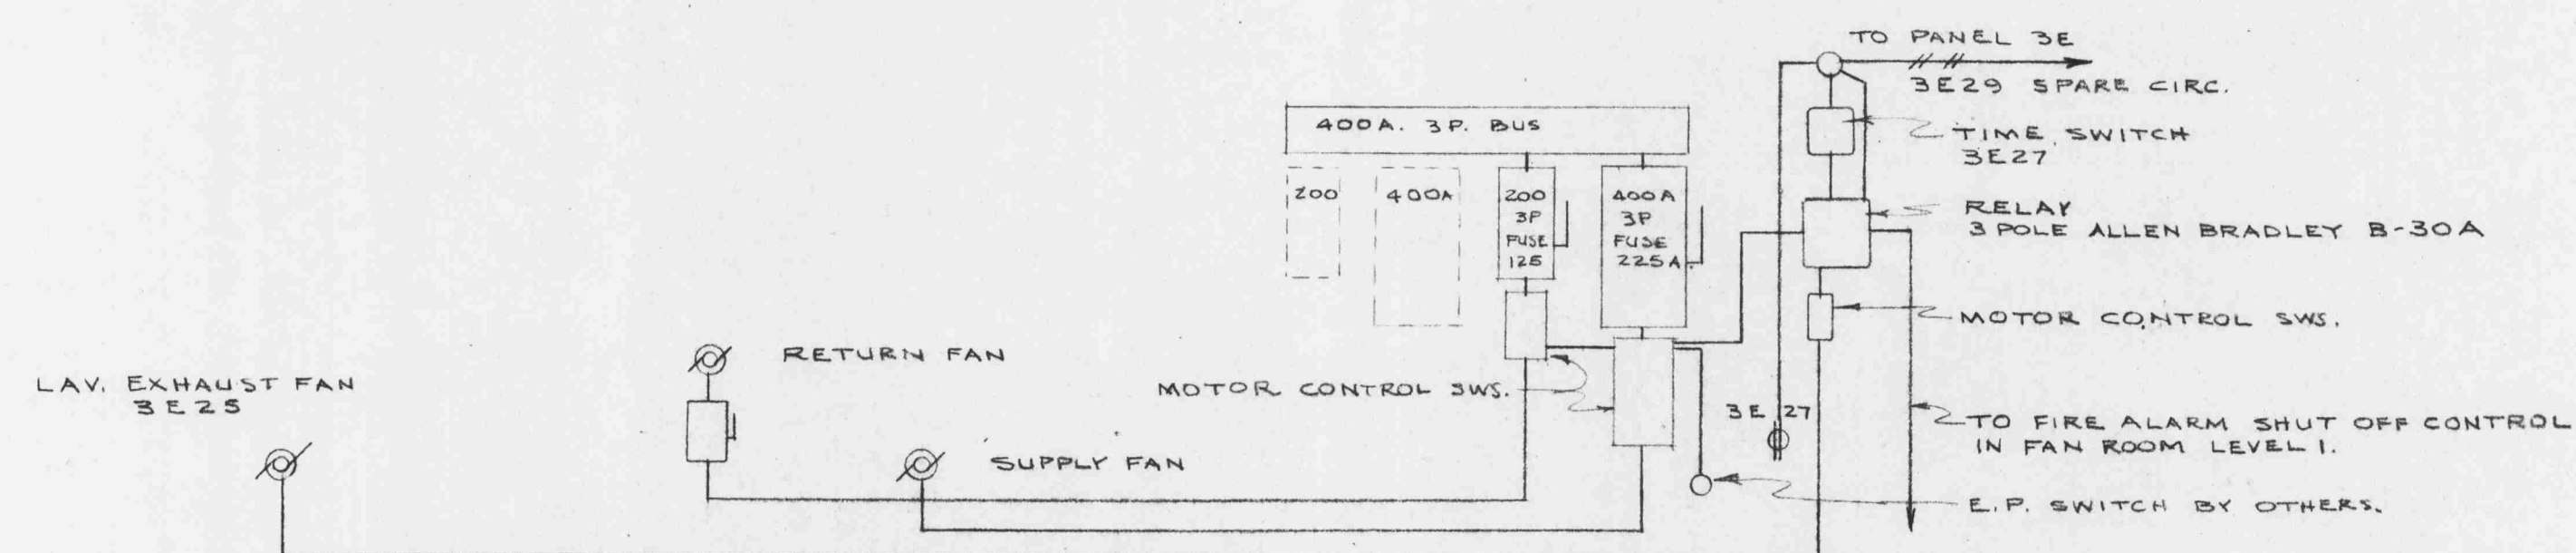

FAN ROOM DISTRIBUTION
NOT TO SCALE

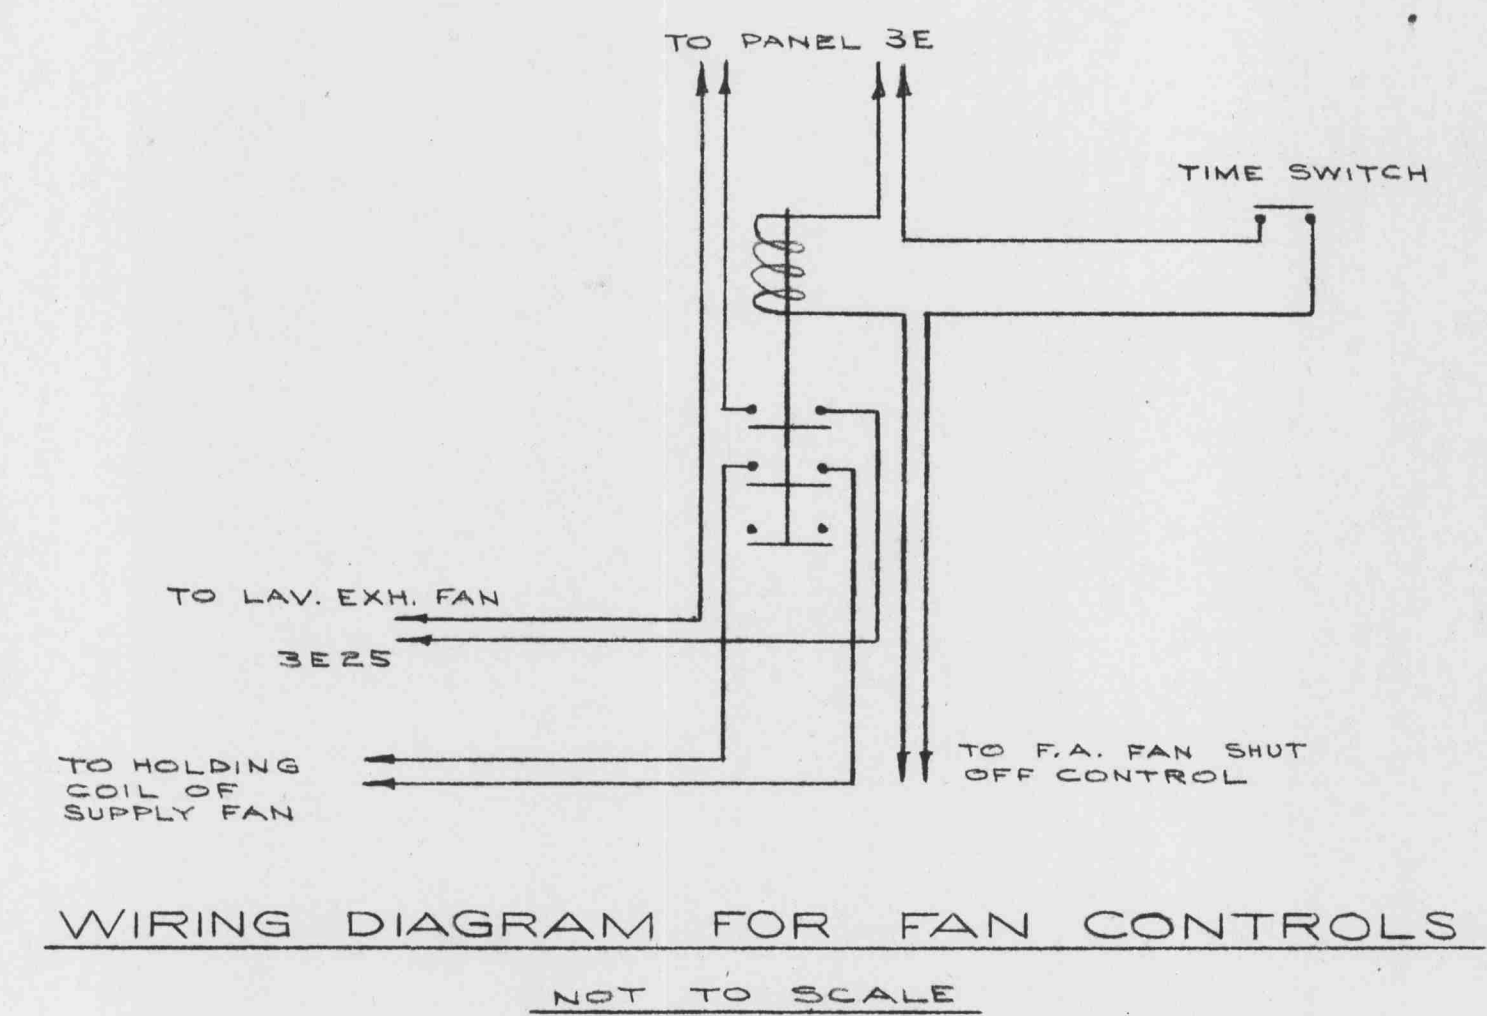

WIRING DIAGRAM FOR FAN CONTROLS
NOT TO SCALE

ELECTRICAL		ALTERATIONS TO THE LIBRARY UNIVERSITY OF BRITISH COLUMBIA		JOB No.
R. M. CAMPBELL P. ENG. ELECTRICAL ENGINEER 1770 WEST GEORGIA ST. VANCOUVER, B. C.		STACK LEVEL #8 S.W.		DATE
DATE MARCH 31, 1964	SCALE AS NOTED	TOBY, RUSSELL & BUCKWELL		DRAWN A.D.R.
JOB No. 685	SHEET No. E.16 OF 16	ARCHITECTS - VANCOUVER, B.C.		CHECKED
				DRAWING No. E.16 OF 16