


ARCHITECTS.
SHARP AND THOMPSON, A.S.R.I.B.A.
626 PENDER ST., - VANCOUVER, B.C.

UNIVERSITY of BRITISH COLUMBIA
LIBRARY BUILDING.
HEATING AND VENTILATING.
SCALE 1/4" = 1'-0"

CONSULTING ENGINEERS
LEEK & CO., LTD.
1090 HOMER ST., - VANCOUVER, B.C.

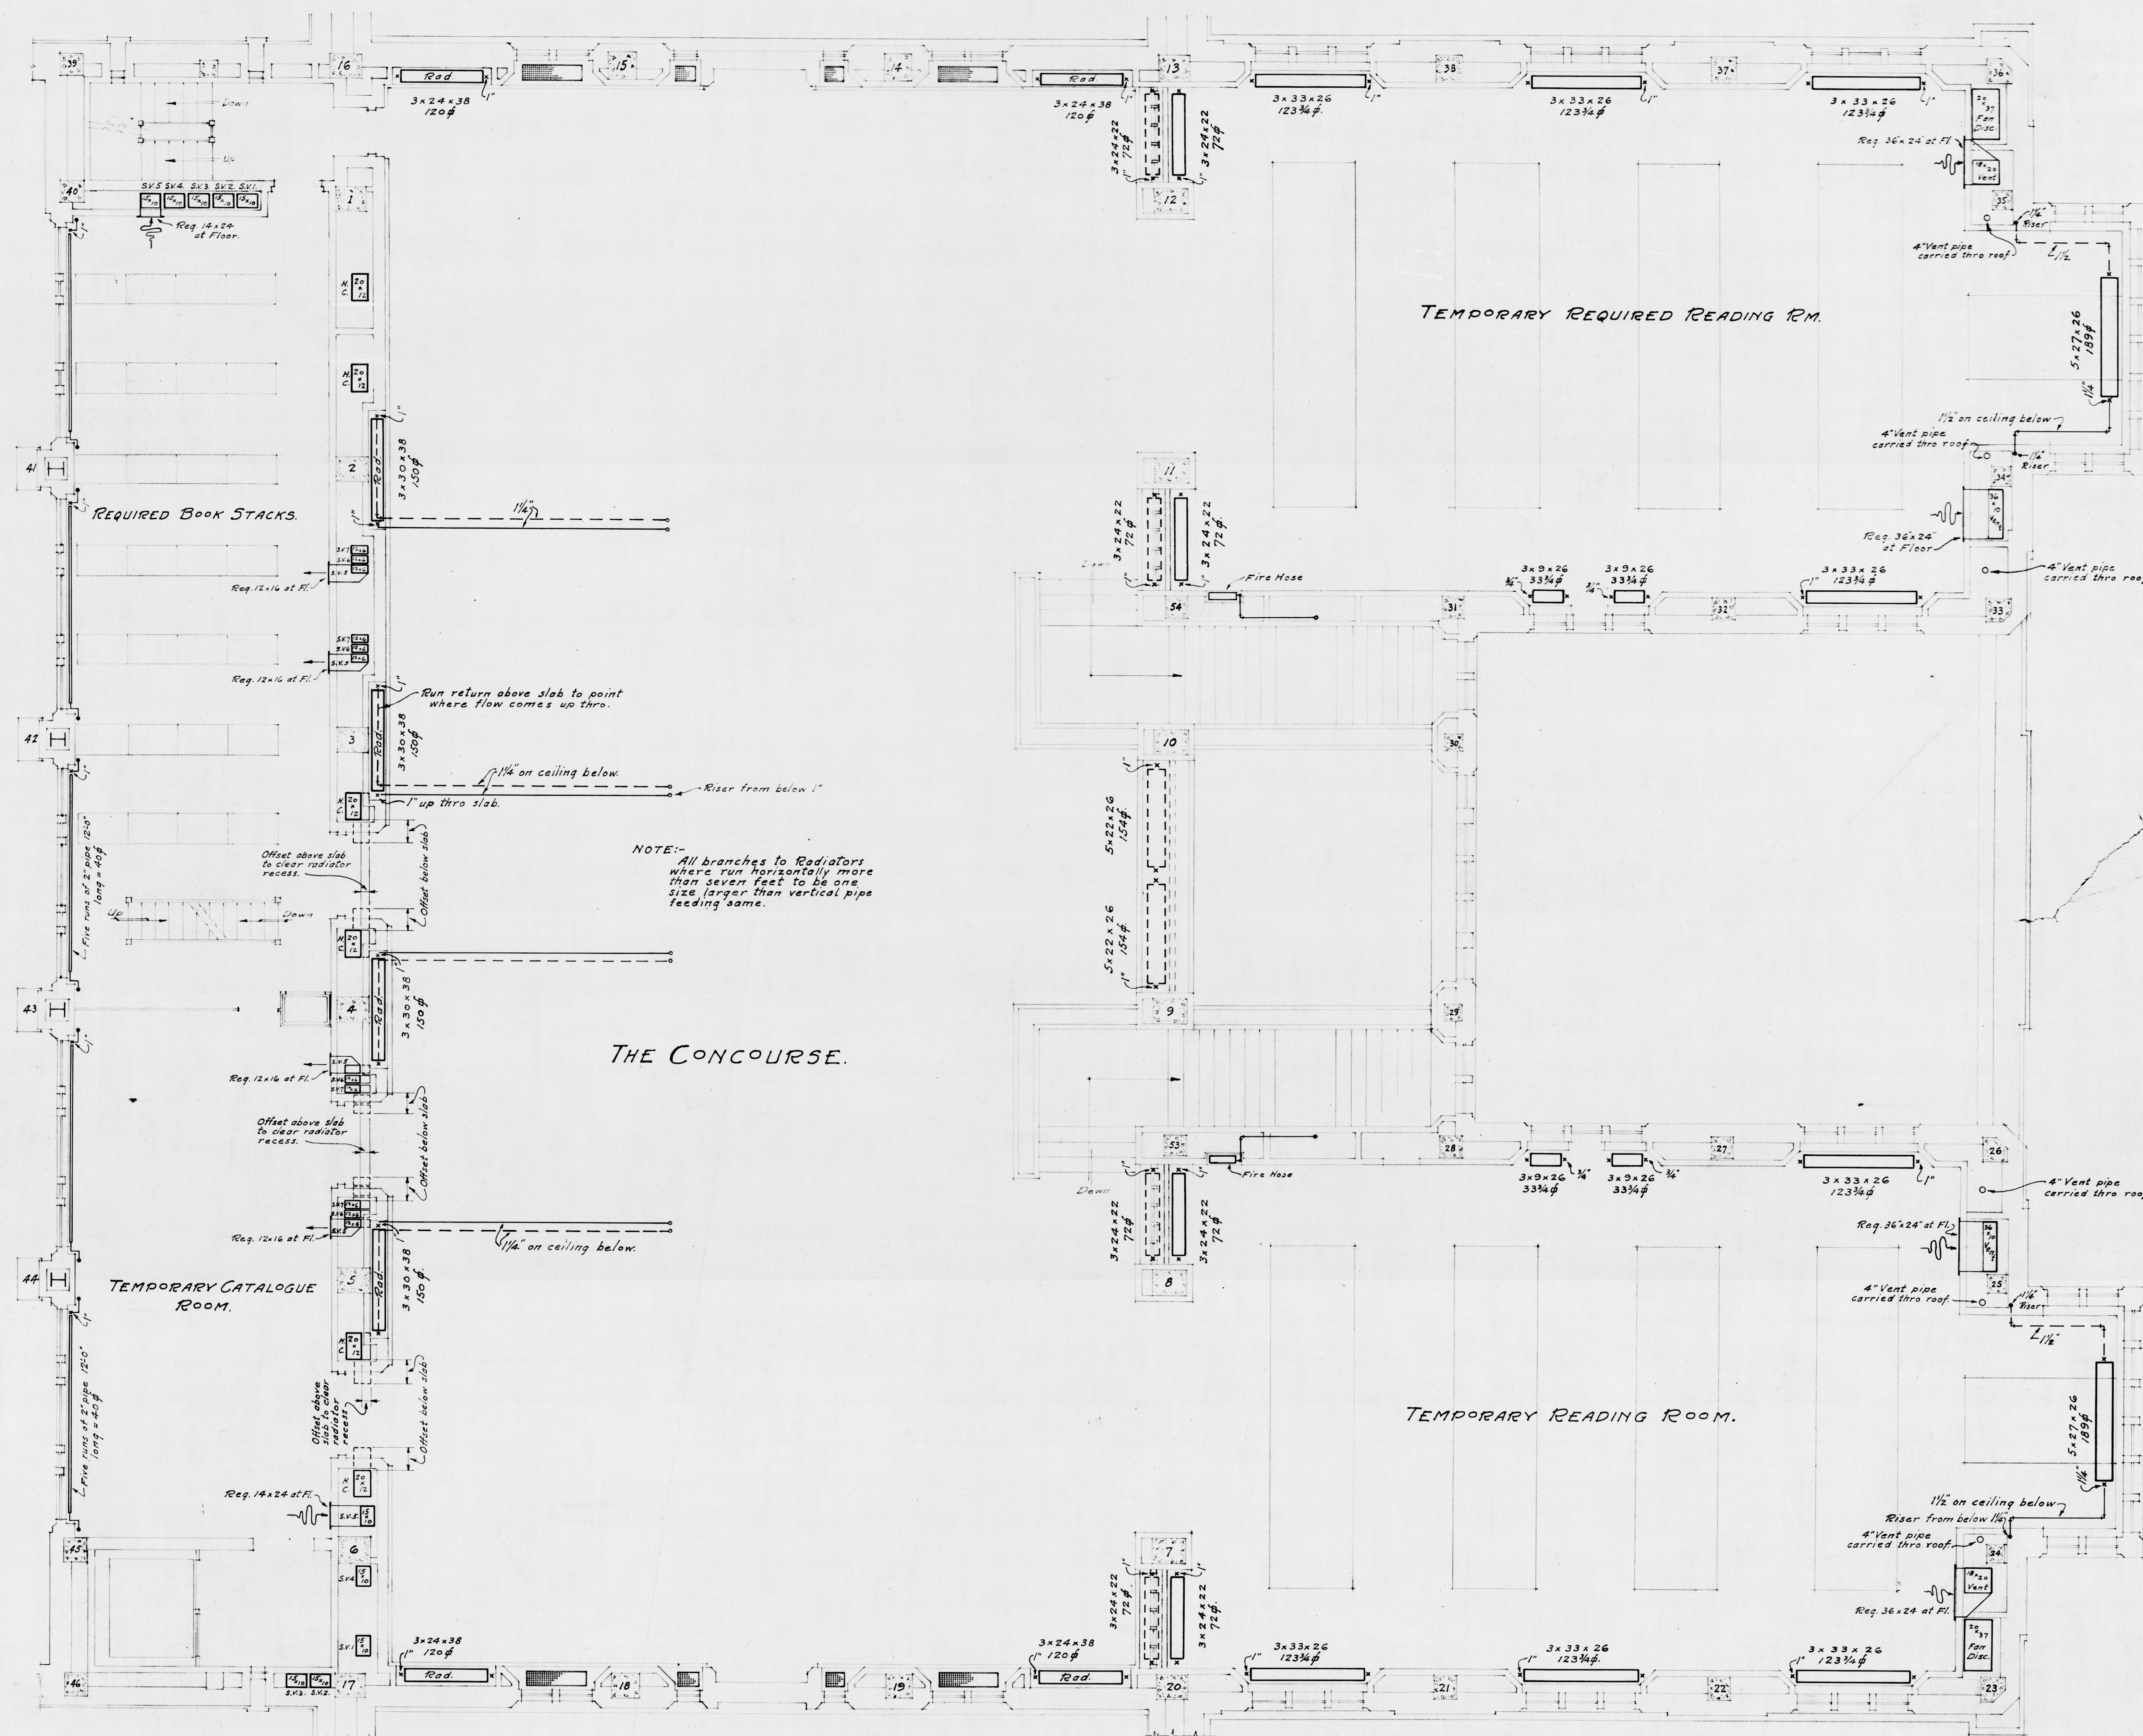

MAIN CONCOURSE FLOOR PLAN.