


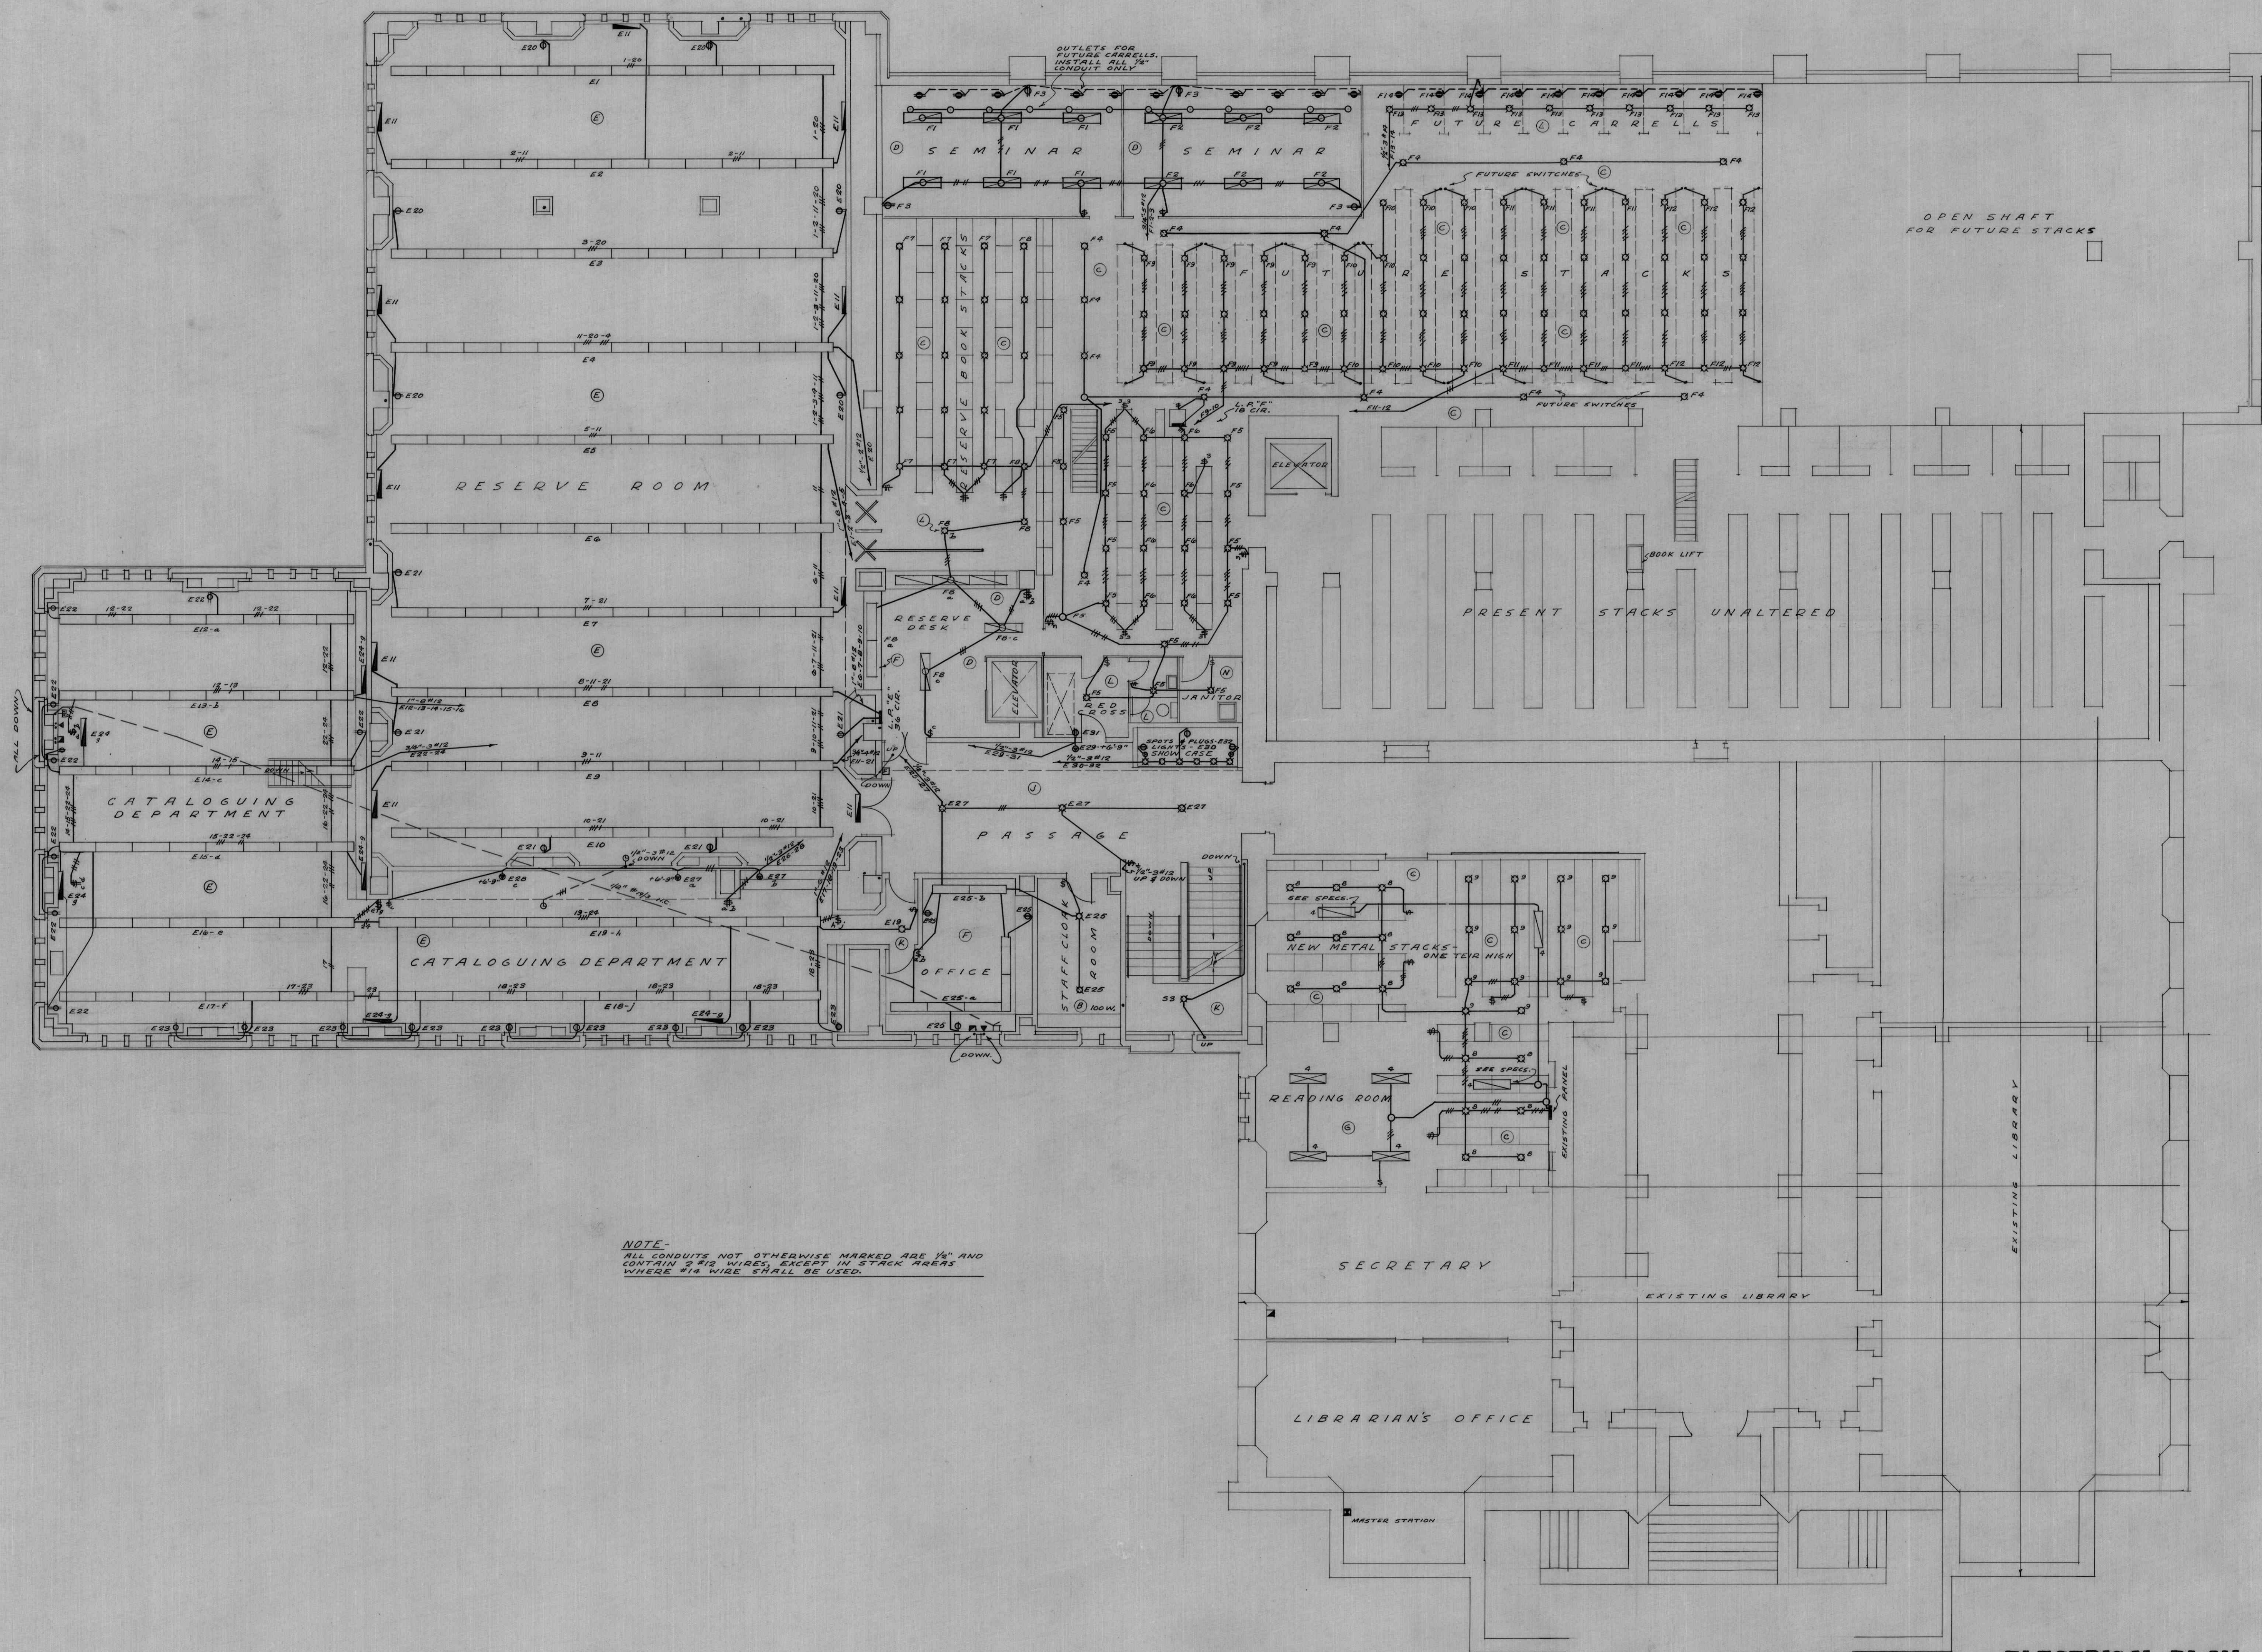

NOTE-
ALL CONDUITS NOT OTHERWISE MARKED ARE 1/2" AND
CONTAIN 2 #12 WIRES, EXCEPT IN STACK AREAS
WHERE #14 WIRE SHALL BE USED.

ELECTRICAL PLAN
MAIN ENTRANCE FLOOR
STACK LEVEL NO. 3

REVISION DATE 16 JULY 1947	ADDITION TO LIBRARY		SCALE 1/8" = 1'-0"
	UNIVERSITY OF B.C.		DATE 25 JULY, 1946
	A. EDWARD SIMPSON ELECTRICAL ENGINEER VANCOUVER, B.C.	SHARP & THOMPSON ARCHITECTS VANCOUVER, B.C.	DRAWING NO. U2-5-3