

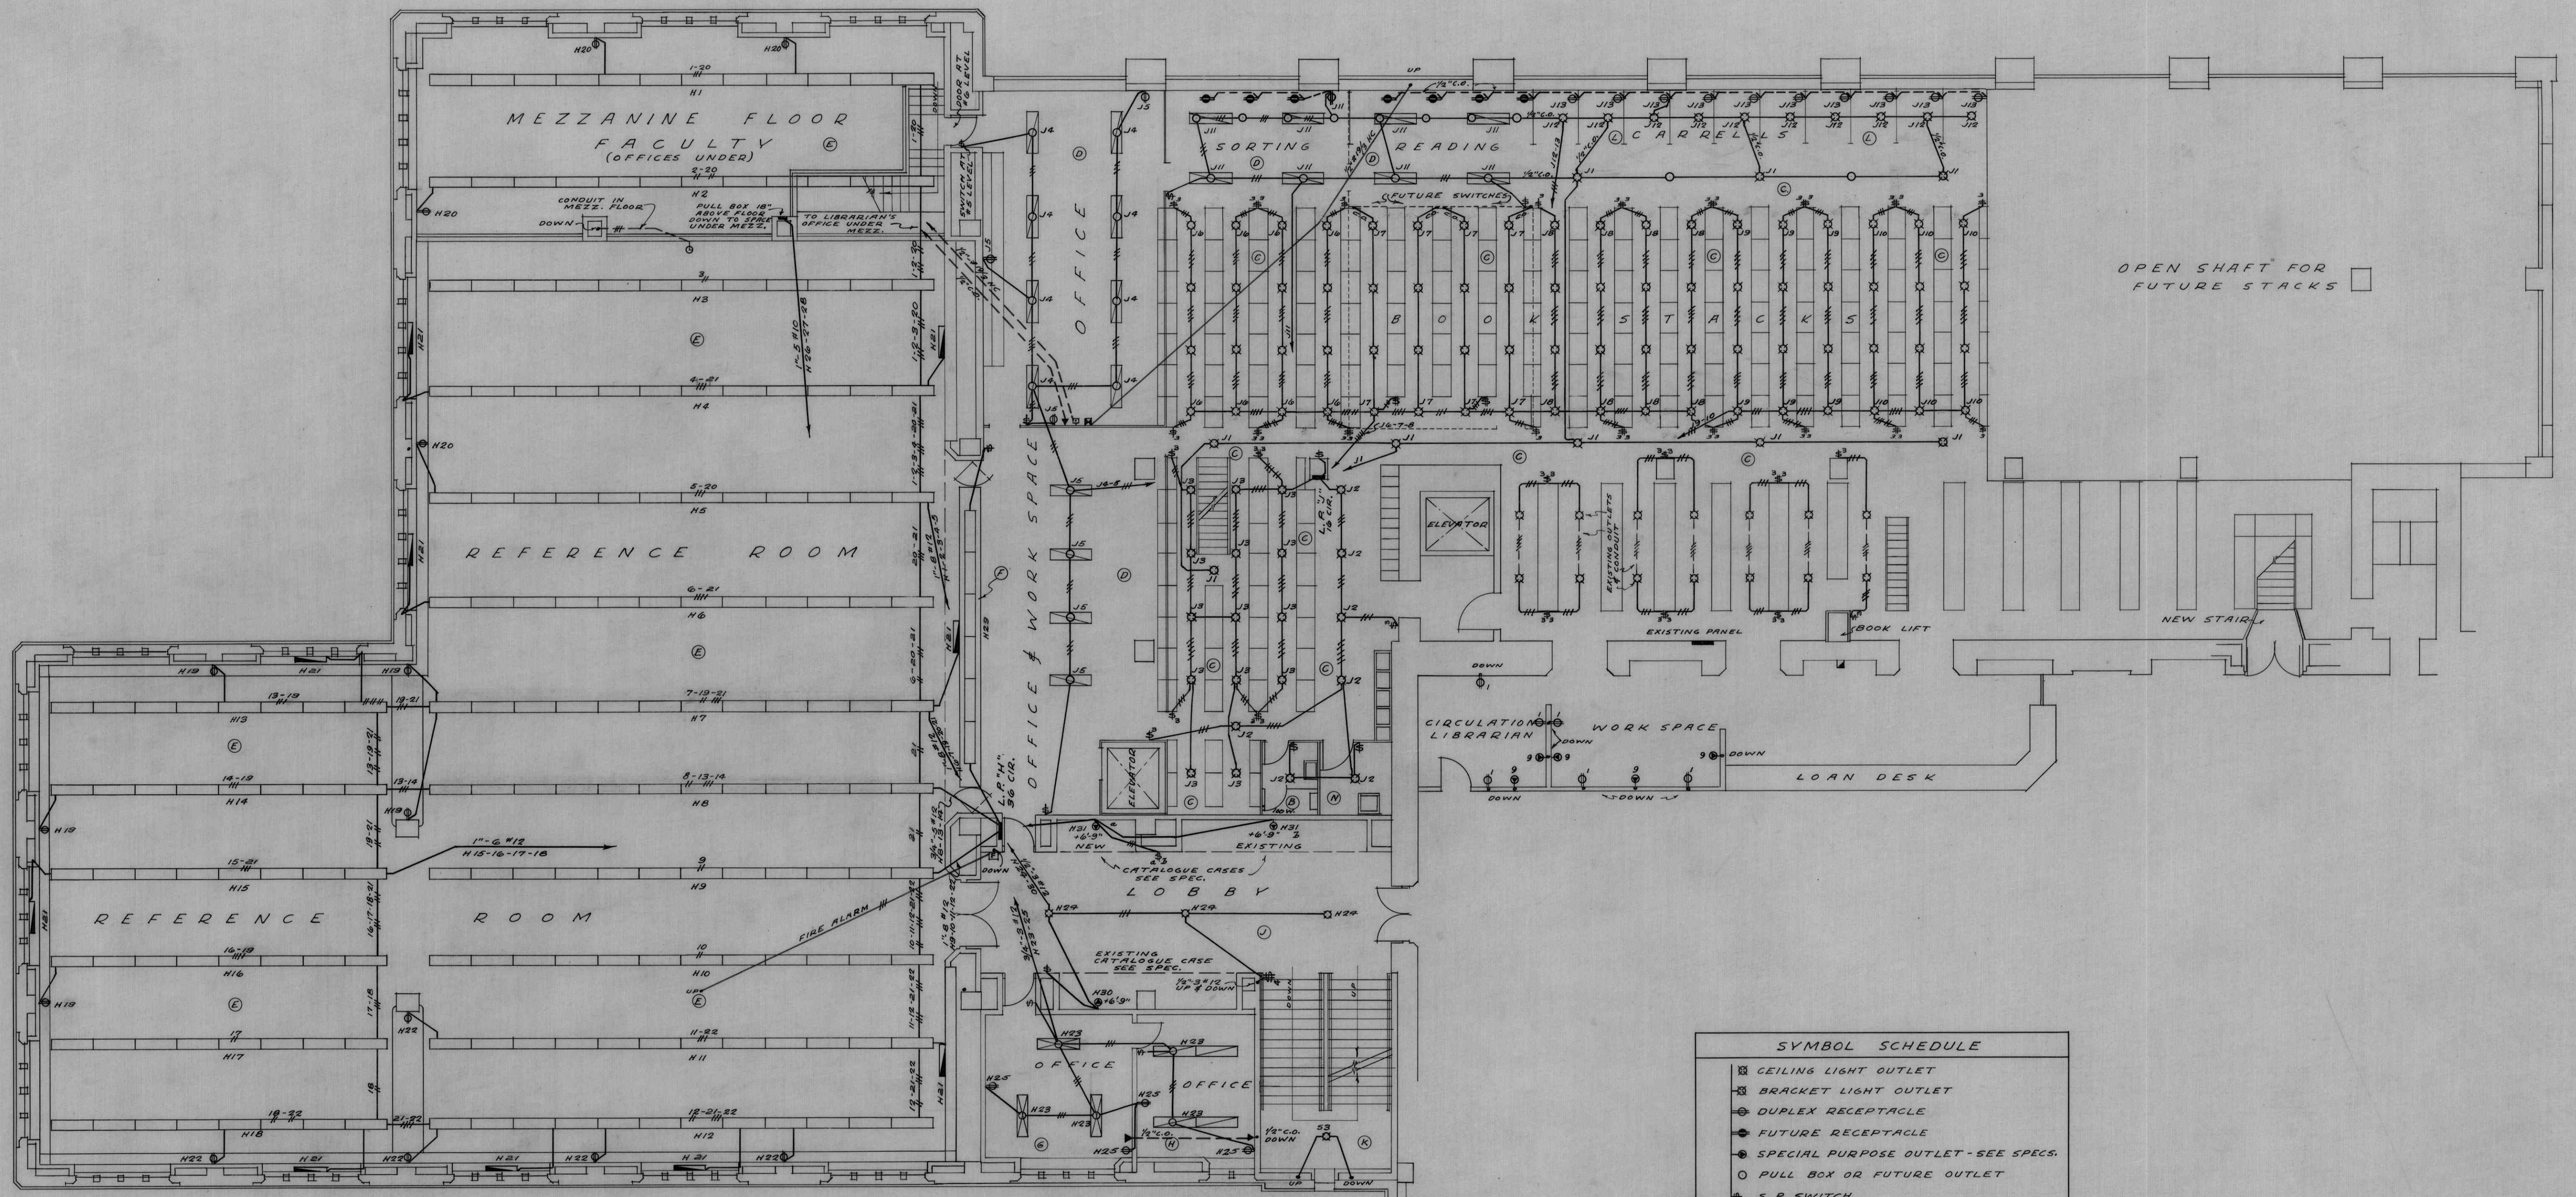


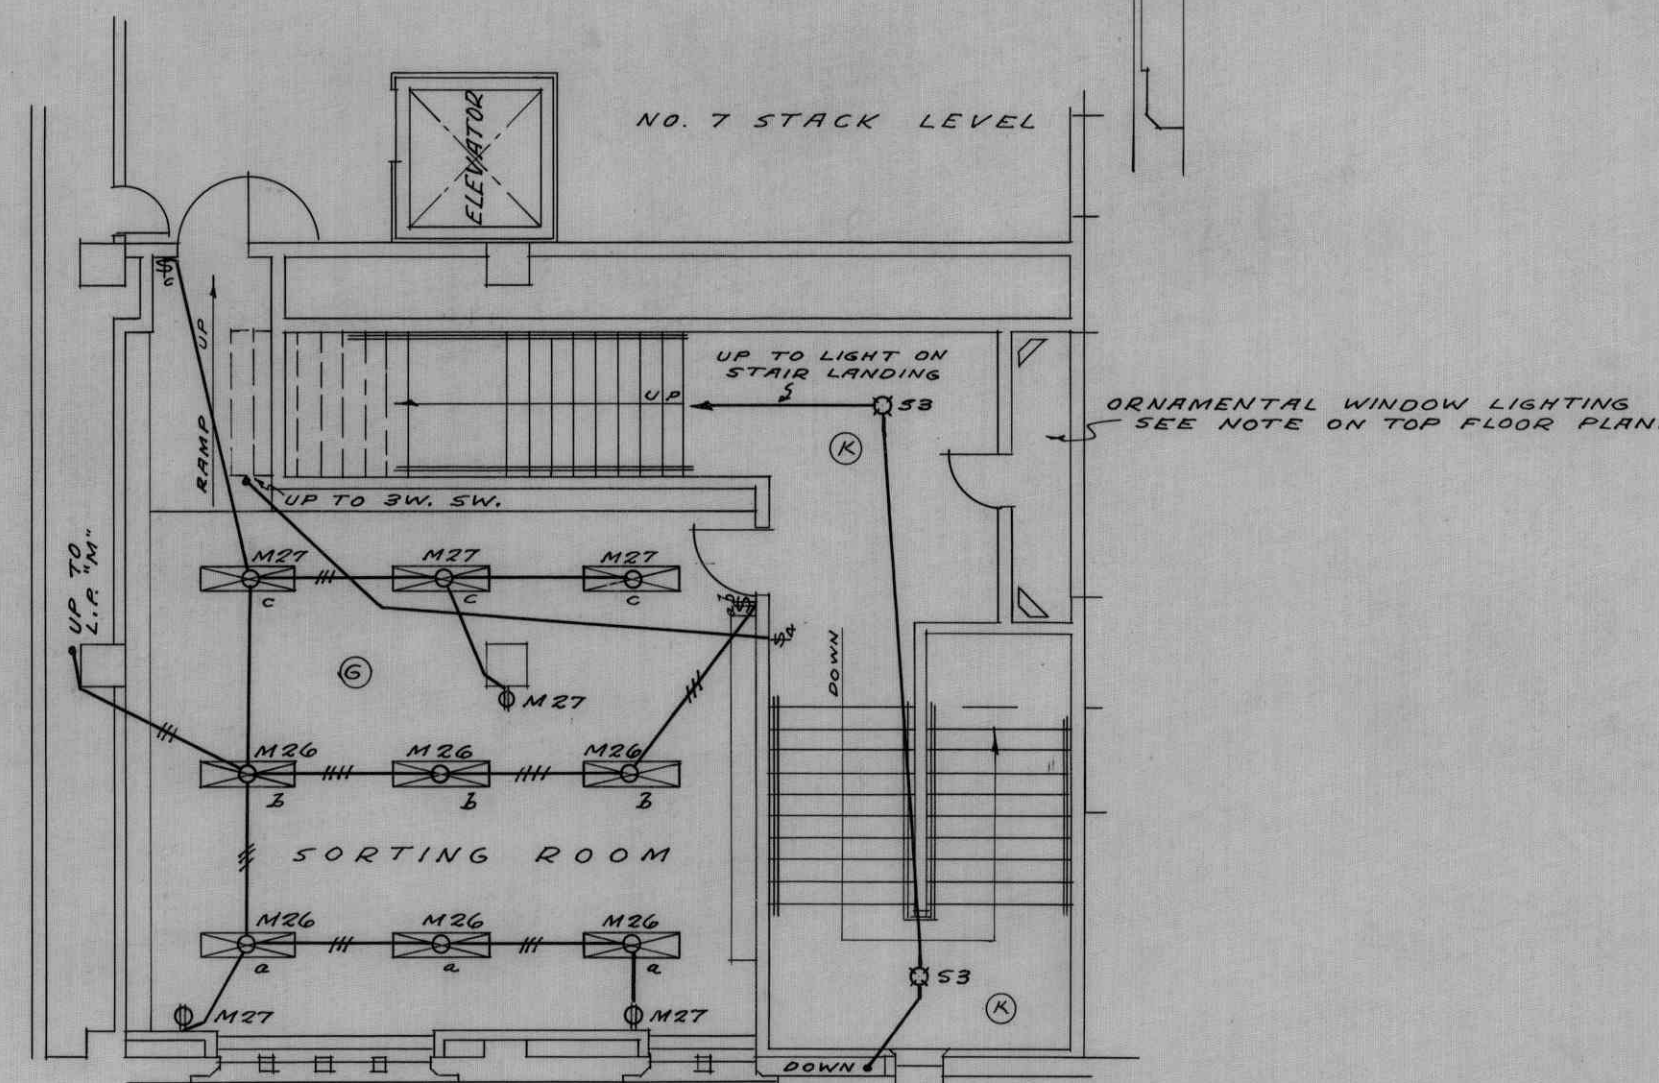

SYMBOL SCHEDULE	
	CEILING LIGHT OUTLET
	BRACKET LIGHT OUTLET
	DUPLEX RECEPTACLE
	FUTURE RECEPTACLE
	SPECIAL PURPOSE OUTLET-SEE SPEC.
	PULL BOX OR FUTURE OUTLET
	S.A. SWITCH
	3 WAY SWITCH
	4 WAY SWITCH
	BELL TRANSFORMER
	BUZZER
	PUSH BUTTON
	MAGNAPHONE-MASTER STATION
	MAGNAPHONE-SUB STATION
	TELEPHONE OUTLET
	SECONDARY CLOCK
	FIRE ALARM STATION
	MOTOR
	FLUSH FLOOR. FIXTURE - 1/2" w.
	SURFACE FLOOR. FIXTURE - 1/2" w.
	SURFACE FLOOR. FIXTURE - 1/2" w.
	GERMICIDAL FIXTURE
	CONDUIT IN CEILING
	CONDUIT IN FLOOR

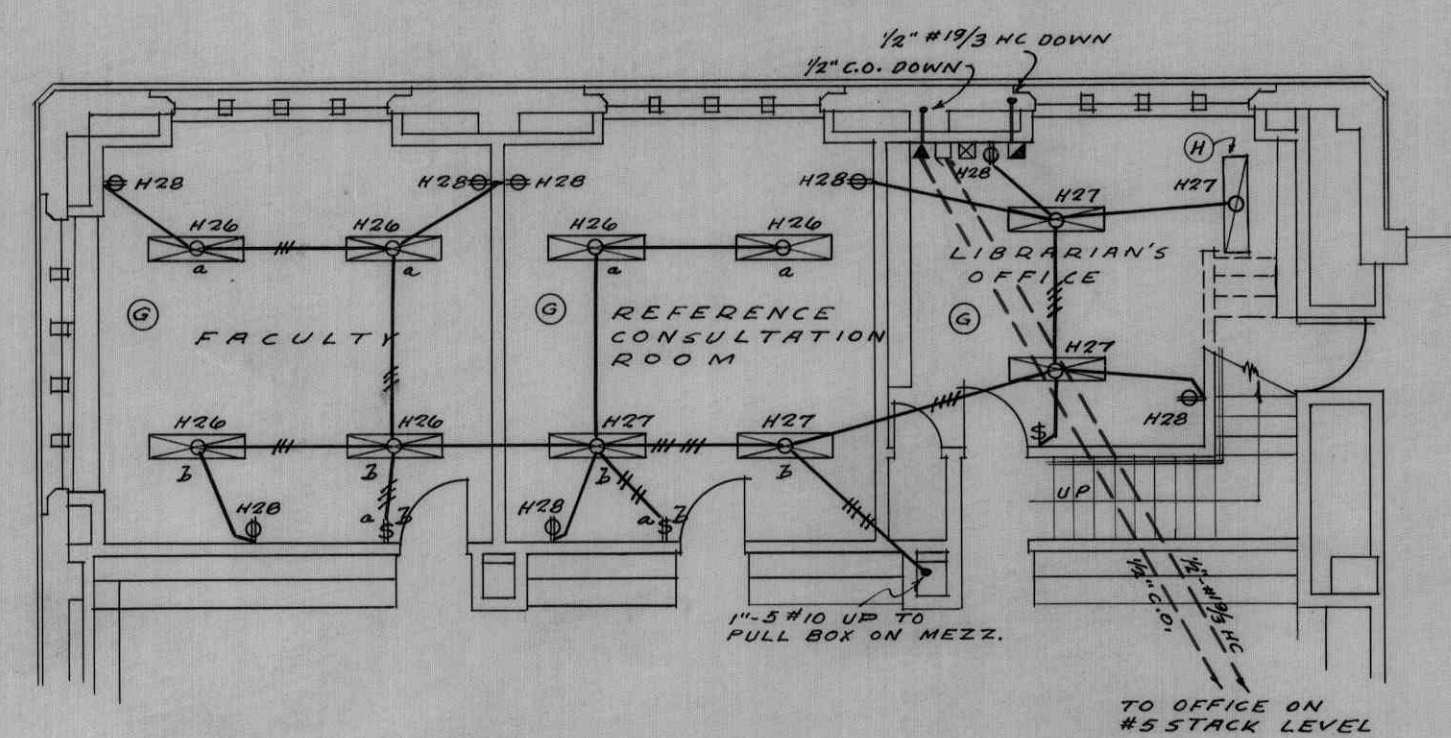

NOTE-
ALL CONDUITS NOT OTHERWISE MARKED ARE
1/2" AND CONTAIN 2 #12 WIRES EXCEPT IN
STACK AREAS WHERE #14 IS USED.

ELECTRICAL PLAN
MAIN CONCOURSE FLOOR
STACK LEVEL NO. 5

REVISION DATE	ADDITION TO LIBRARY		SCALE
28 JULY 1947	UNIVERSITY OF B.C.		1/8" = 1'-0"
	A. EDWARD SIMPSON ELECTRICAL ENGINEER VANCOUVER, B.C.	SHARP & THOMPSON ARCHITECTS VANCOUVER, B.C.	DATE 25 JULY, 1946
			DRAWING NO. U2-5-5