




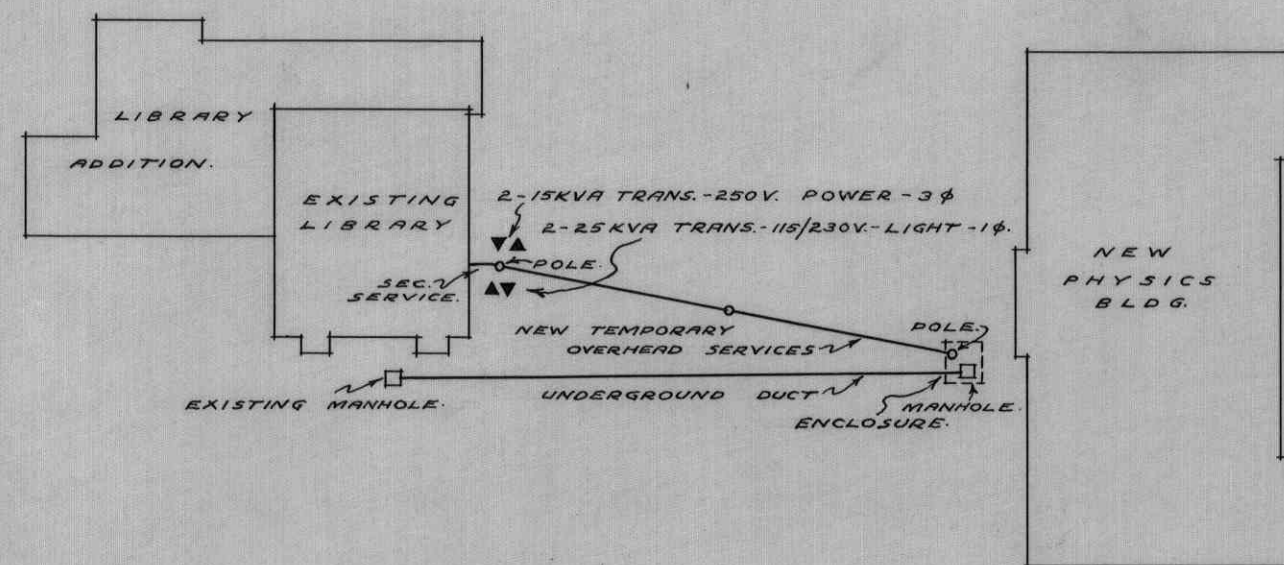


SITE PLAN
SCALE - 1"=100'

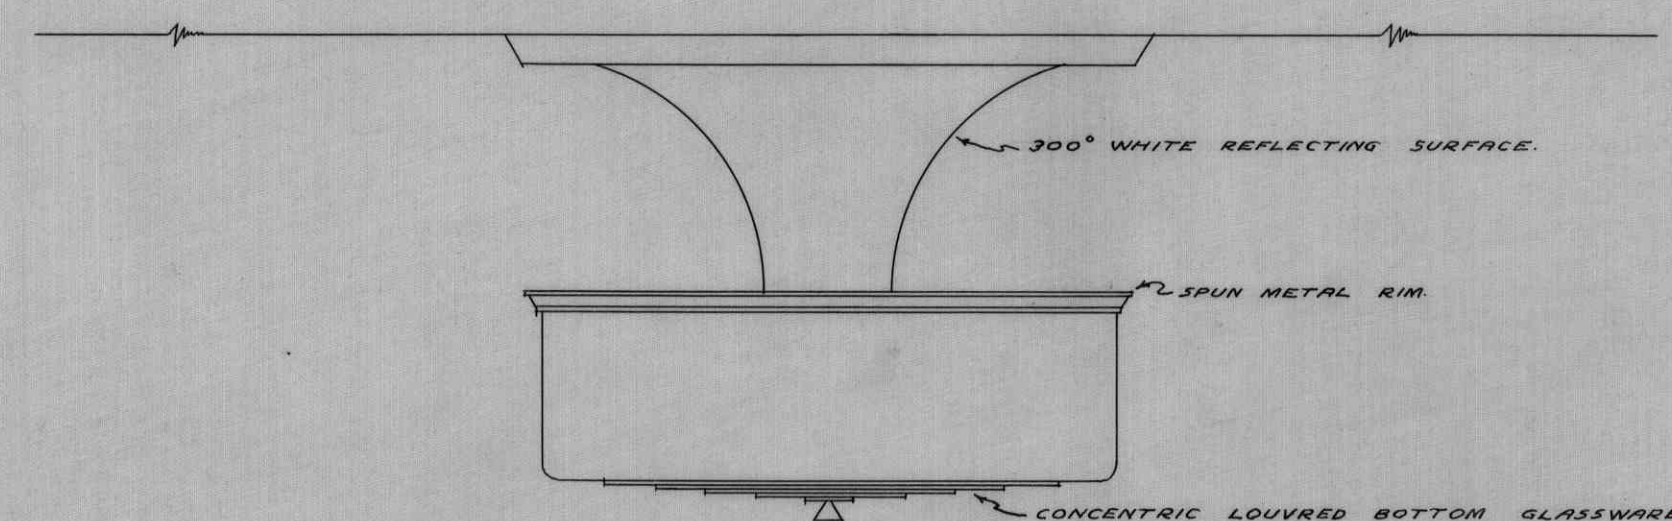

TYPE J" FIXTURE DETAIL
SCALE - 1/4"=1"

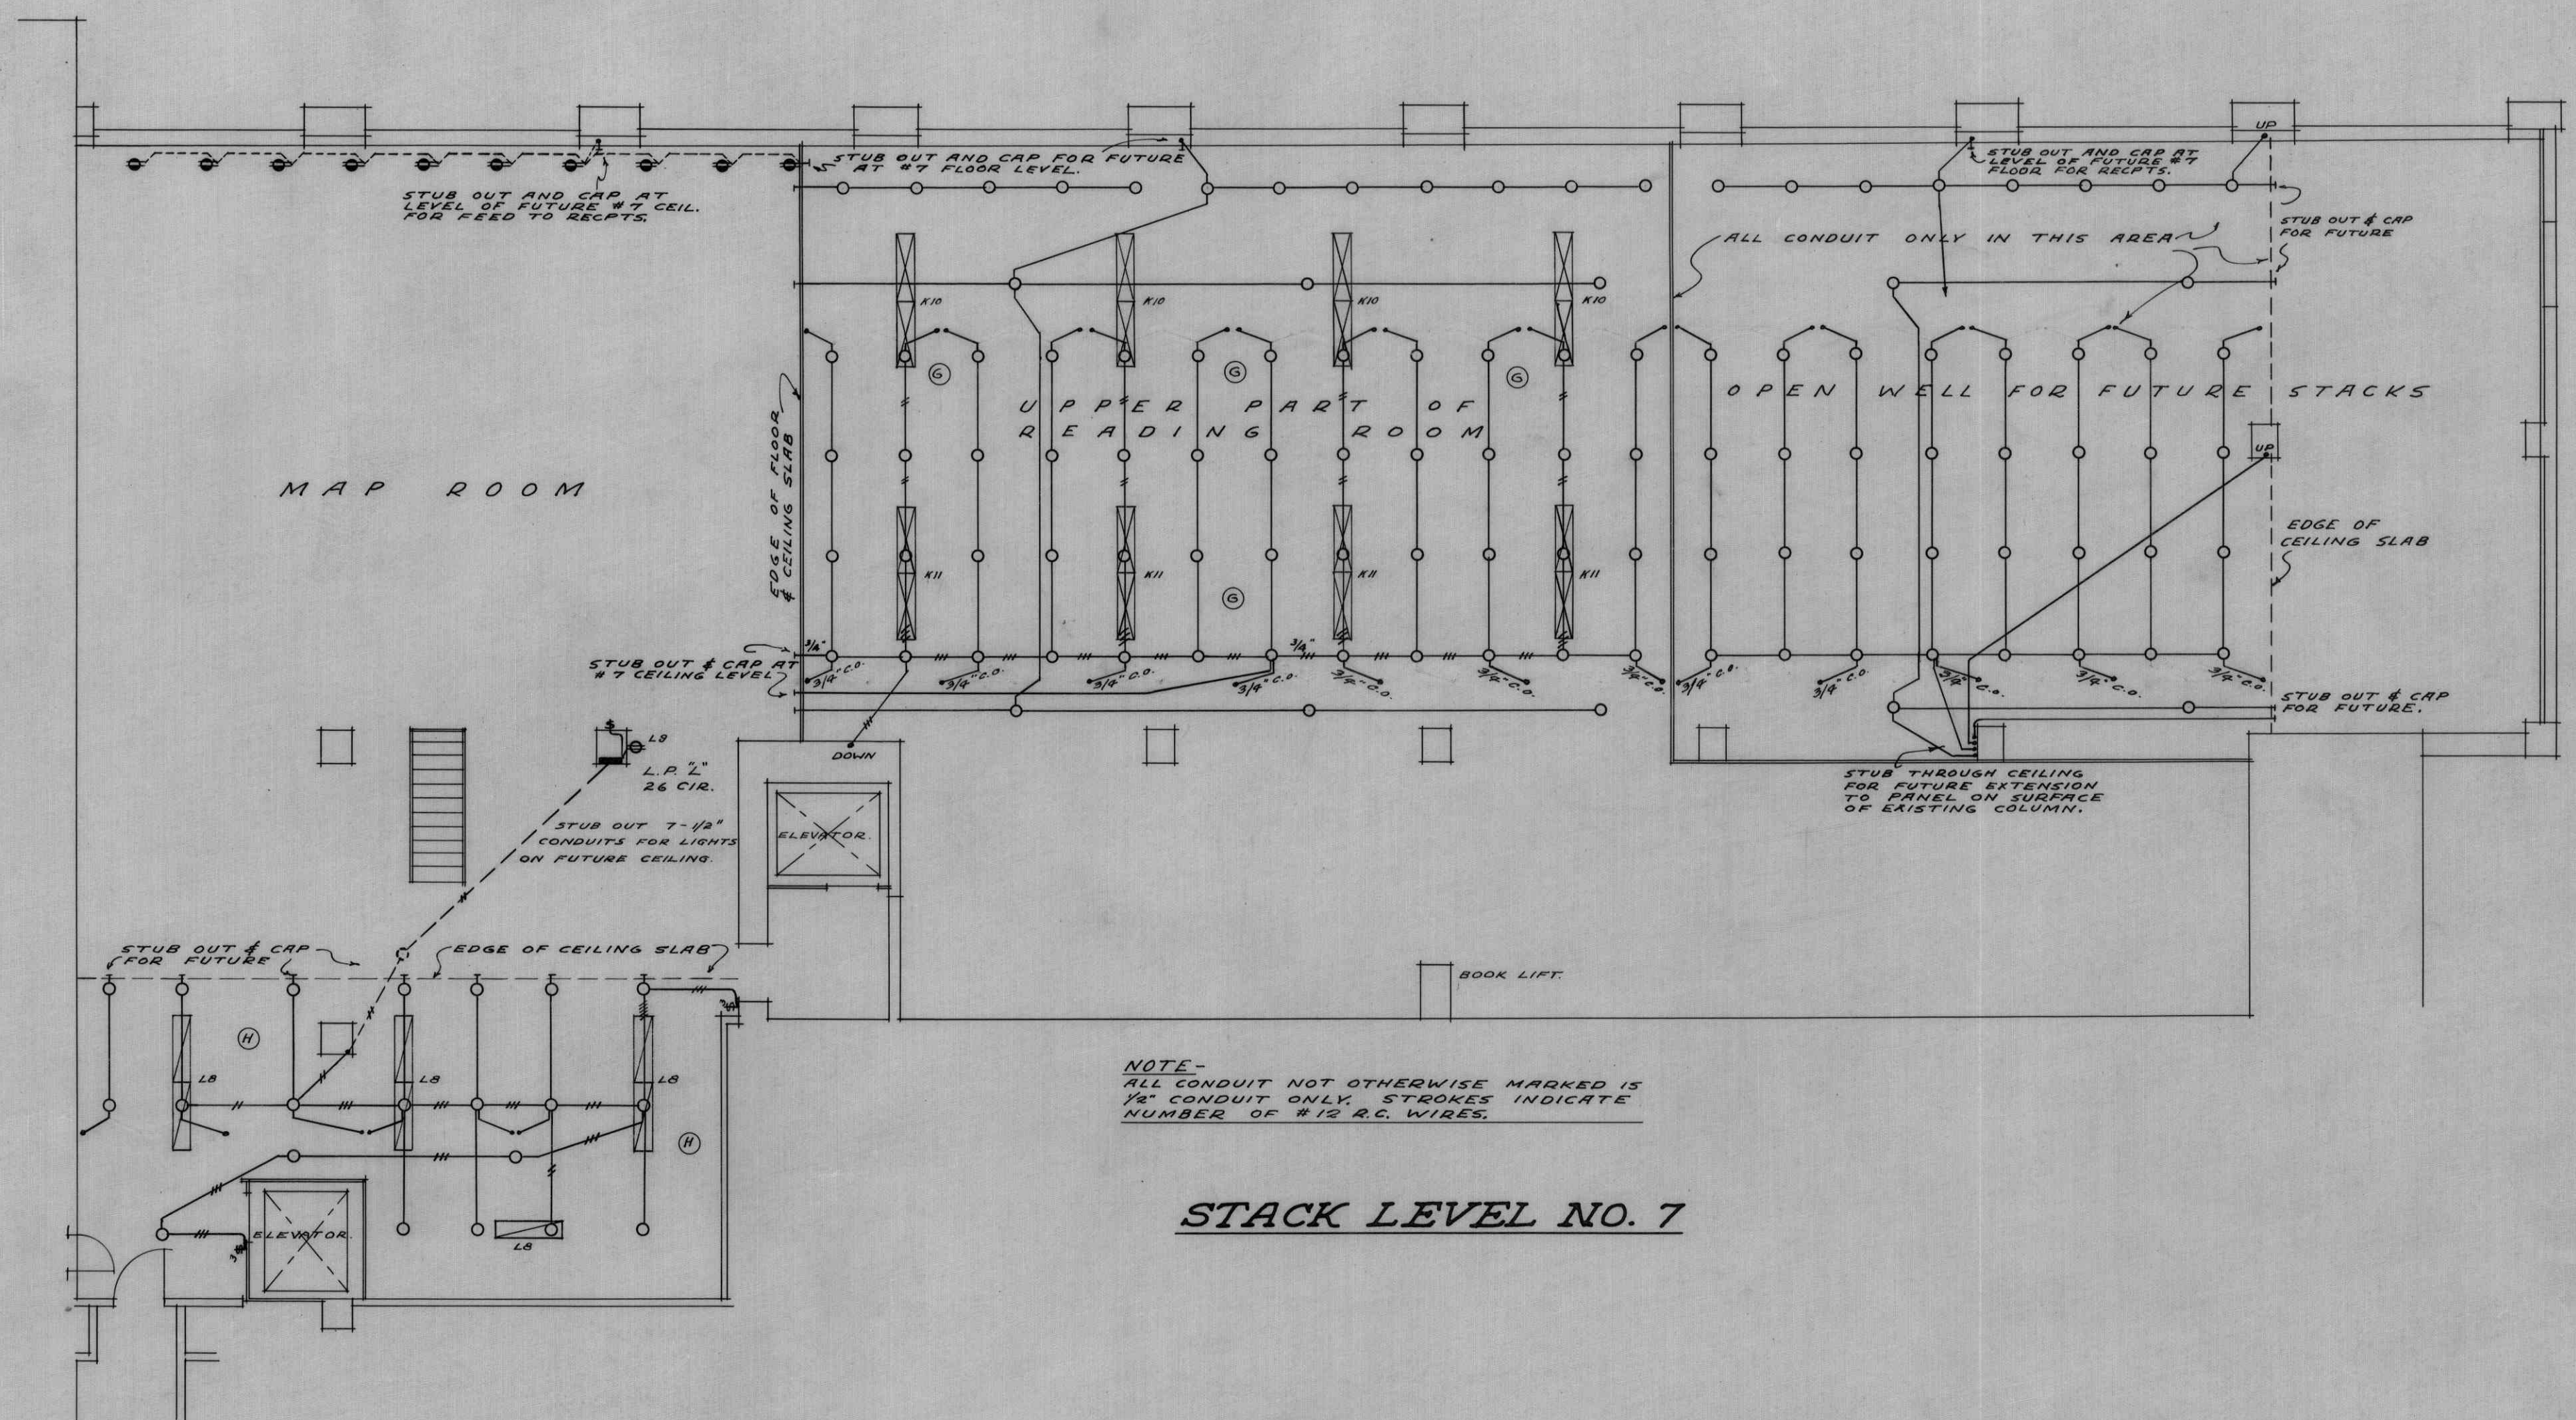

STACK LEVEL NO. 7

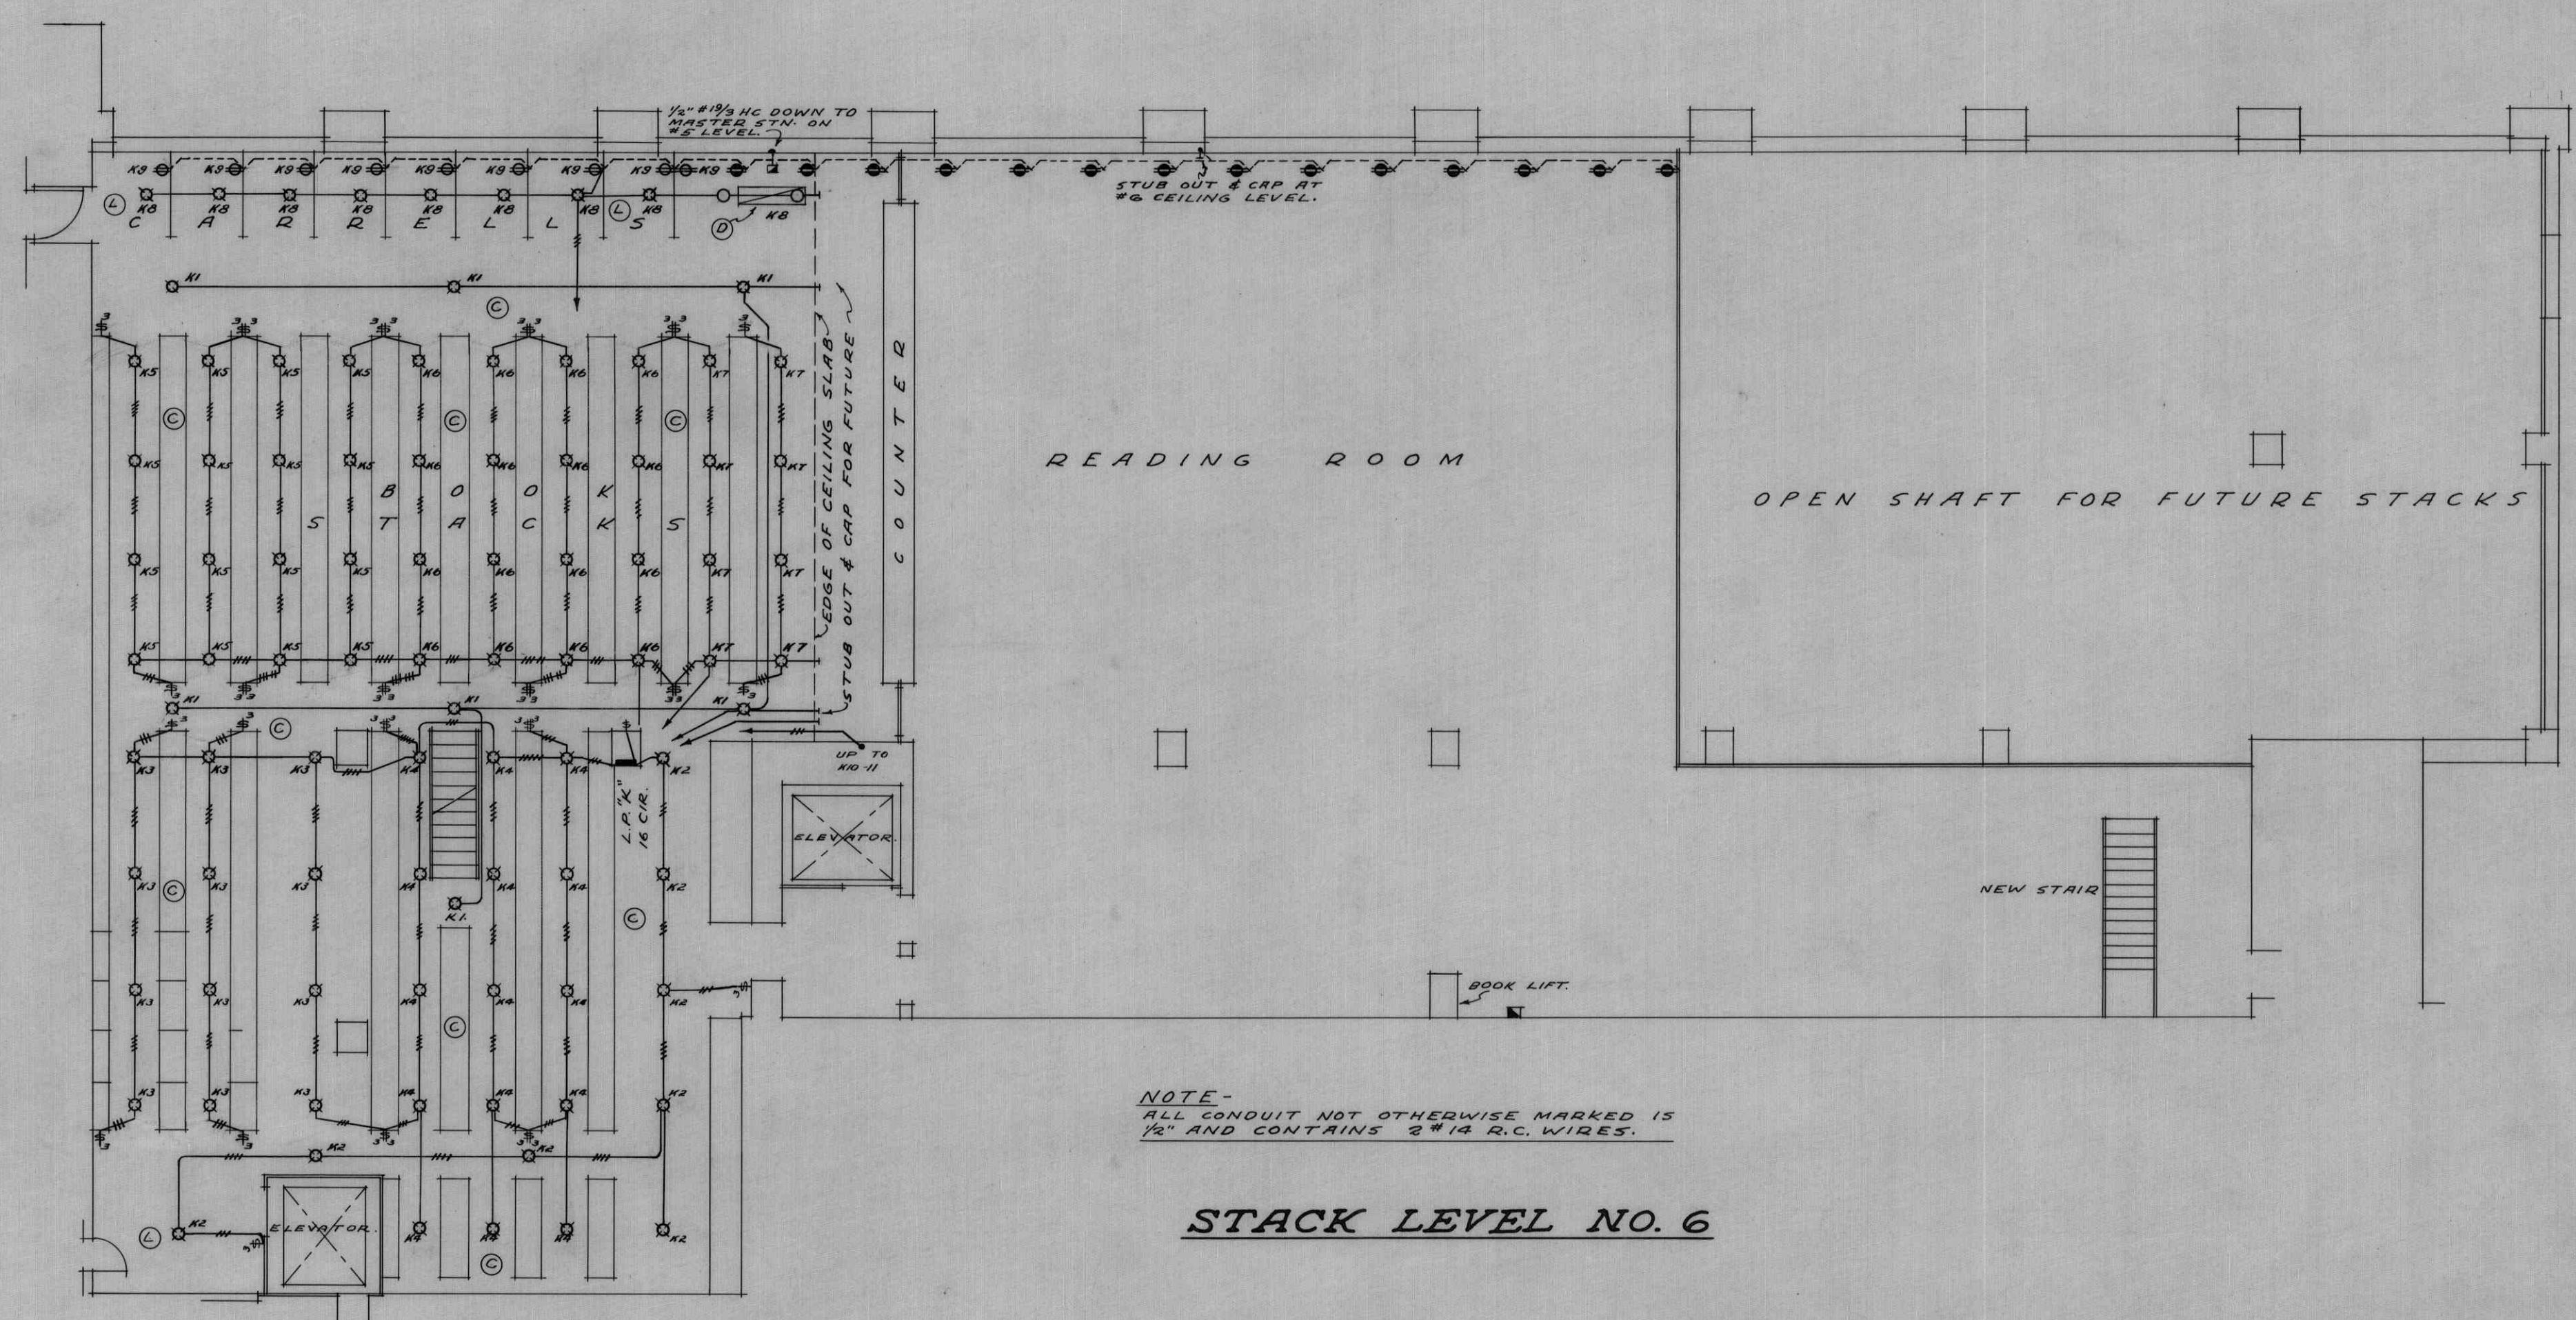

STACK LEVEL NO. 6

ELECTRICAL PLAN
STACK LEVELS 6 & 7

REVISION DATE 25 JULY 1947	ADDITION TO LIBRARY		SCALE 1/8"=1'-0"
	UNIVERSITY OF B.C.		DATE 25 JULY, 1946
	A. EDWARD SIMPSON ELECTRICAL ENGINEER VANCOUVER, B.C.	SHARP & THOMPSON ARCHITECTS VANCOUVER, B.C.	DRAWING NO. U2-5-6