
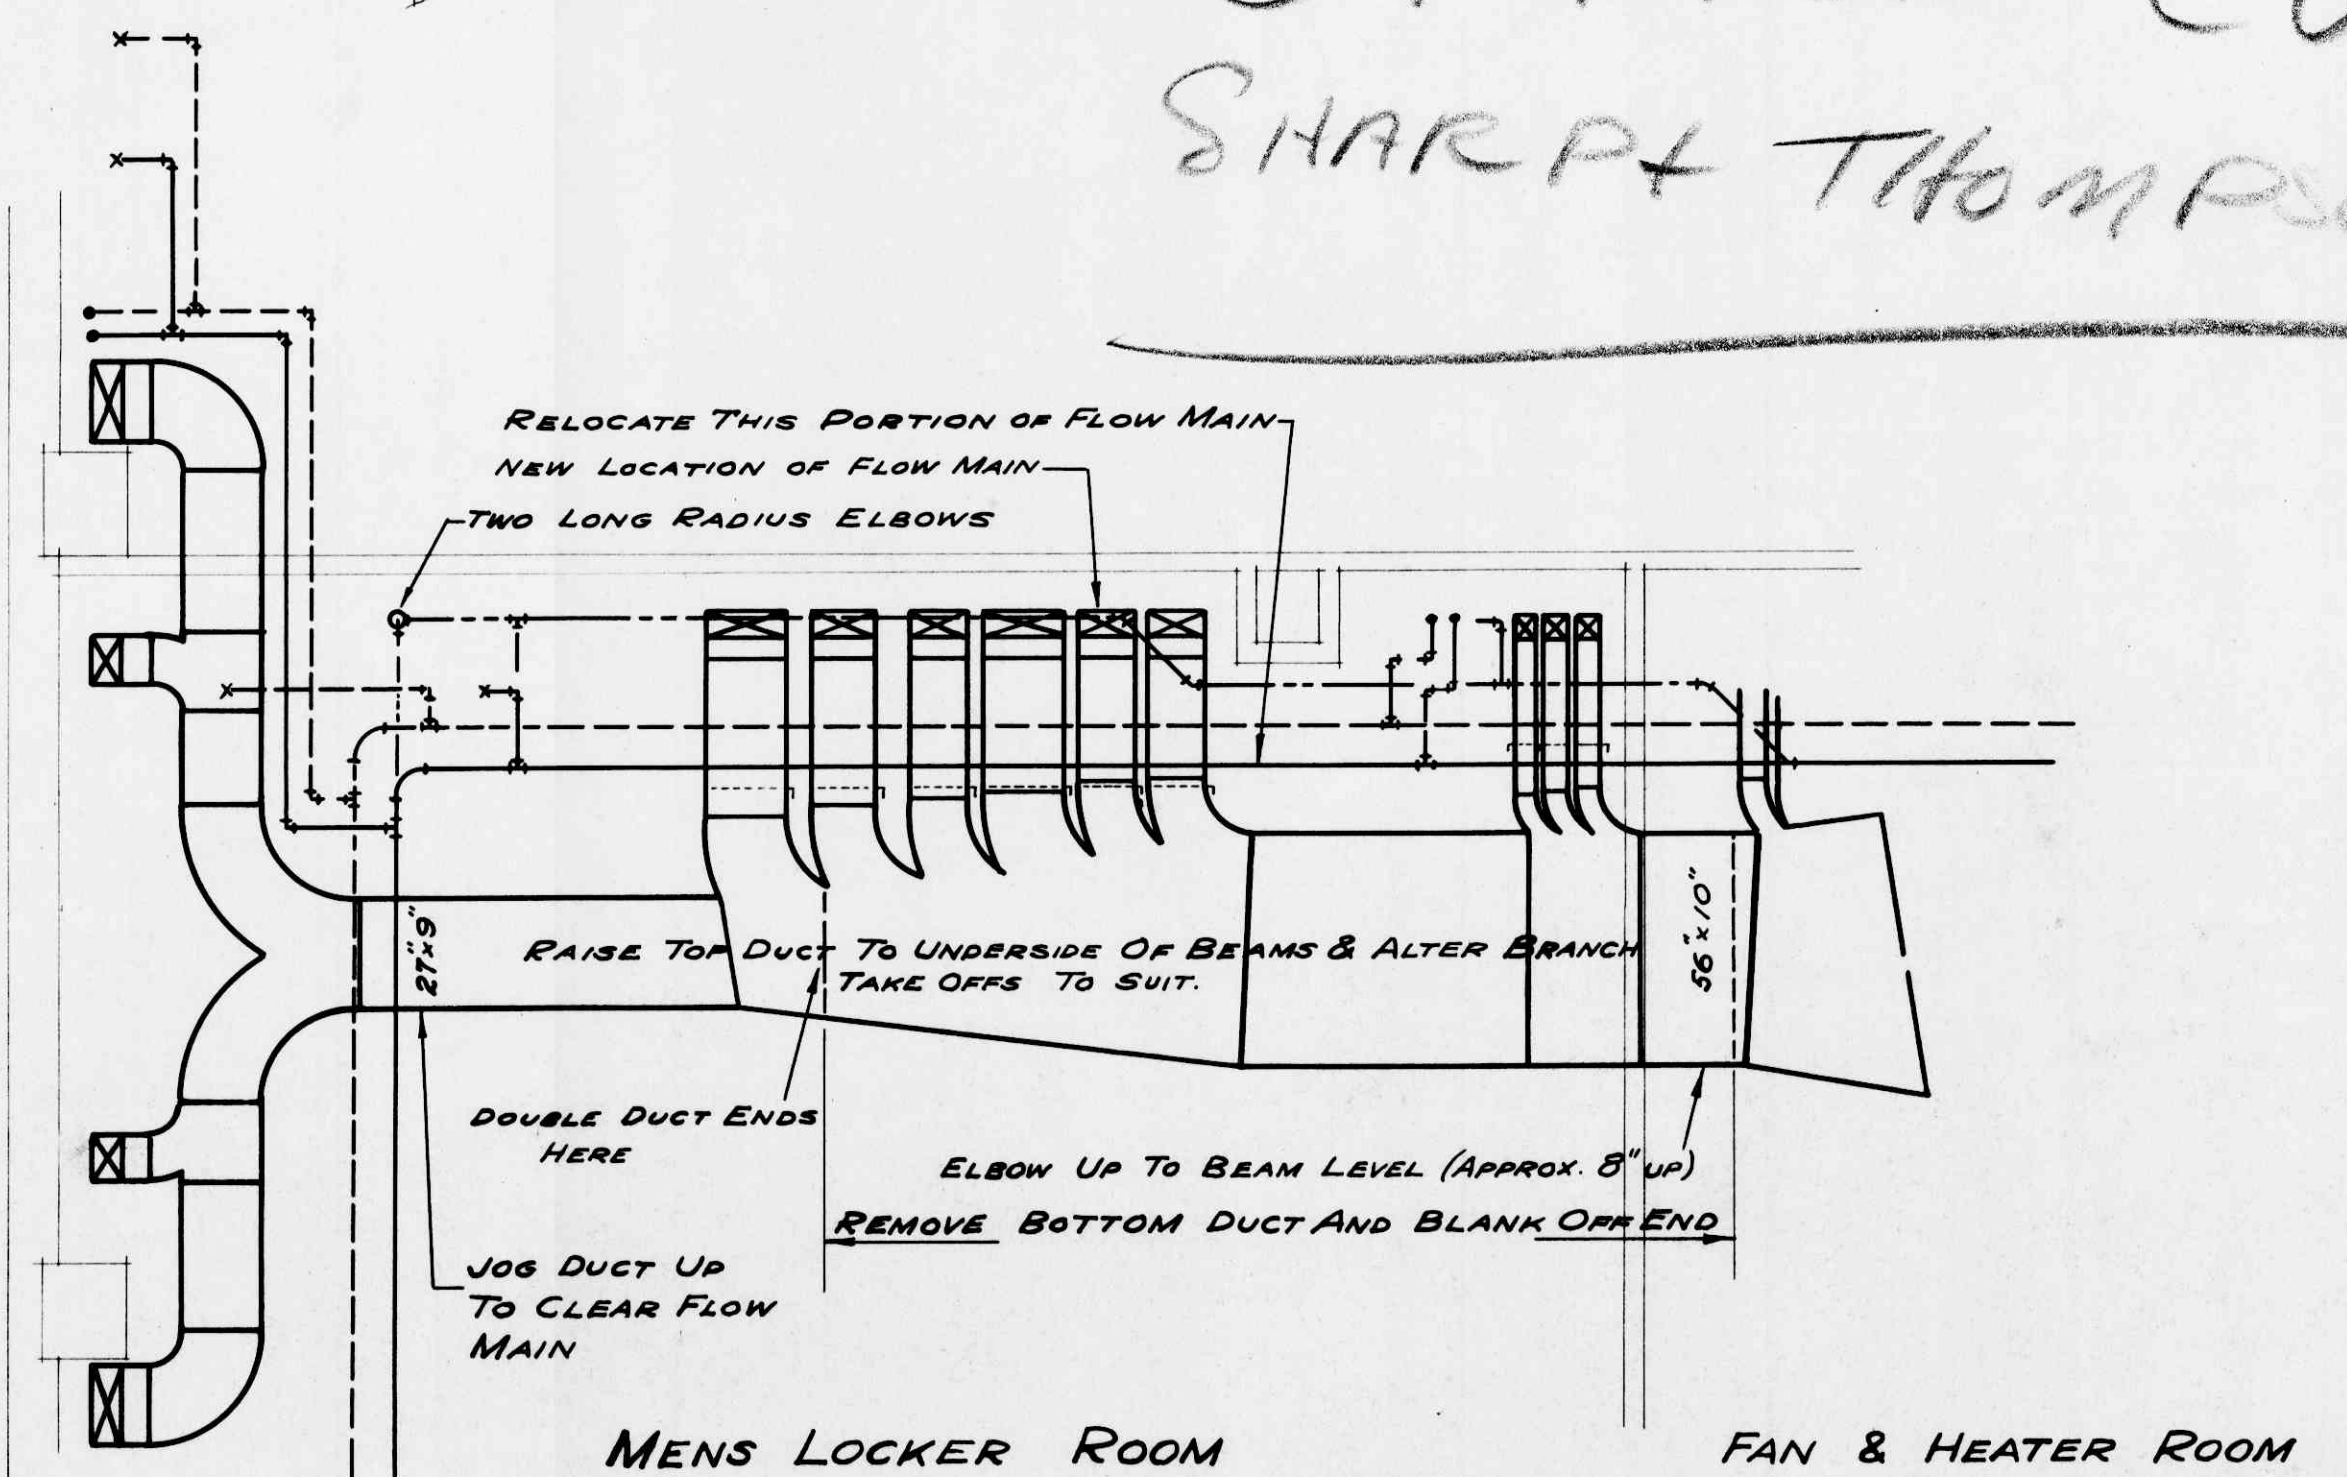
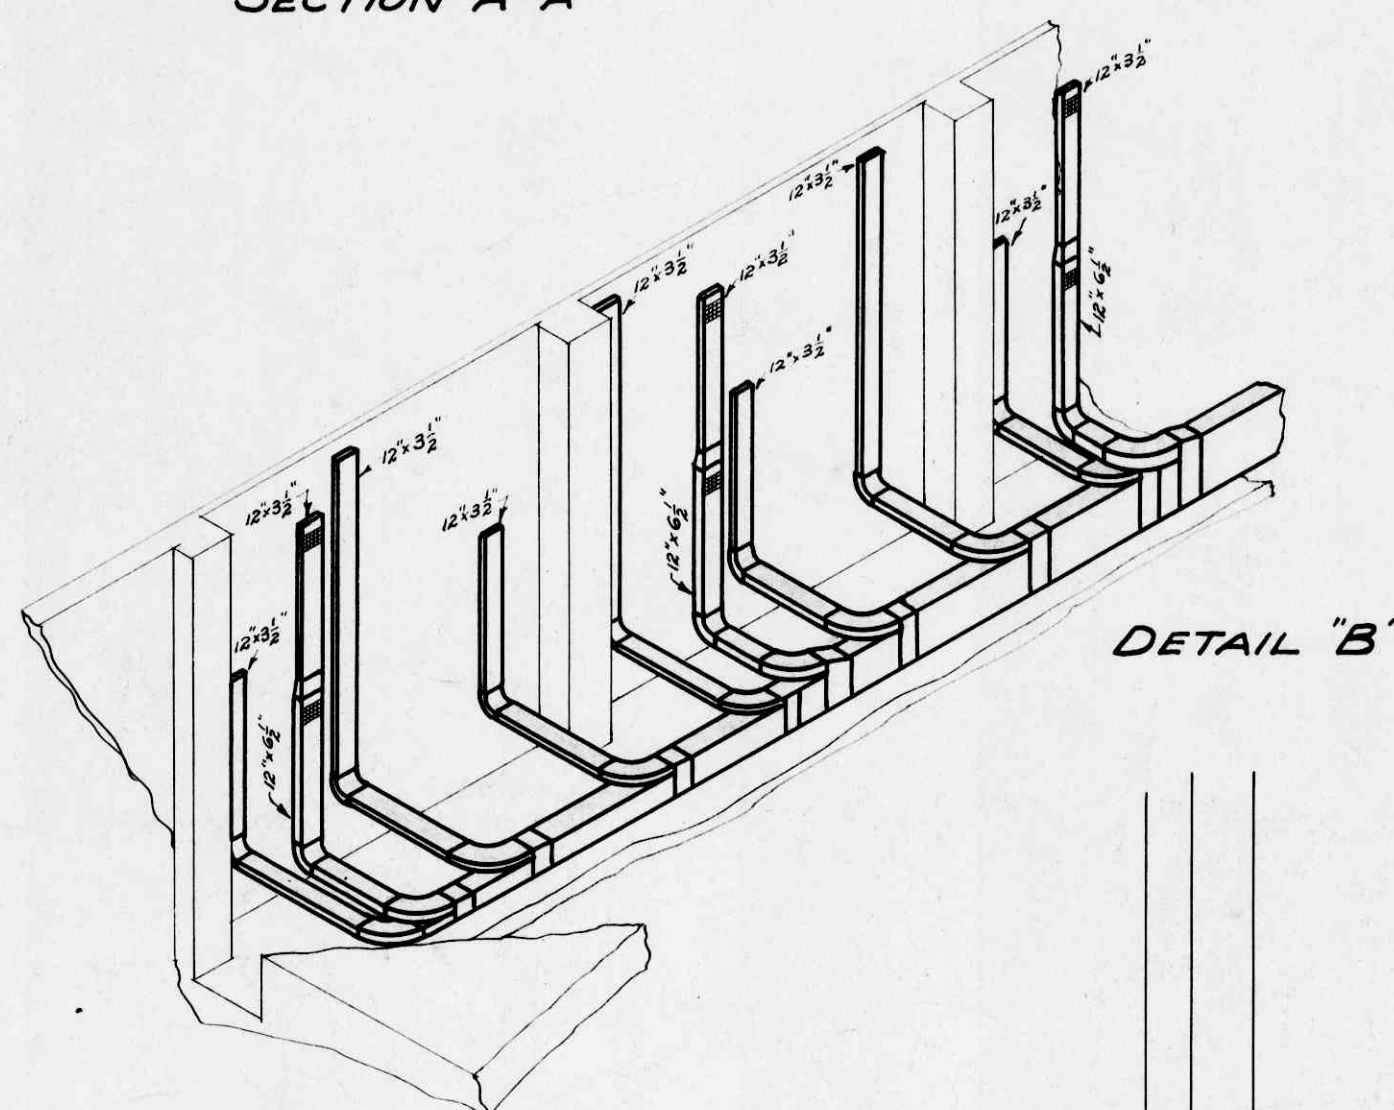
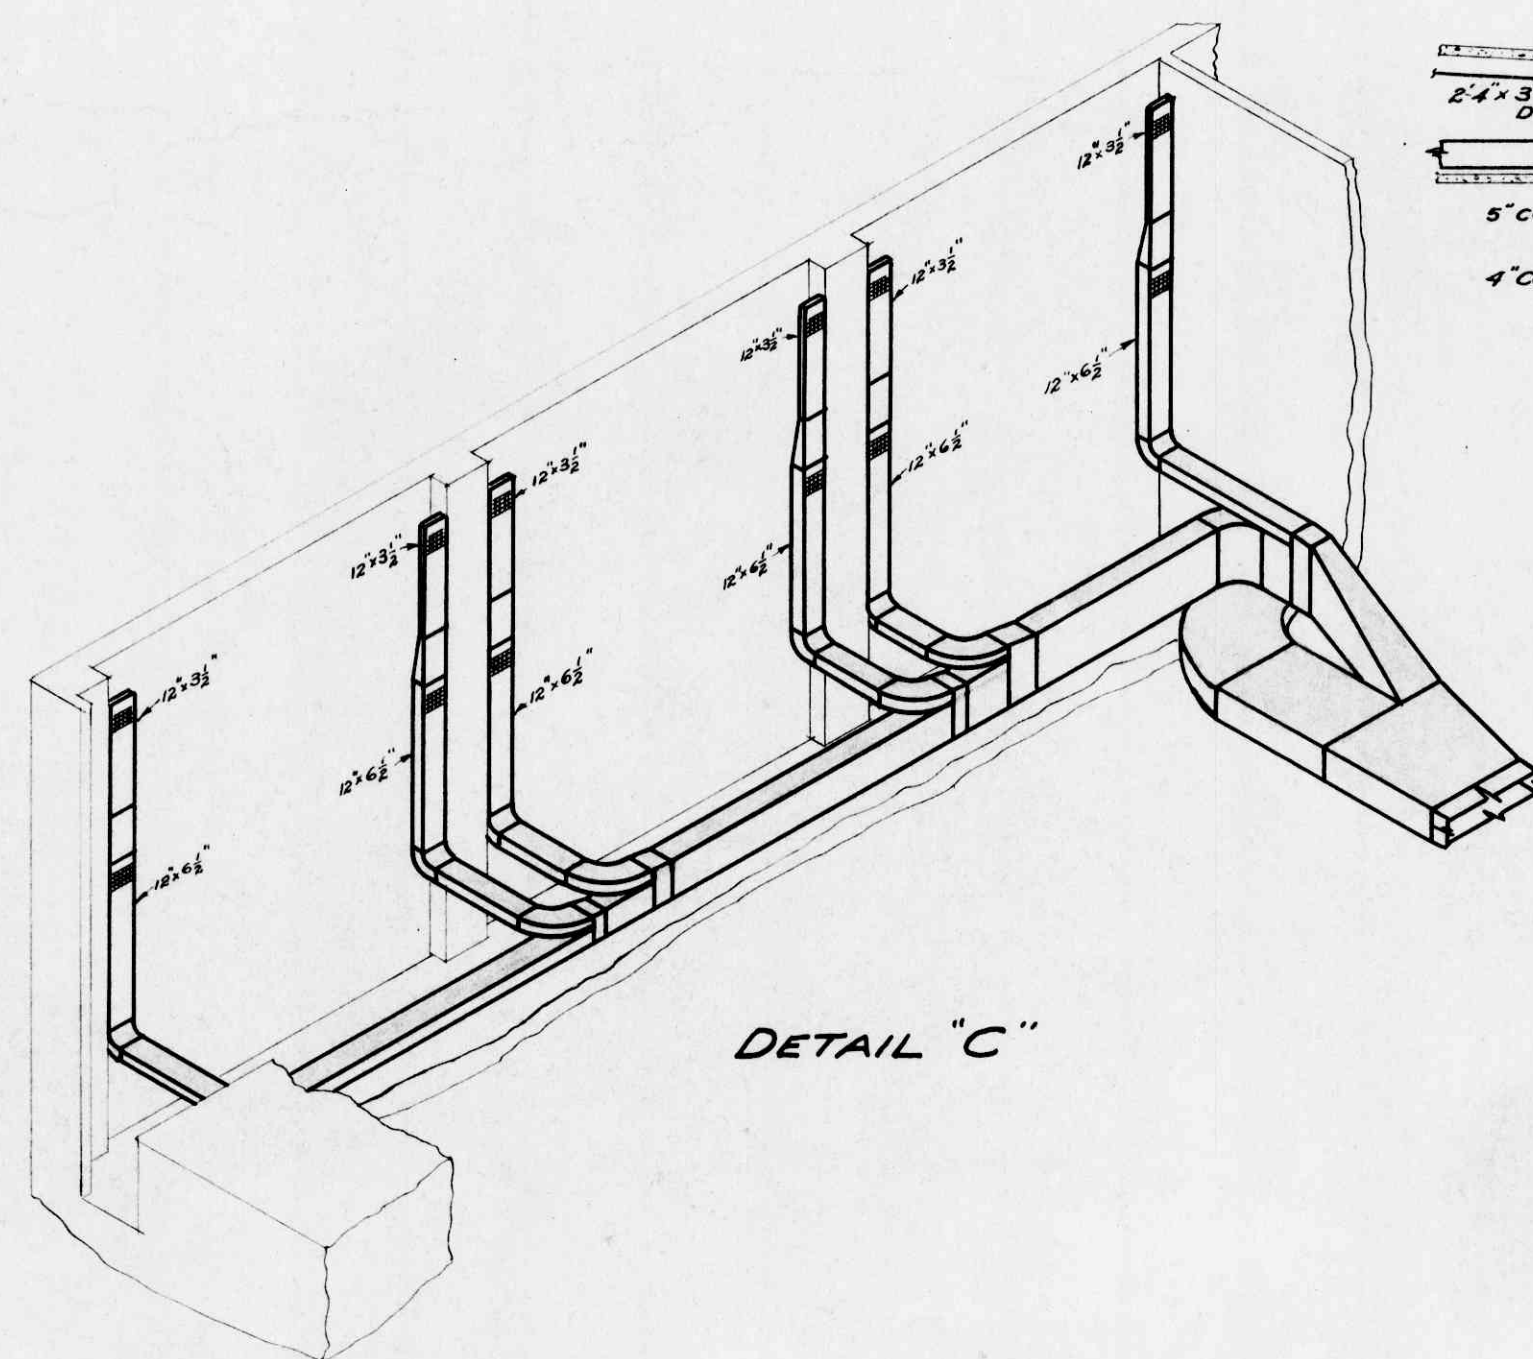
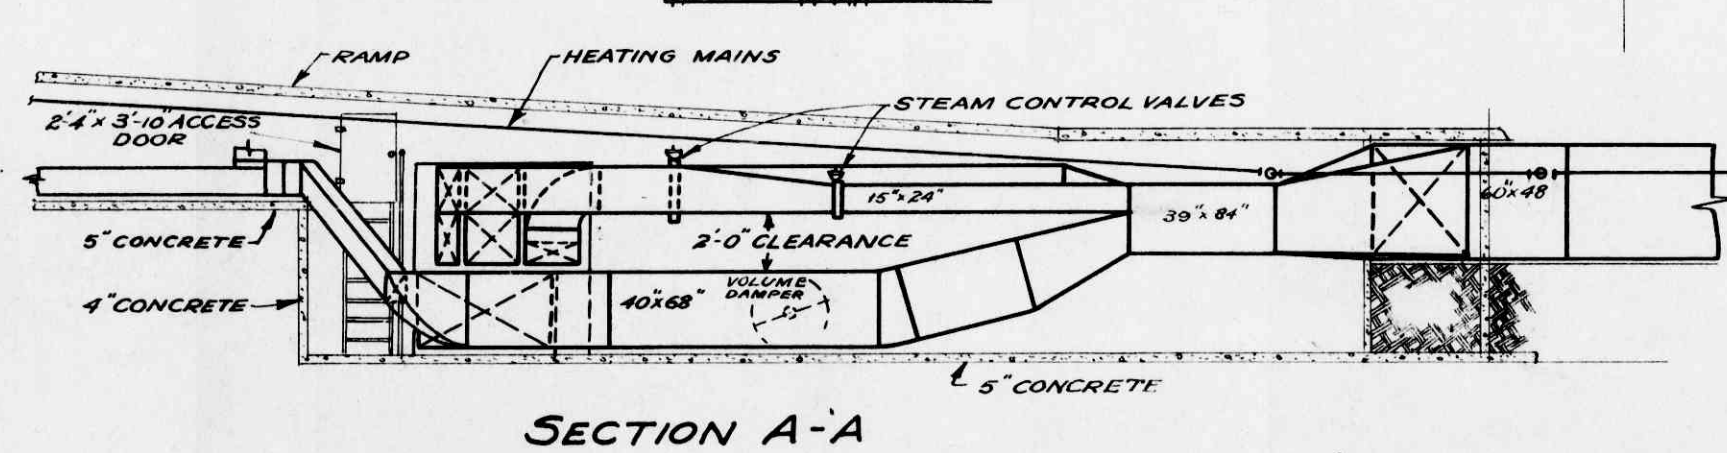
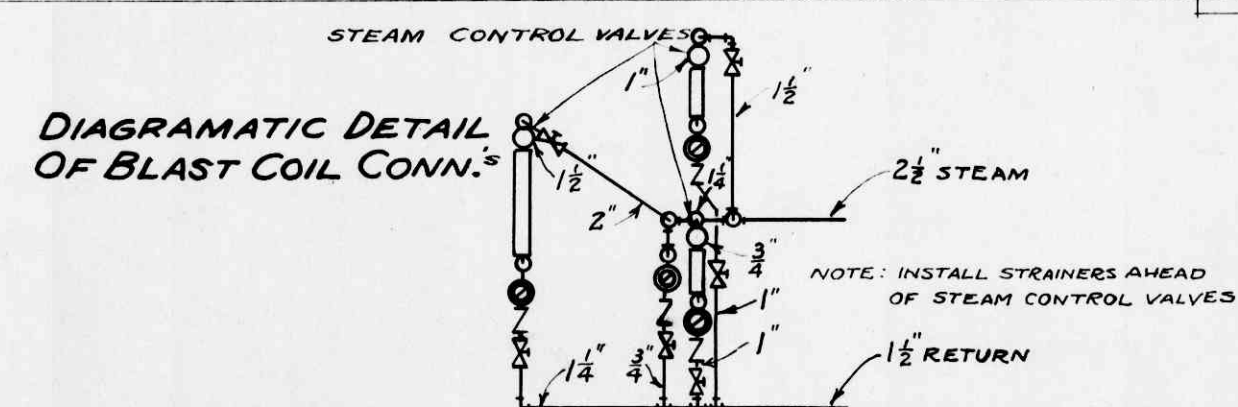


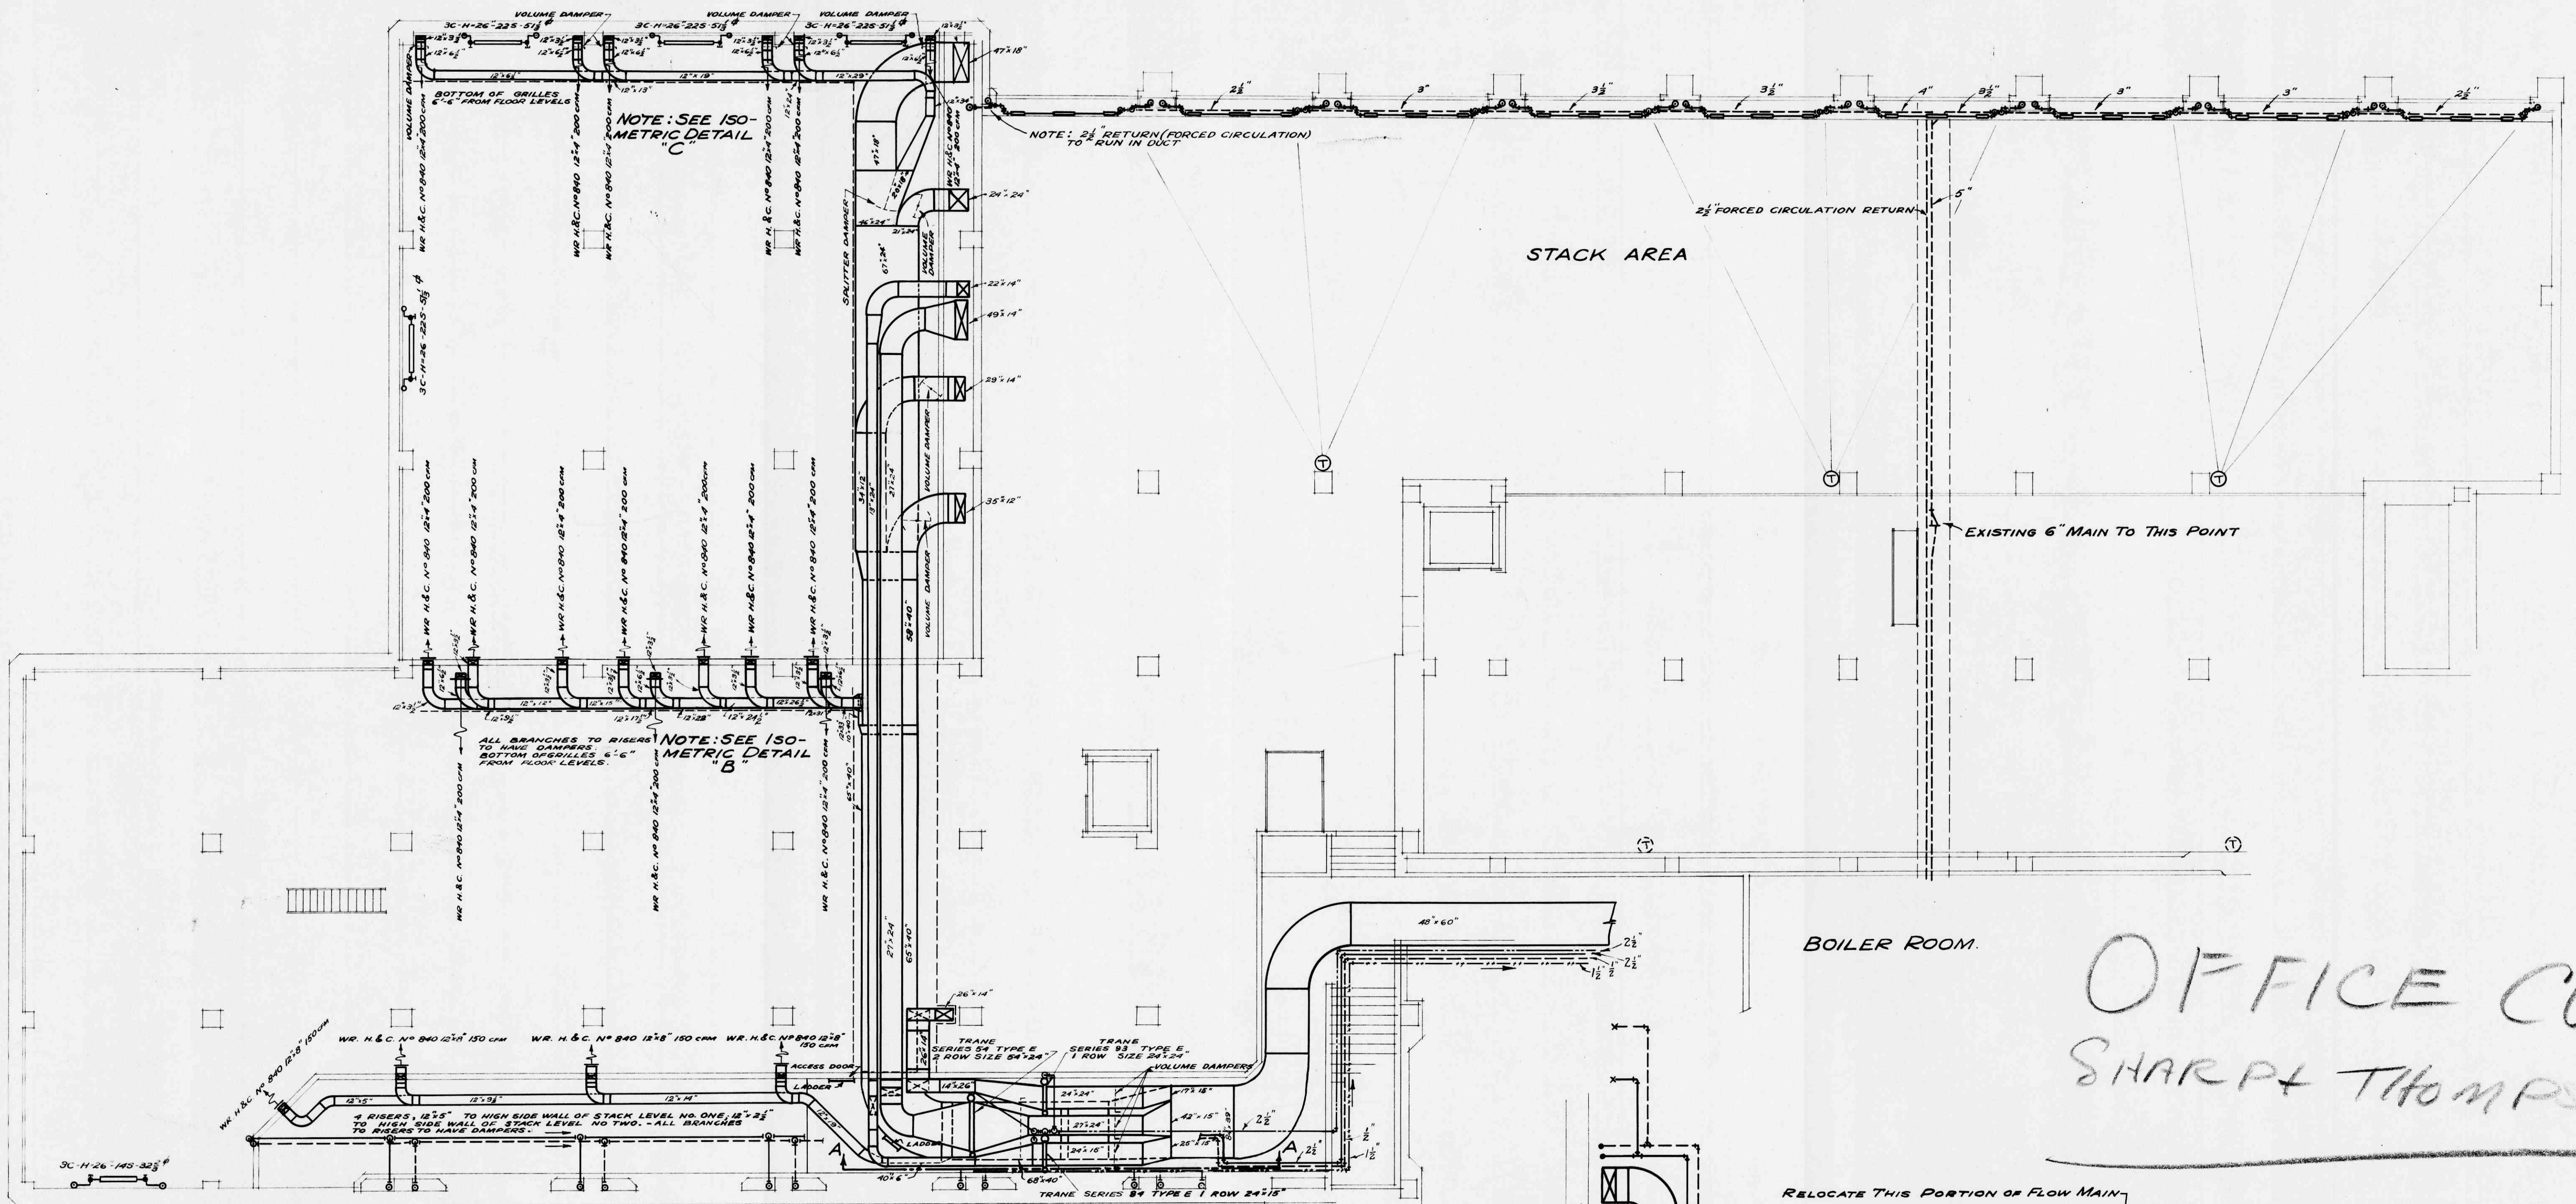

DETAIL OF ALTERATIONS TO PRESENT PIPING & DUCTWORK.

MK.	DESCRIPTION	DATE	BASEMENT FLOOR PLAN		DRAWING NUMBER	SET NUMBER
			ADDITION TO LIBRARY			
			SCALE - 1/8" = 1'-0"			
			DATE - MAY 10 1946			
UNIVERSITY OF B.C.				D.W. THOMSON - B.A.Sc.; M.S. - HEATING & VENTILATION SHARP & THOMPSON ARCHITECTS		
					1	U1B